



MATCH LINE STA. 3942+00
SEE DRAWING DE-03

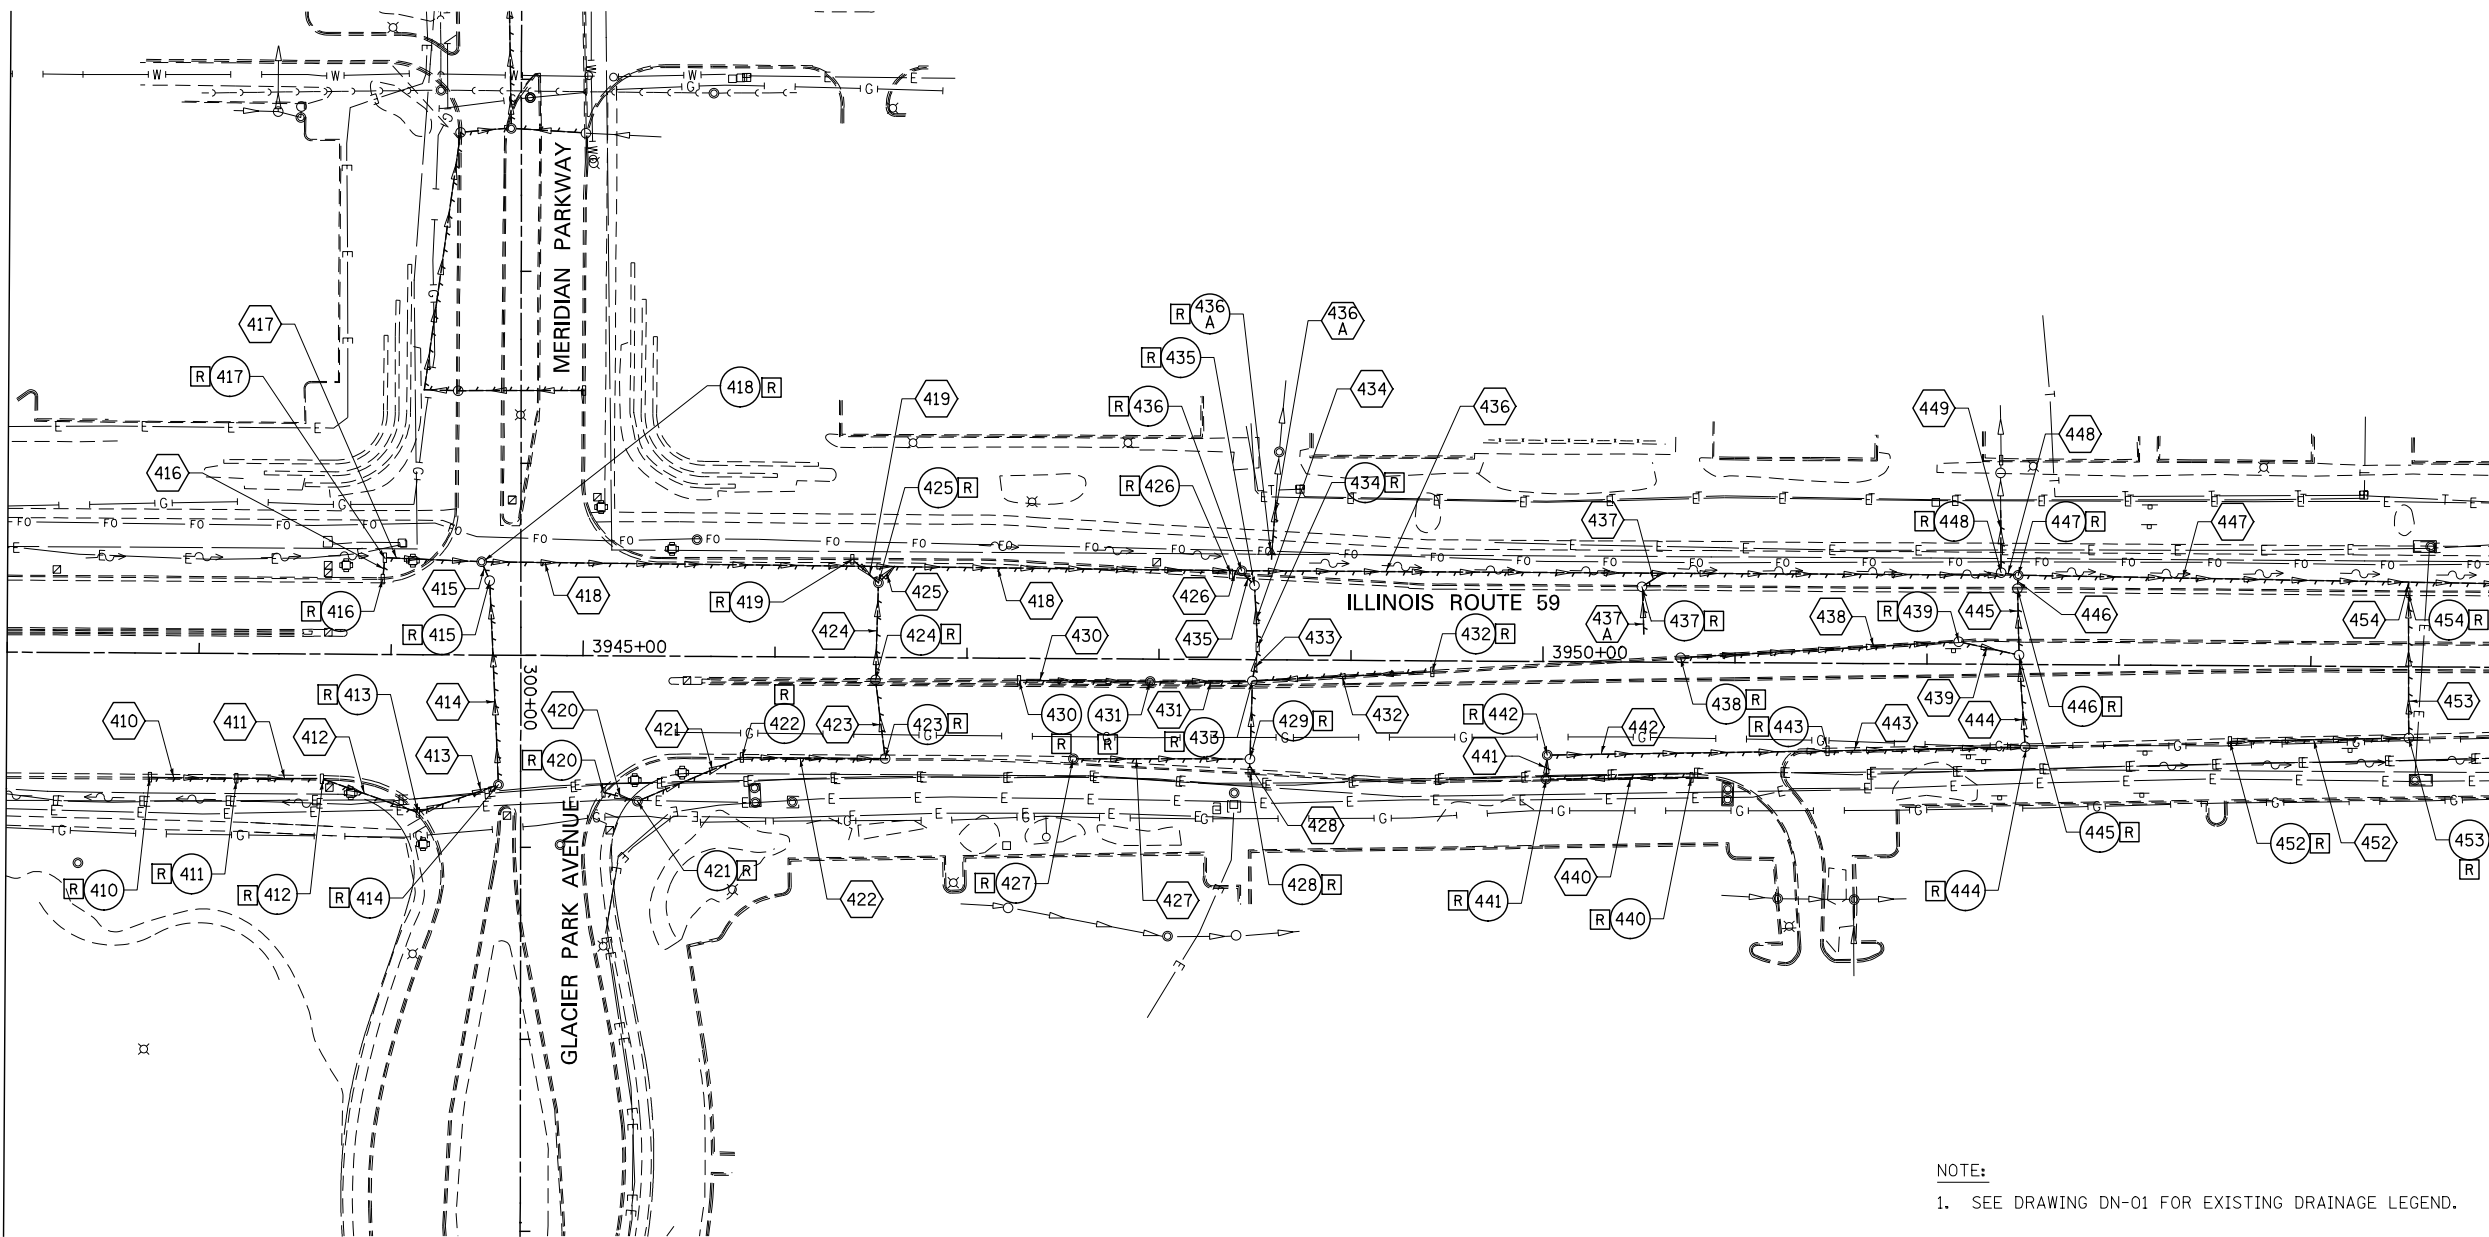

MATCH LINE STA. 3955+00
SEE DRAWING DE-05

NOTE:
1. SEE DRAWING DN-01 FOR EXISTING DRAINAGE LEGEND.

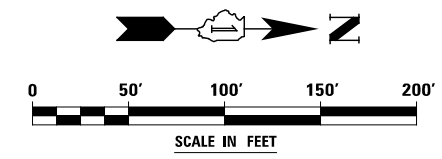

	DESIGNED <i>PJO</i>	REVISED -	STATE OF ILLINOIS DEPARTMENT OF TRANSPORTATION	EXISTING DRAINAGE PLAN - ILLINOIS ROUTE 59		F.A.P. RTE.	SECTION	COUNTY	TOTAL SHEETS	SHEET NO.	
	DRAWN <i>KES</i>	REVISED -				338	(112 & 113) WRS-7	DUPAGE	1156	455	
	CHECKED <i>JCM</i>	REVISED -				DE-04		CONTRACT NO. 60R30			
	DATE <i>12/14/2012</i>	REVISED -				ILLINOIS FED. AID PROJECT					
			SCALE: AS SHOWN		SHEET NO. 4 OF 15 SHEETS	STA. 3943+00 TO STA. 3955+00					