



MATCH LINE STA. 298+00  
SEE DRAWING DE-11

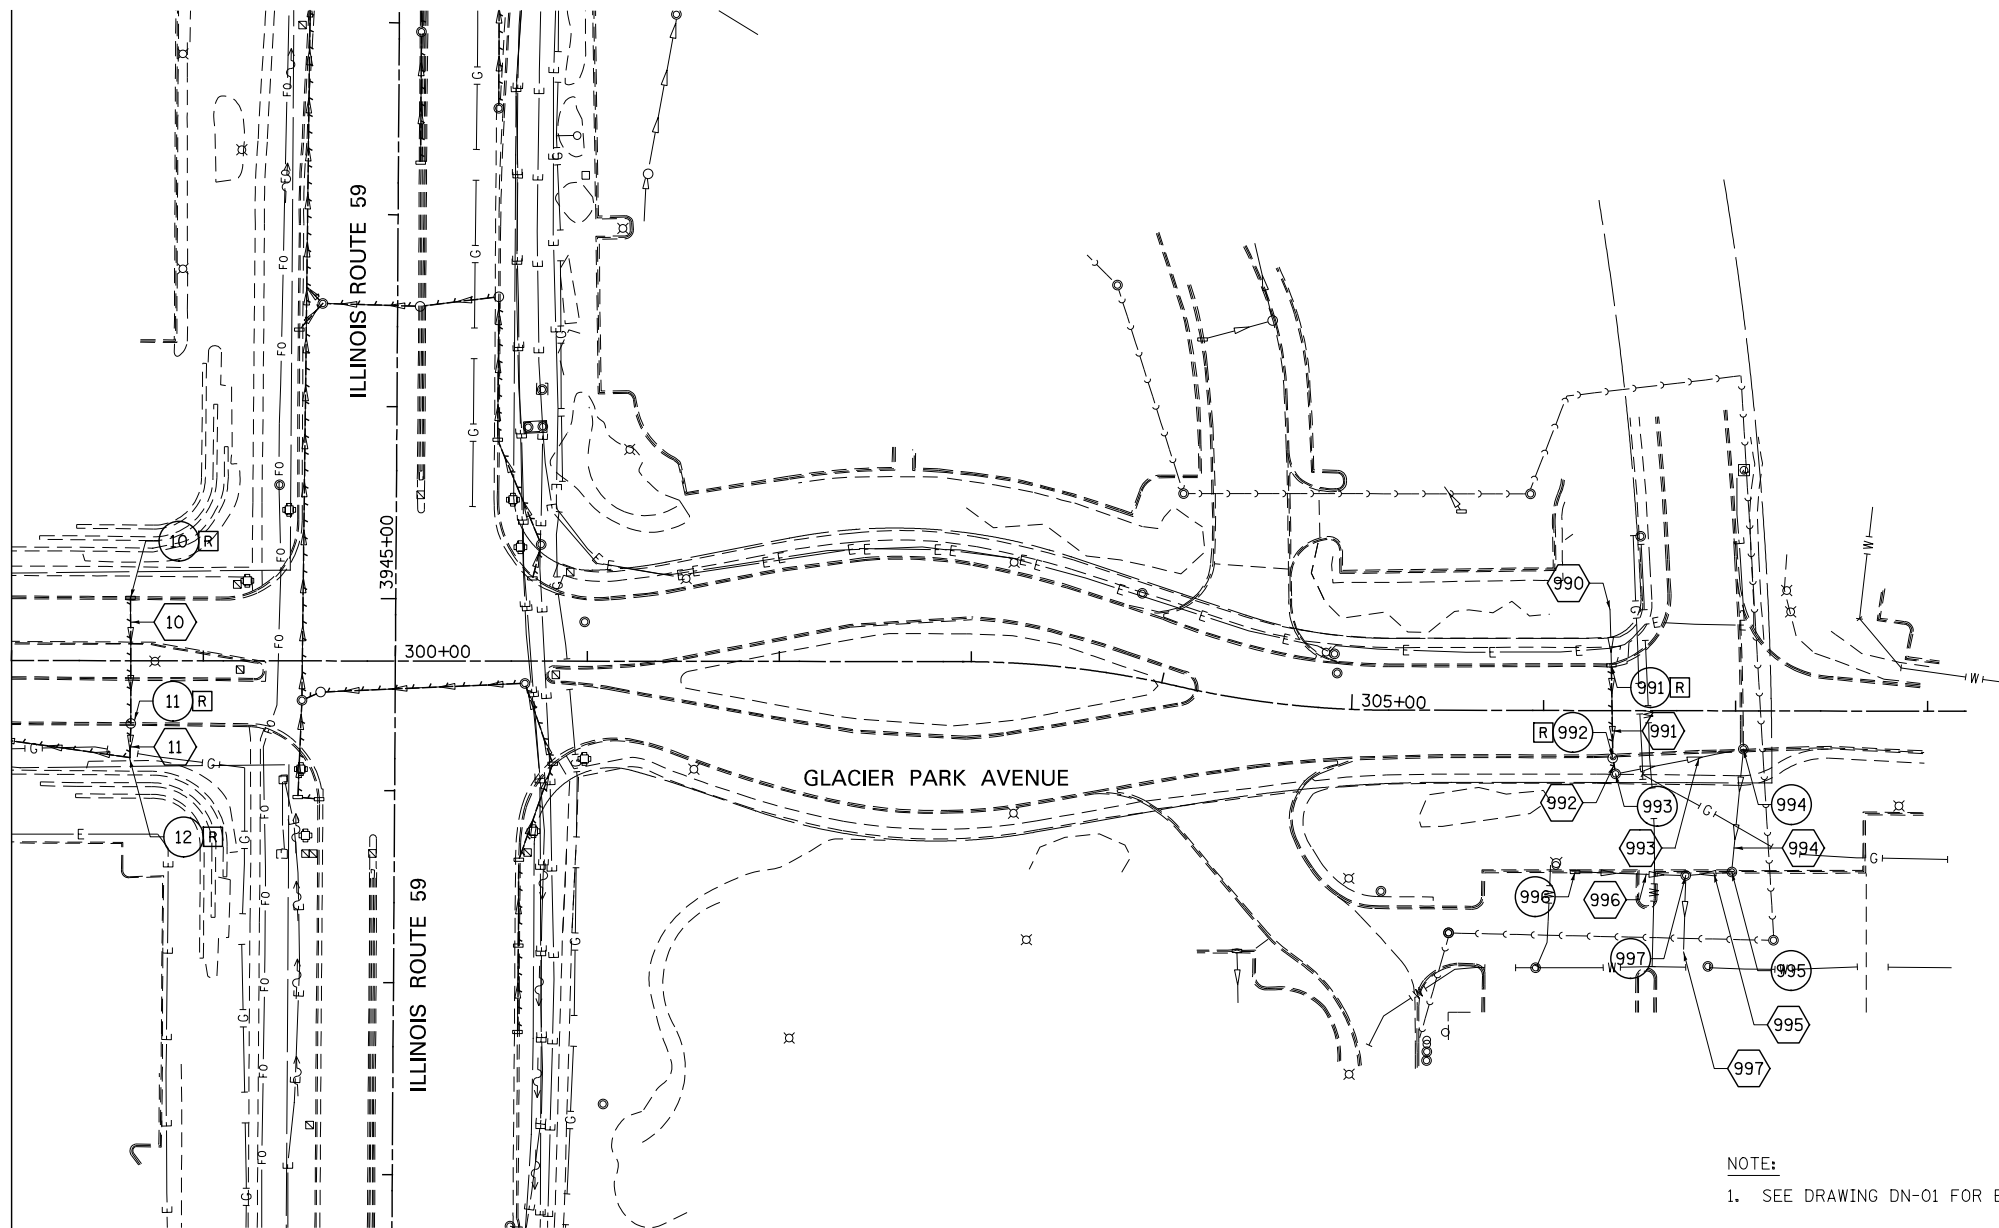

NOTE:

1. SEE DRAWING DN-01 FOR EXISTING DRAINAGE LEGEND.

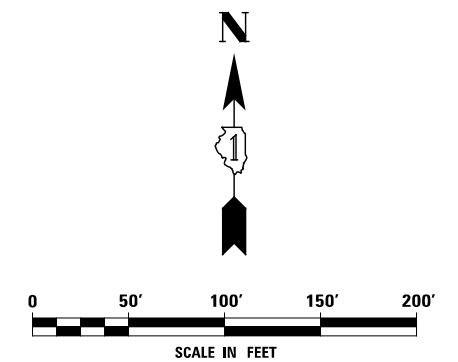

DESIGNED	PJO	REVISED	-
DRAWN	KES	REVISED	-
CHECKED	JCM	REVISED	-
DATE	12/14/2012	REVISED	-

STATE OF ILLINOIS  
DEPARTMENT OF TRANSPORTATION

EXISTING DRAINAGE PLAN - GLACIER PARK AVENUE

SCALE: AS SHOWN SHEET NO. 12 OF 15 SHEETS STA. 298+00 TO STA. END

F.A.P. RTE.	SECTION	COUNTY	TOTAL SHEETS	SHEET NO.
338	(112 & 113) WRS-7	DUPAGE	1156	463
<b>DE-12</b>			CONTRACT NO. 60R30	
ILLINOIS FED. AID PROJECT				