



DATE	
BY	
DESIGNED	
DRAWN	
CHECKED	
DATE	

DATE	
BY	
DESIGNED	
DRAWN	
CHECKED	
DATE	

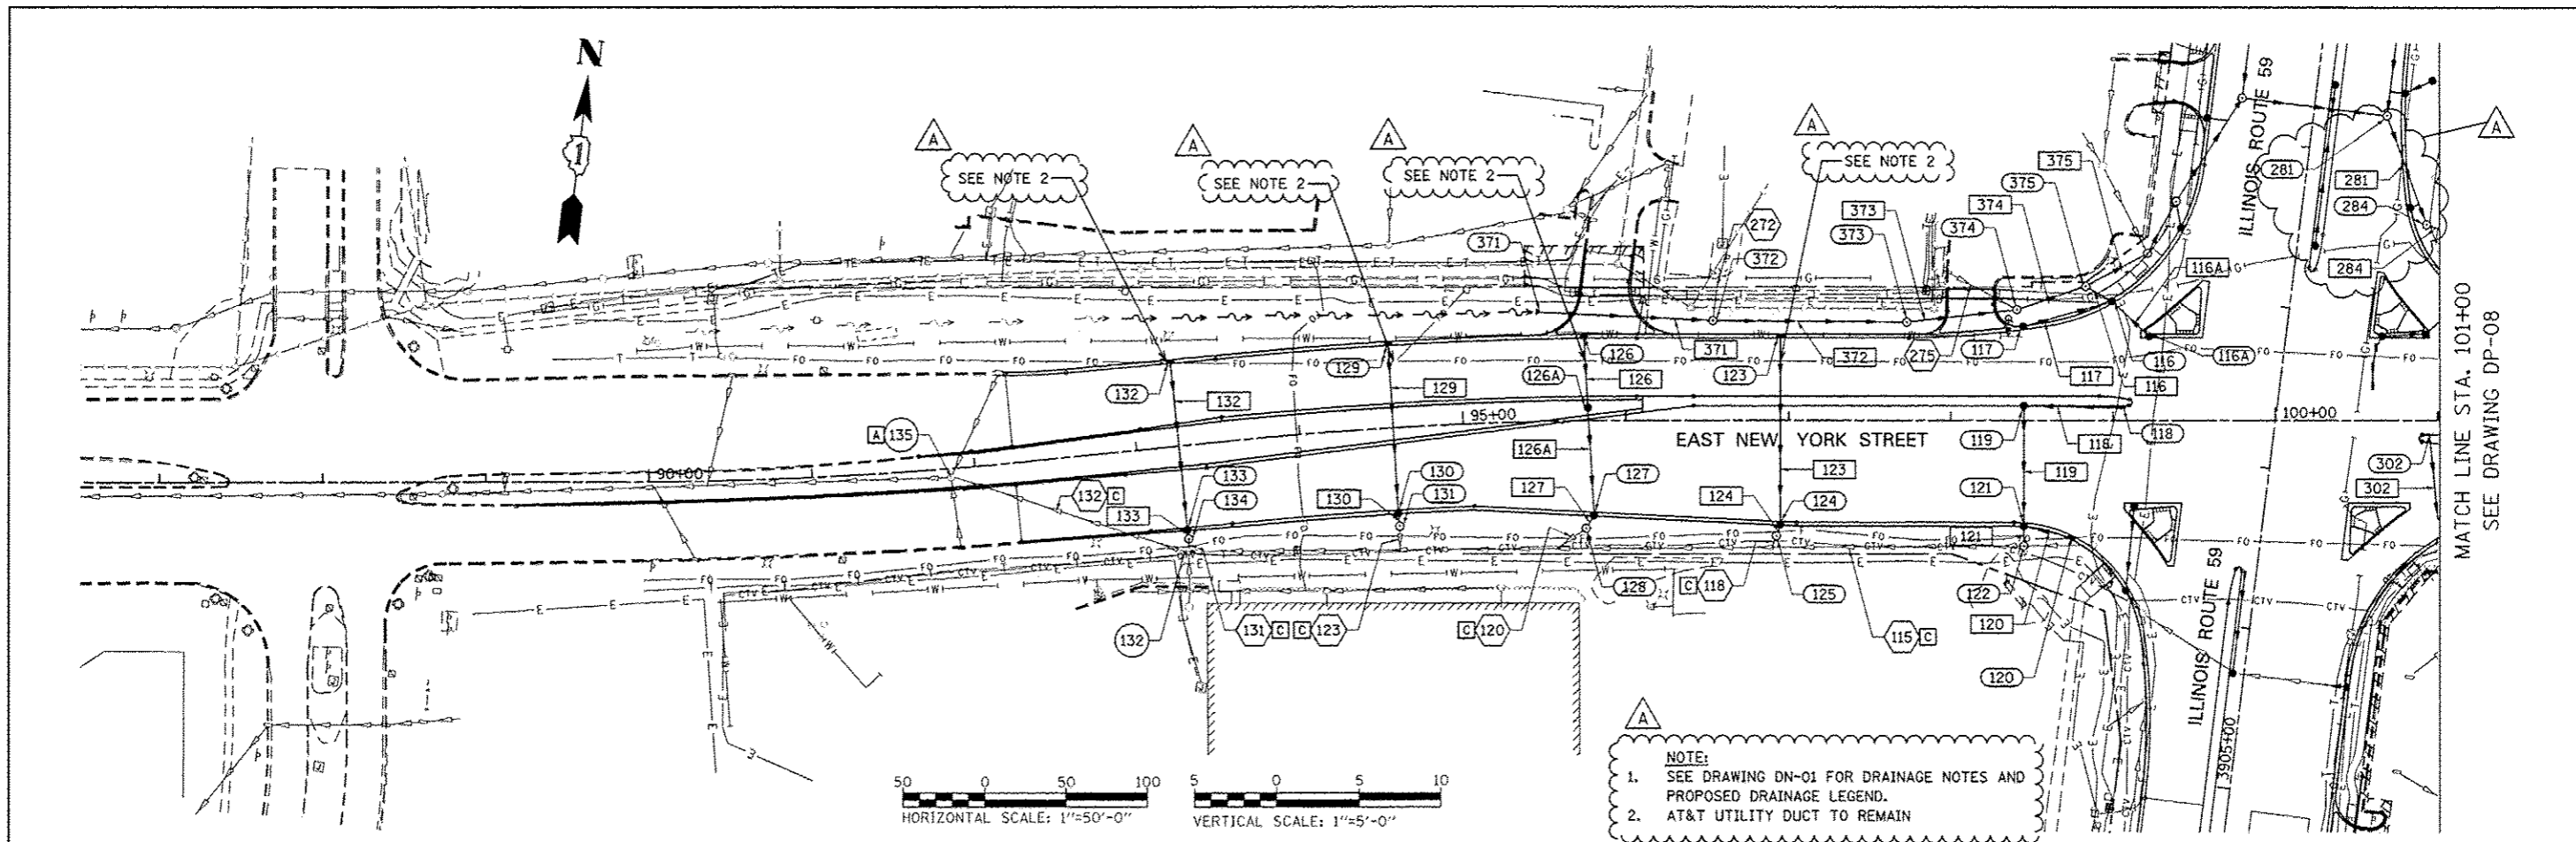

MATCH LINE STA. 101+00
SEE DRAWING DP-08

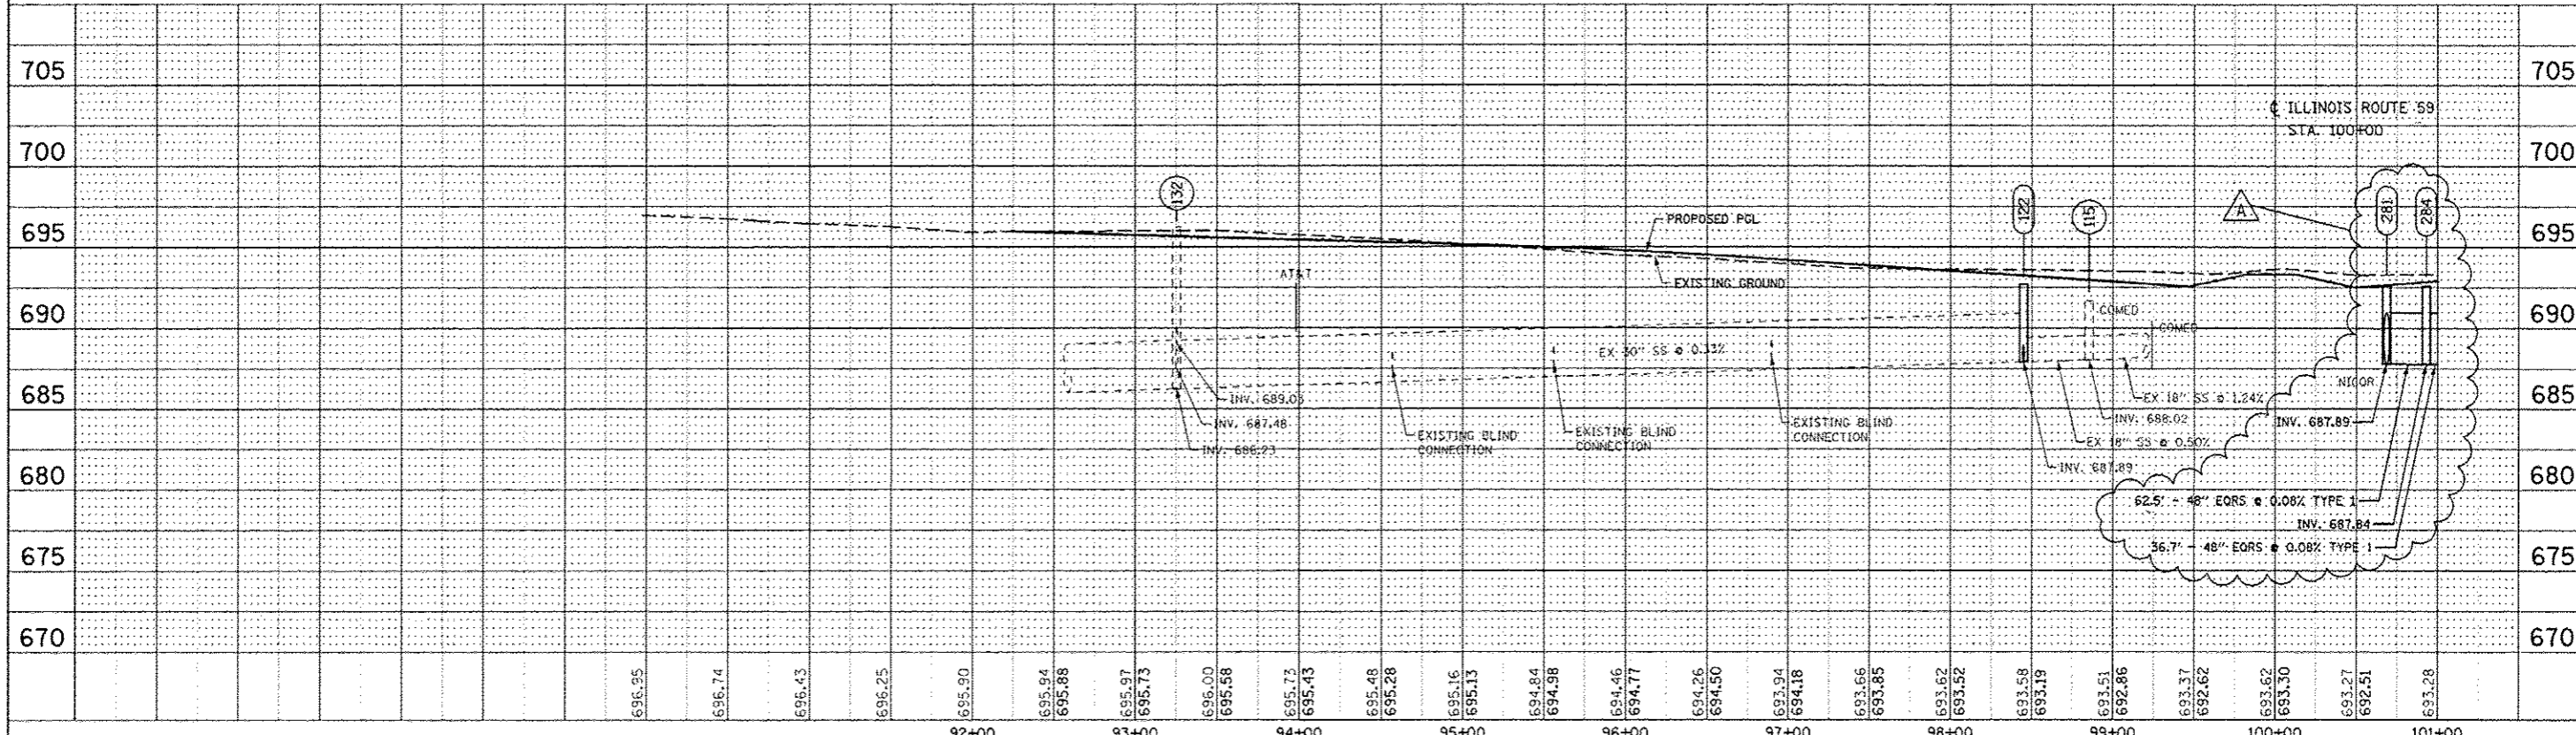

DESIGNED	JWM	REVISED - ADDENDUM A 02/20/2013
DRAWN	KES	REVISED -
CHECKED	JRS	REVISED -
DATE	12/14/2012	REVISED -

STATE OF ILLINOIS
DEPARTMENT OF TRANSPORTATION

PROPOSED DRAINAGE PLAN & PROFILE - NEW YORK STREET

F.A.P. RTE.	SECTION	COUNTY	TOTAL SHEETS	SHEET NO.
338	112 & 113 WRS-7	DUPAGE	1156	480
DP-07		CONTRACT NO. 60R30		
FED. ROAD DIST. NO.		ILLINOIS FED. AID PROJECT		

SCALE: 1"=50' SHEET NO. 14 OF 25 SHEETS STA. BEGIN TO STA. 101+00