
 


PLAN	DATE
DESIGNED	
DRAWN	
CHECKED	
DATE	


PROFILE	DATE
DESIGNED	
DRAWN	
CHECKED	
DATE	

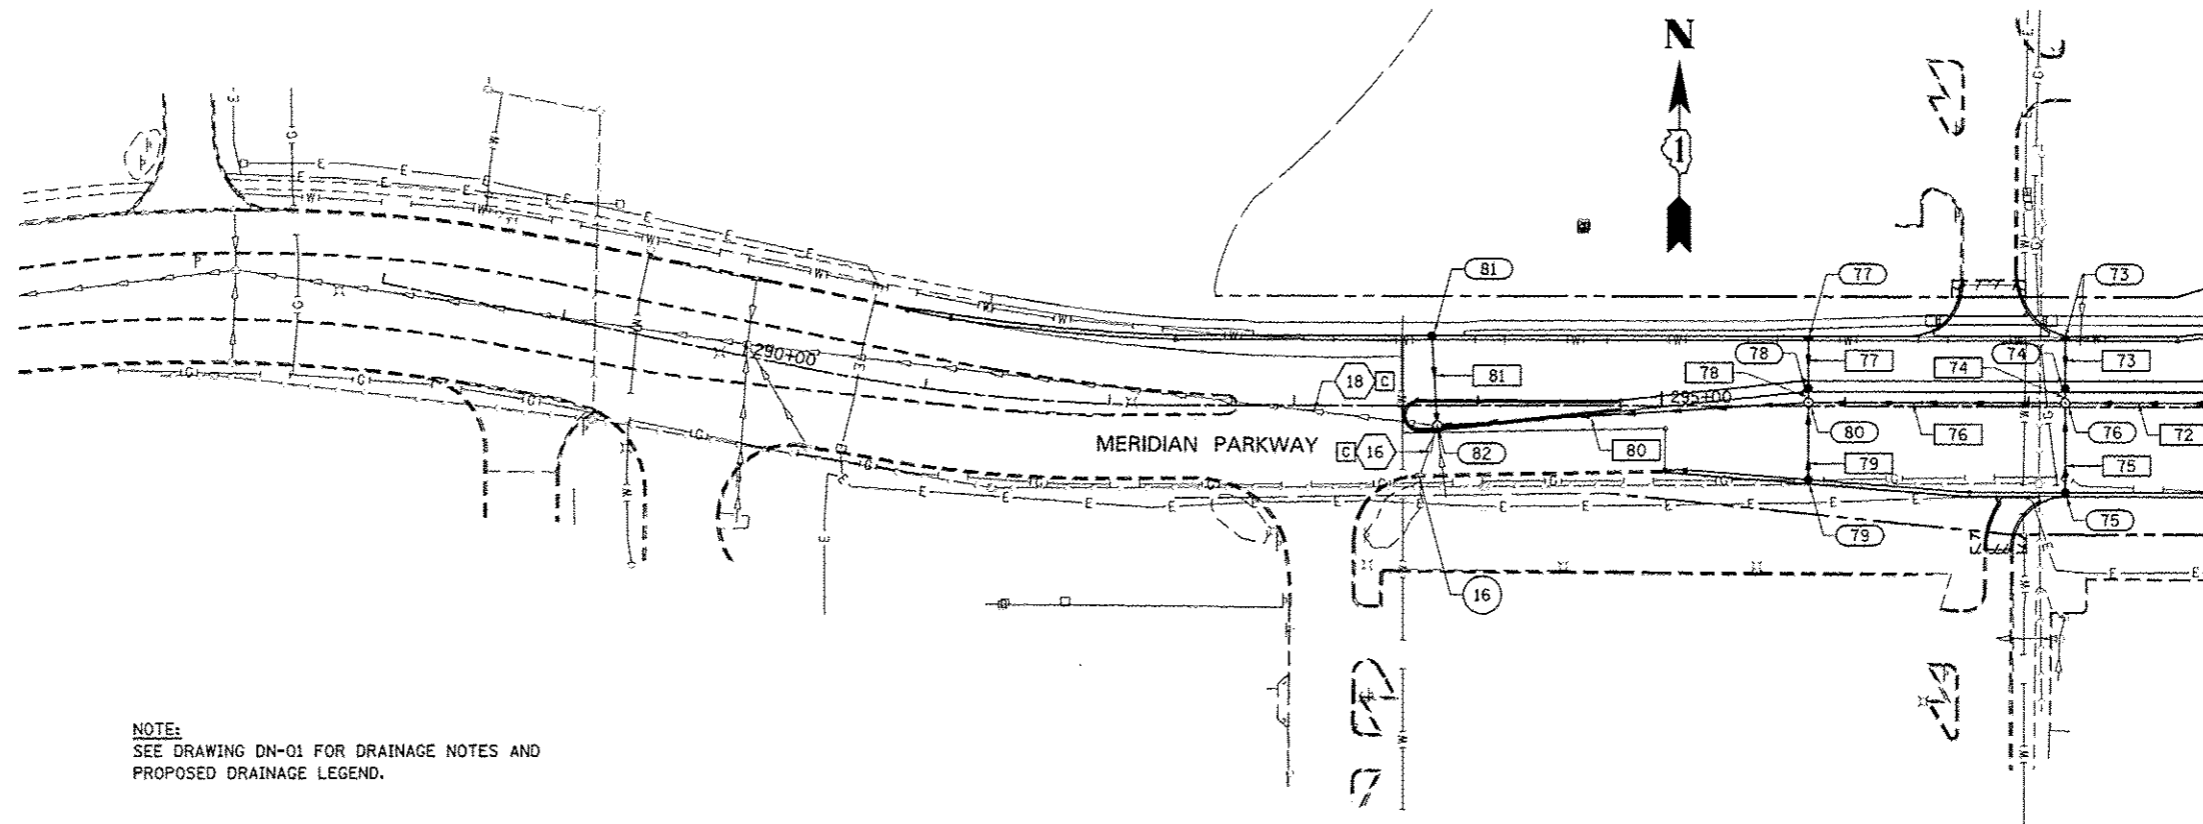

NOTE:
SEE DRAWING DN-01 FOR DRAINAGE NOTES AND
PROPOSED DRAINAGE LEGEND.



MATCH LINE STA. 298+00
SEE DRAWING DP-12

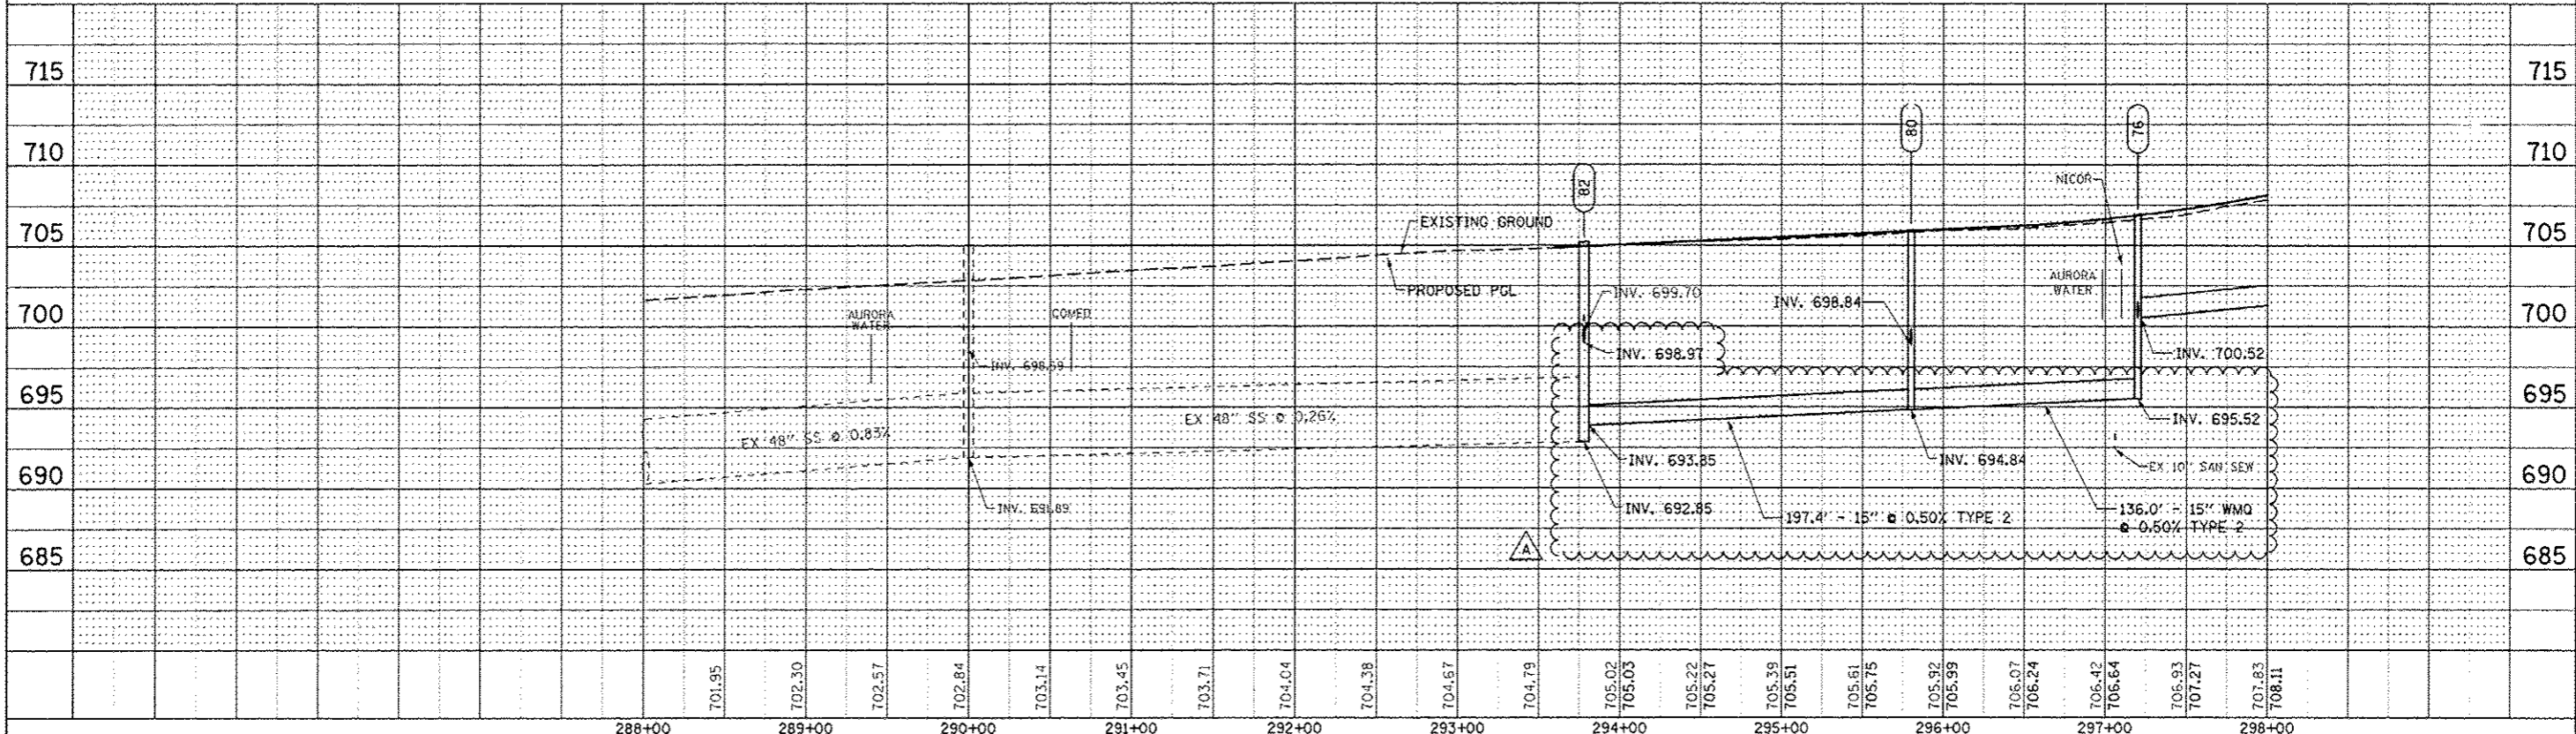

DESIGNED	JWM	REVISED - ADDENDUM A 02/20/2013
DRAWN	KES	REVISED -
CHECKED	JRS	REVISED -
DATE	12/14/2012	REVISED -

STATE OF ILLINOIS
DEPARTMENT OF TRANSPORTATION

PROPOSED DRAINAGE PLAN & PROFILE - MERIDIAN PARKWAY

SCALE: 1"=50' SHEET NO. 18 OF 25 SHEETS STA. BEGIN TO STA. 298+00

F.A.P. RTE.	SECTION	COUNTY	TOTAL SHEETS
338	(112 & 113) WRS-7	DUPAGE	1156
DP-11		CONTRACT NO.	60R30
ILLINOIS FED. AID PROJECT			