
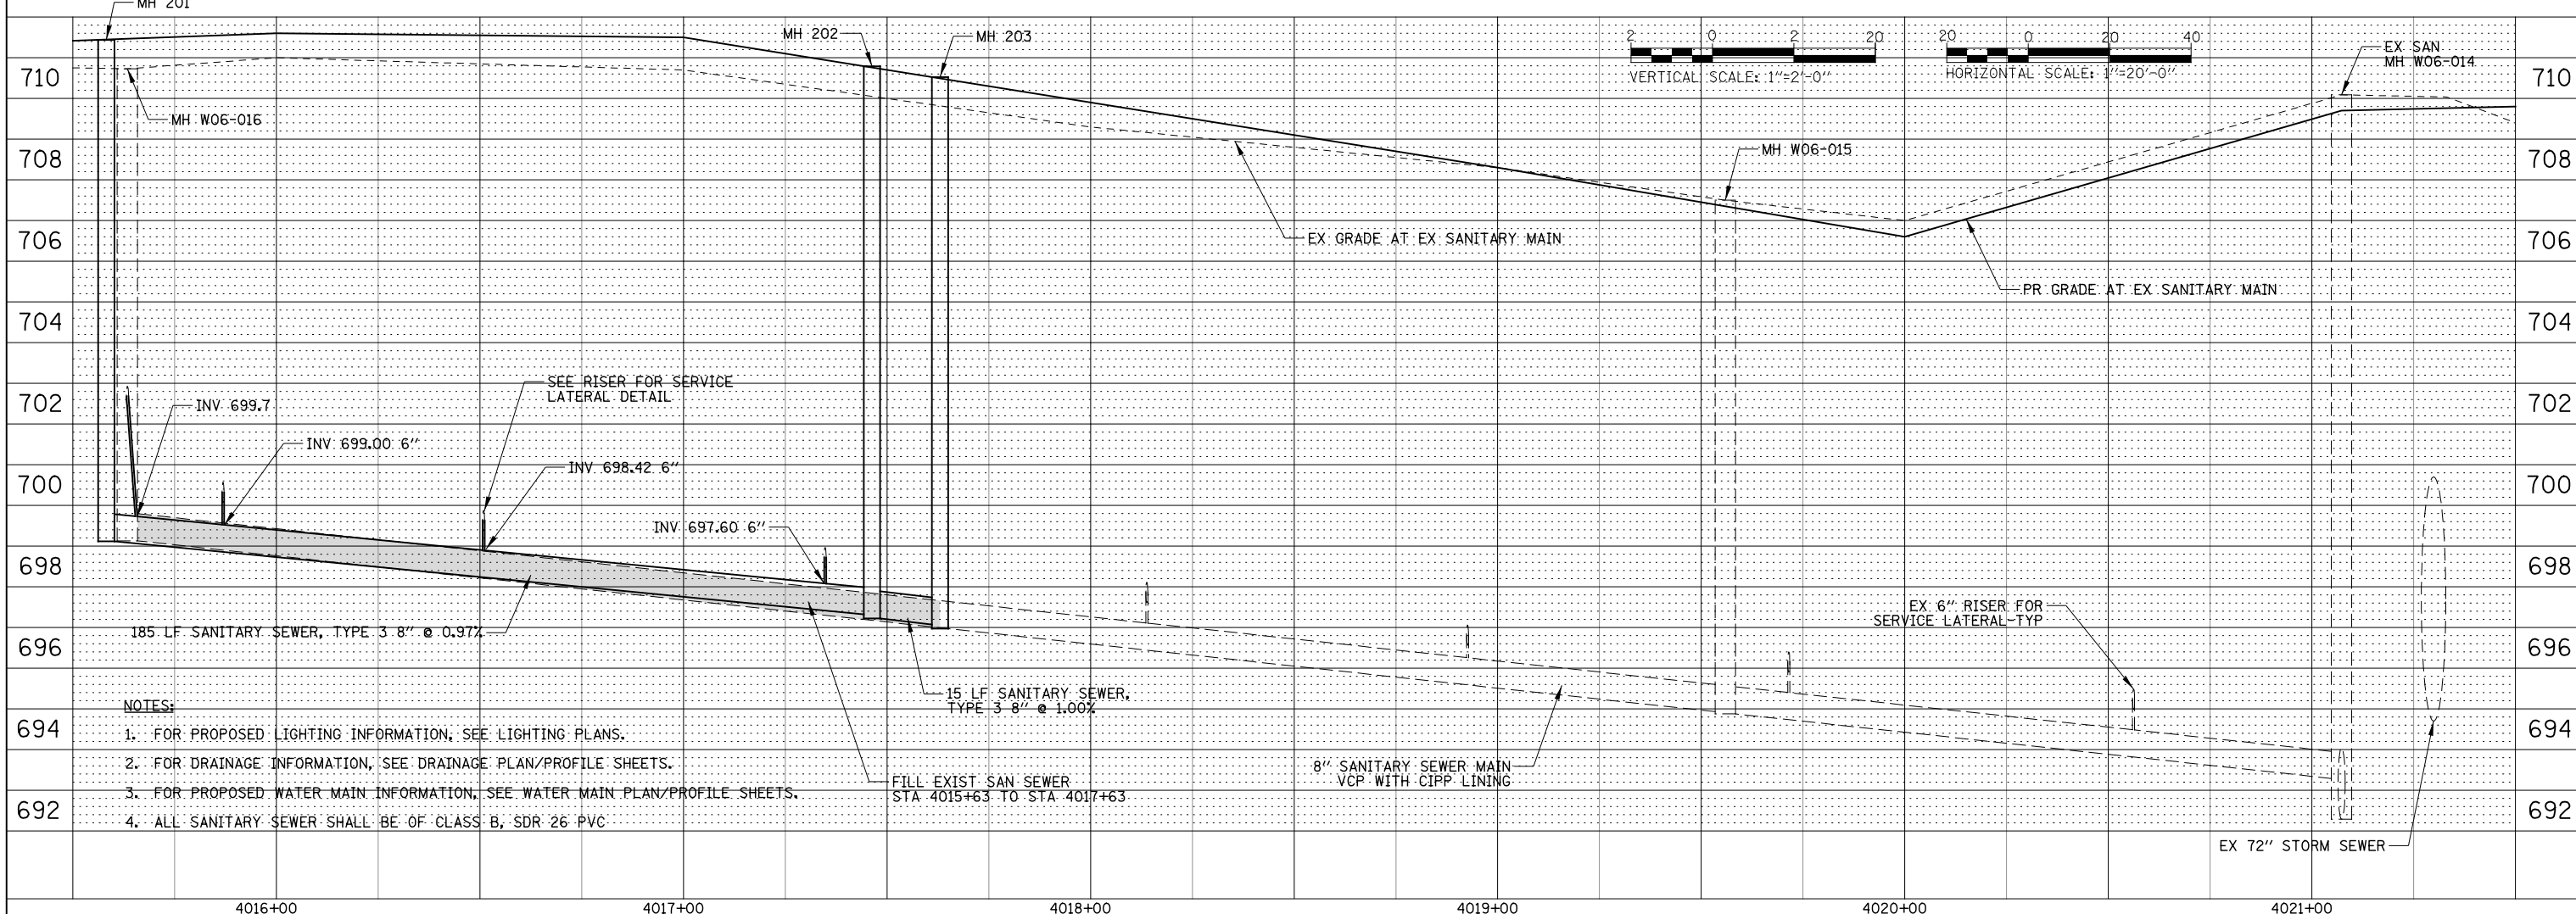


PLAN	SURVEYED	DATE
	PLOTTED	
	CHECKED	
	BY	
	NO. _____	

PROFILE	SURVEYED	DATE
	PLOTTED	
	CHECKED	
	BY	
	NO. _____	

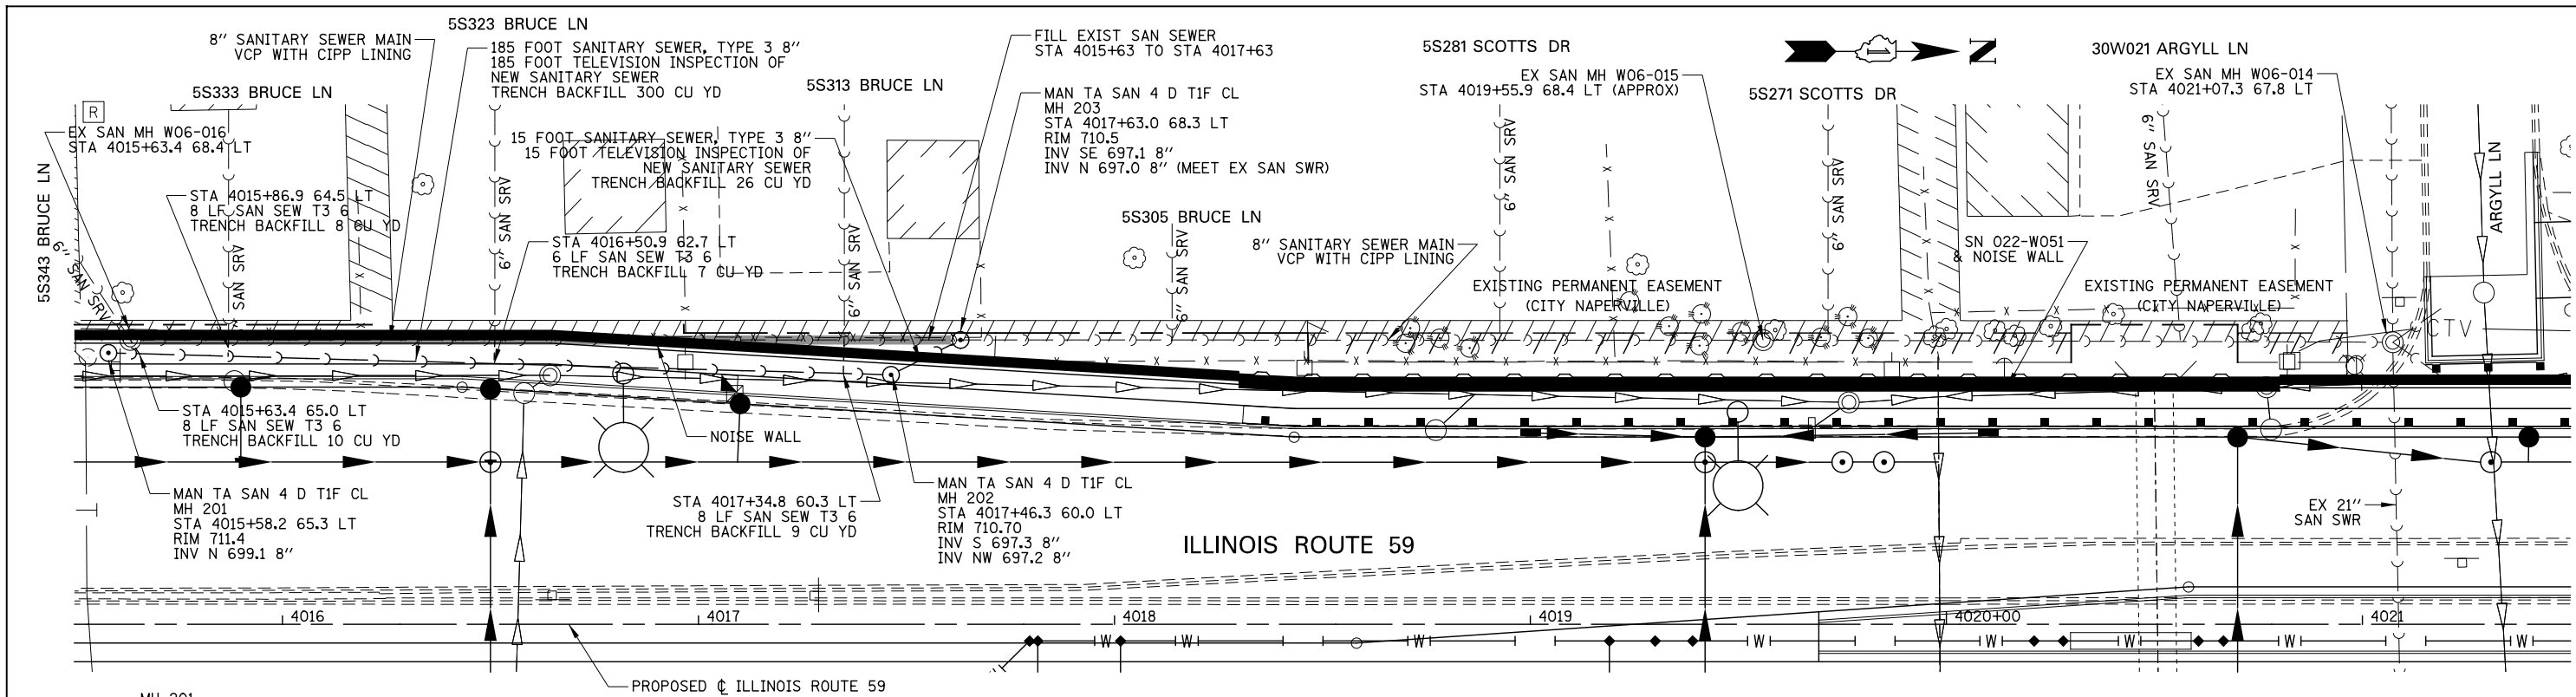

- NOTES:**
1. FOR PROPOSED LIGHTING INFORMATION, SEE LIGHTING PLANS.
 2. FOR DRAINAGE INFORMATION, SEE DRAINAGE PLAN/PROFILE SHEETS.
 3. FOR PROPOSED WATER MAIN INFORMATION, SEE WATER MAIN PLAN/PROFILE SHEETS.
 4. ALL SANITARY SEWER SHALL BE OF CLASS B, SDR 26 PVC.

DESIGNED	PJO	REVISED	-
DRAWN	KES	REVISED	-
CHECKED	JCM	REVISED	-
DATE	12/14/2012	REVISED	-

**STATE OF ILLINOIS
DEPARTMENT OF TRANSPORTATION**

SANITARY SEWER PLAN AND PROFILE

SCALE: SHEET NO. 1 OF 2 SHEETS STA. 4015+00 TO STA. 4021+50

F.A.P. RTE.	SECTION	COUNTY	TOTAL SHEETS	SHEET NO.
338	(112 & 113) WRS-6	DUPAGE	734	330
SAN PP-1			CONTRACT NO. 60R31	
FED. ROAD DIST. NO.	ILLINOIS FED. AID PROJECT			