



DATE	BY	DATE	BY
SURVEYED		SURVEYED	
PLOT FILED		PLOT FILED	
NOTE BOOK		NOTE BOOK	
NO.		NO.	
DATE		DATE	
STRUCTURE		STRUCTURE	
NOTATION		NOTATION	
DPI		DPI	

CHRISTOPHER B. BURKE
ENGINEERING LTD.
9575 West Higgins Road, Suite 600
Rosemont, Illinois 60018
(847) 823-0500


\\na\dept\080248\Task_FFB\11_19_Safety_Traffic\LIT_de1010-be792.dgn

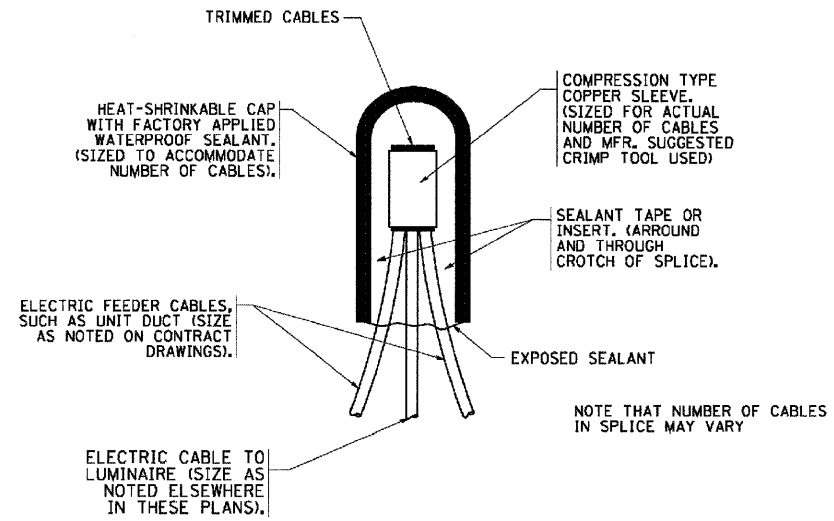

TYPICAL SPLICE DETAIL
N.T.S.

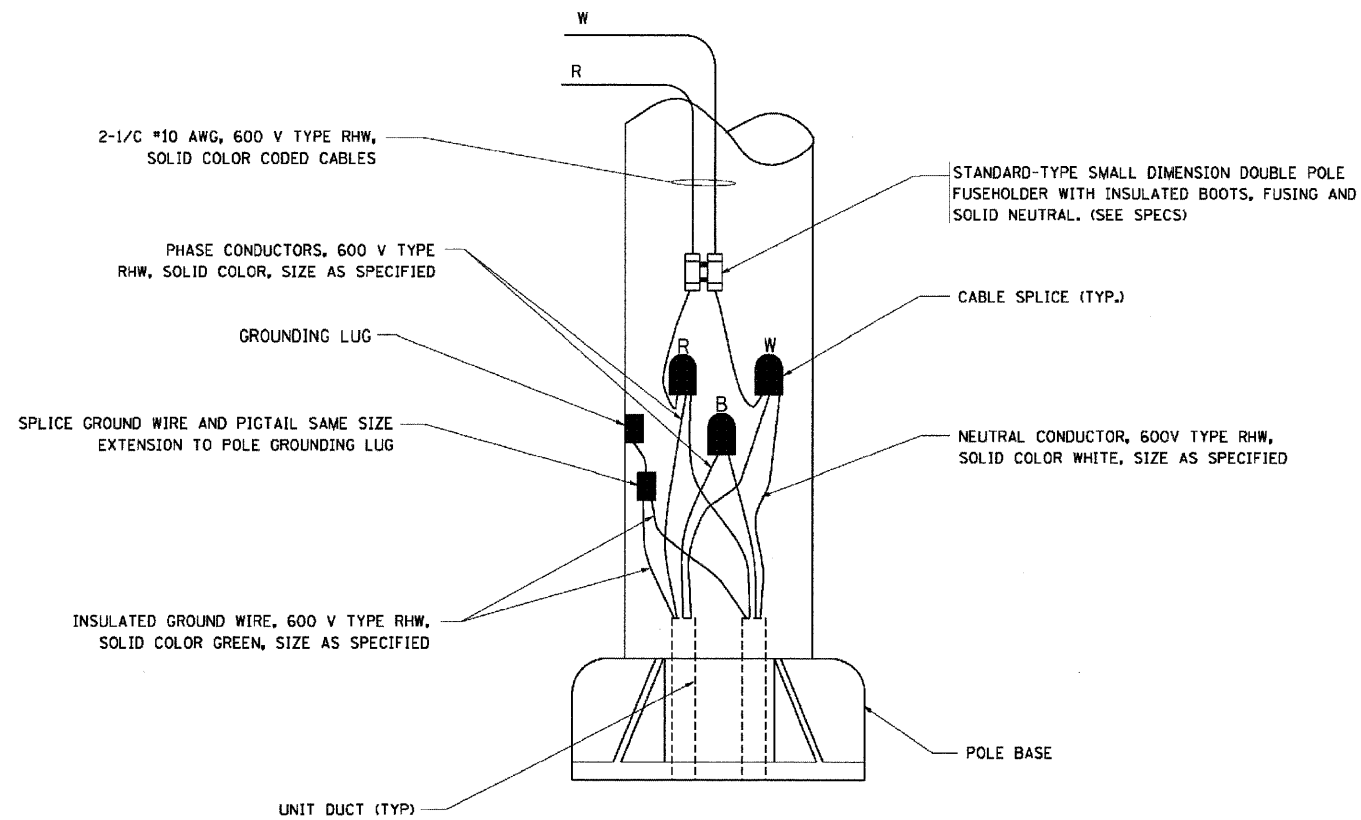

POLE WIRING DETAIL
N.T.S.

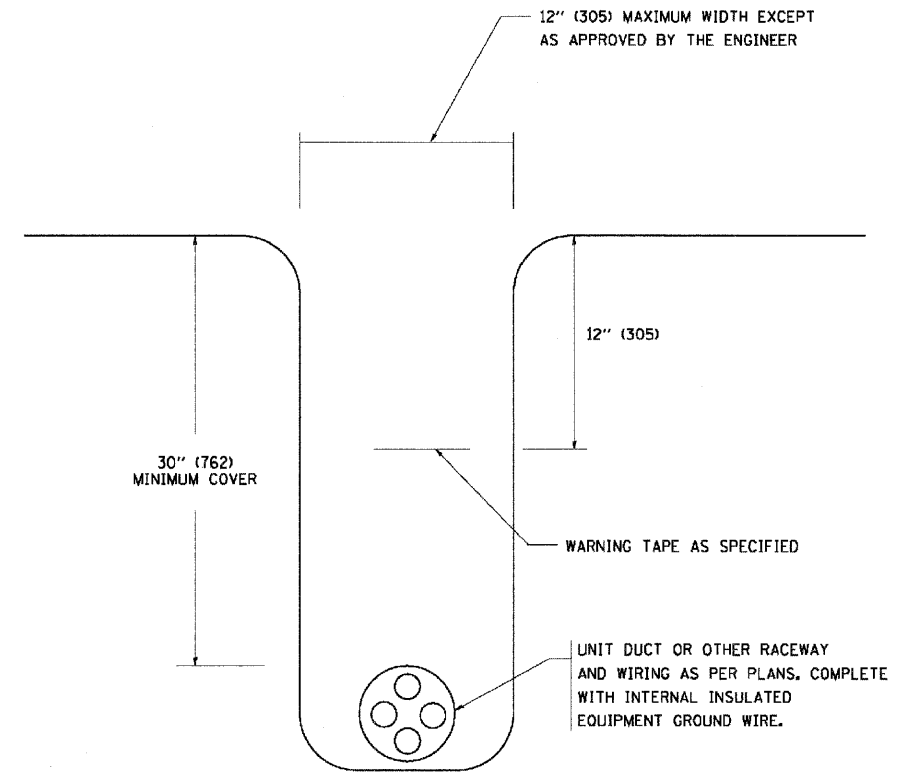

TYPICAL WIRING IN TRENCH DETAIL
N.T.S.

FILE NAME =
...TrafFic\LIT_de1010-be792.dgn

USER NAME = FPAIONE
PLOT SCALE = 20'
PLOT DATE = 3/18/2009

DESIGNED - ABR
DRAWN - FPB / FCP
CHECKED - MJT
DATE -

REVISED -
REVISED -
REVISED -
REVISED -

**STATE OF ILLINOIS
DEPARTMENT OF TRANSPORTATION**

**MISC. ELECTRICAL DETAILS
SHEET A**

SCALE: N.T.S. SHEET NO. OF SHEETS STA. TO STA.

F.A.U. RTE.	SECTION	COUNTY	TOTAL SHEETS	SHEET NO.
1321	2009-034 TS	COOK	45	45
FED. ROAD DIST. NO.			ILLINOIS FED. AID PROJECT	
			CONTRACT NO. 60G39	