


F.A.I. RTE.	SECTION	COUNTY	TOTAL SHEETS	SHEET NO.
90/94		COOK	31	21
STA. 108+00		TO STA. 111+25.00		
FED. ROAD DIST. NO. 1		ILLINOIS FED. AID PROJECT		
(1919.15 & 2021-922 PT) 1				62985

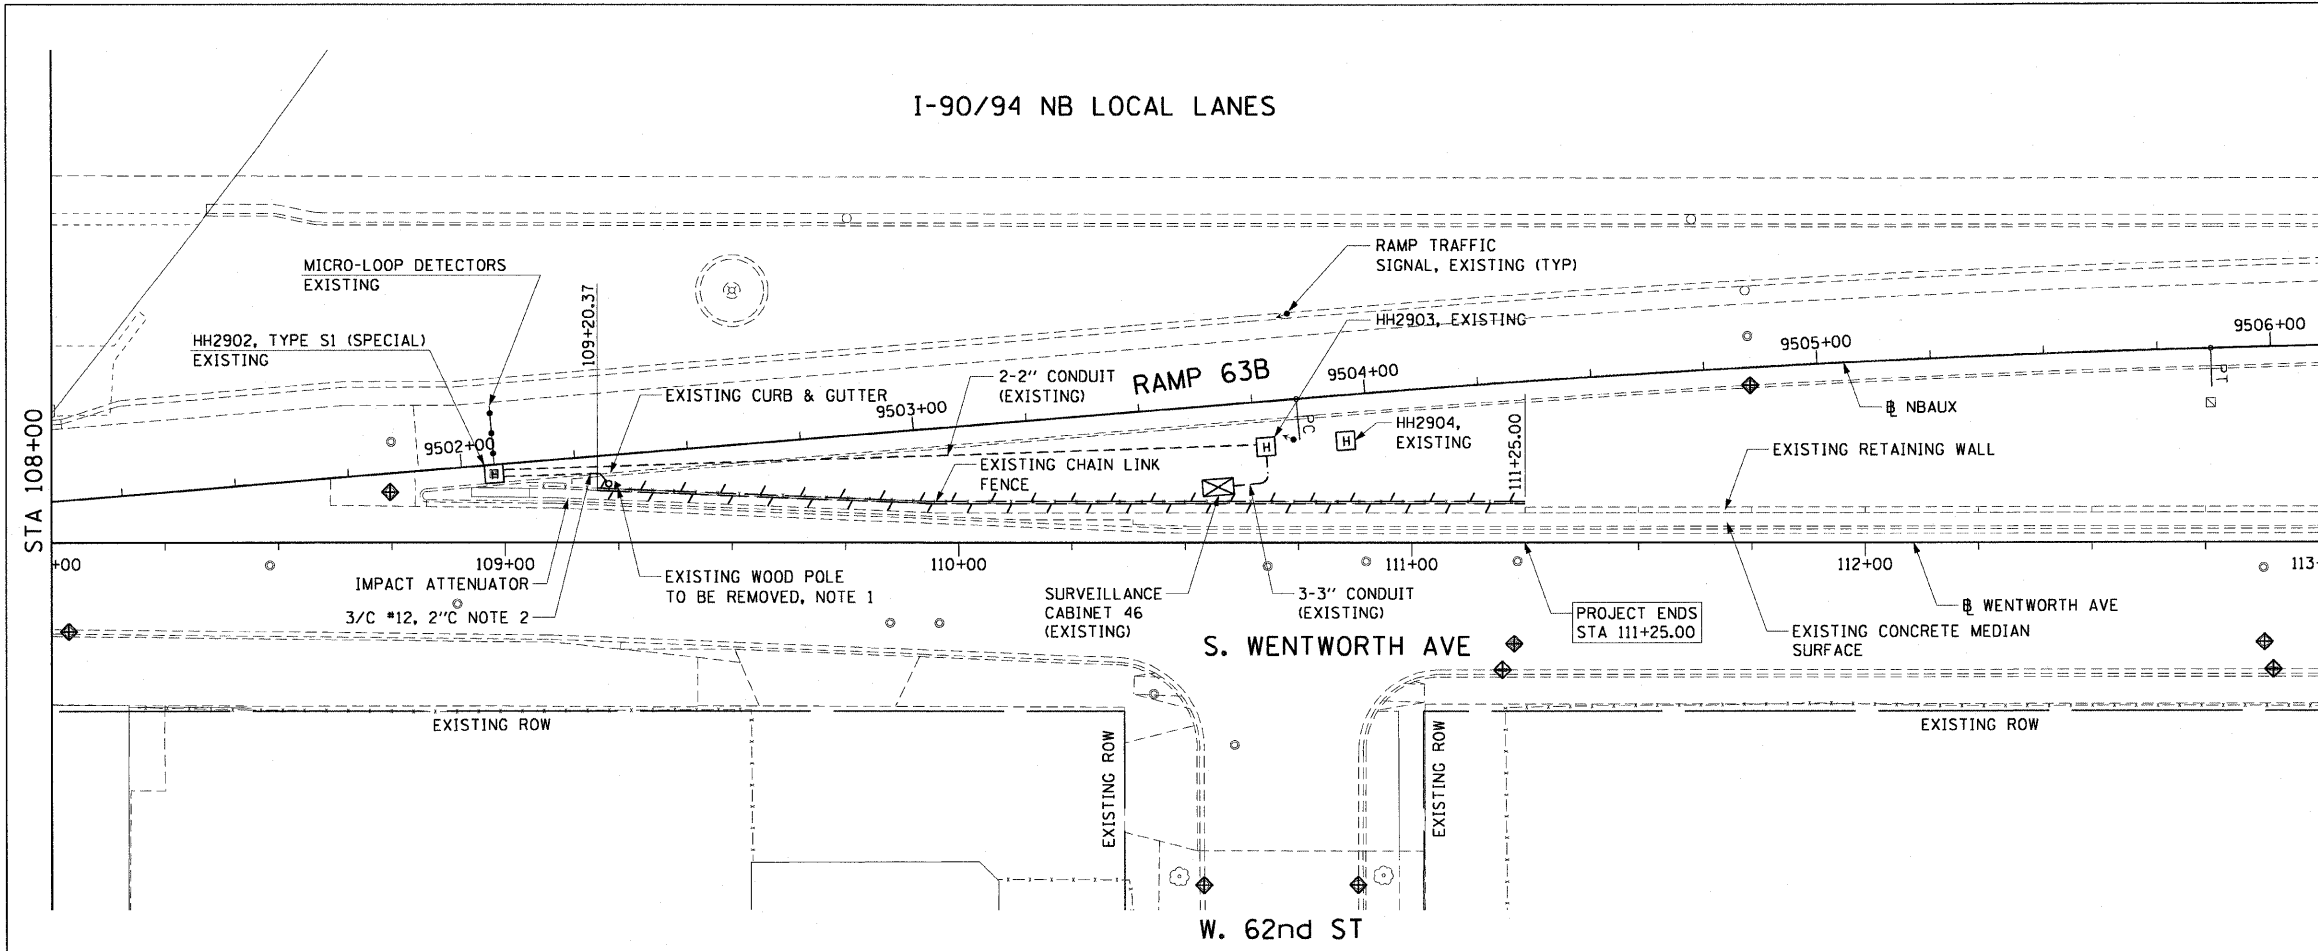


NOTES:

- EXISTING WOOD POST TO BE REMOVED. EXISTING FLASHING BEACONS AND WARNING SIGN TO BE REMOVED FROM WOOD POST AND BE INSTALLED ON NEW STEEL POLE.
- EXISTING 3/C #12 TO BE PULLED BACK TO EXISTING SURVEILLANCE CABINET 46 AND REMOVED.

EXISTING CONDITIONS AND REMOVAL


PROPOSED IMPROVEMENTS

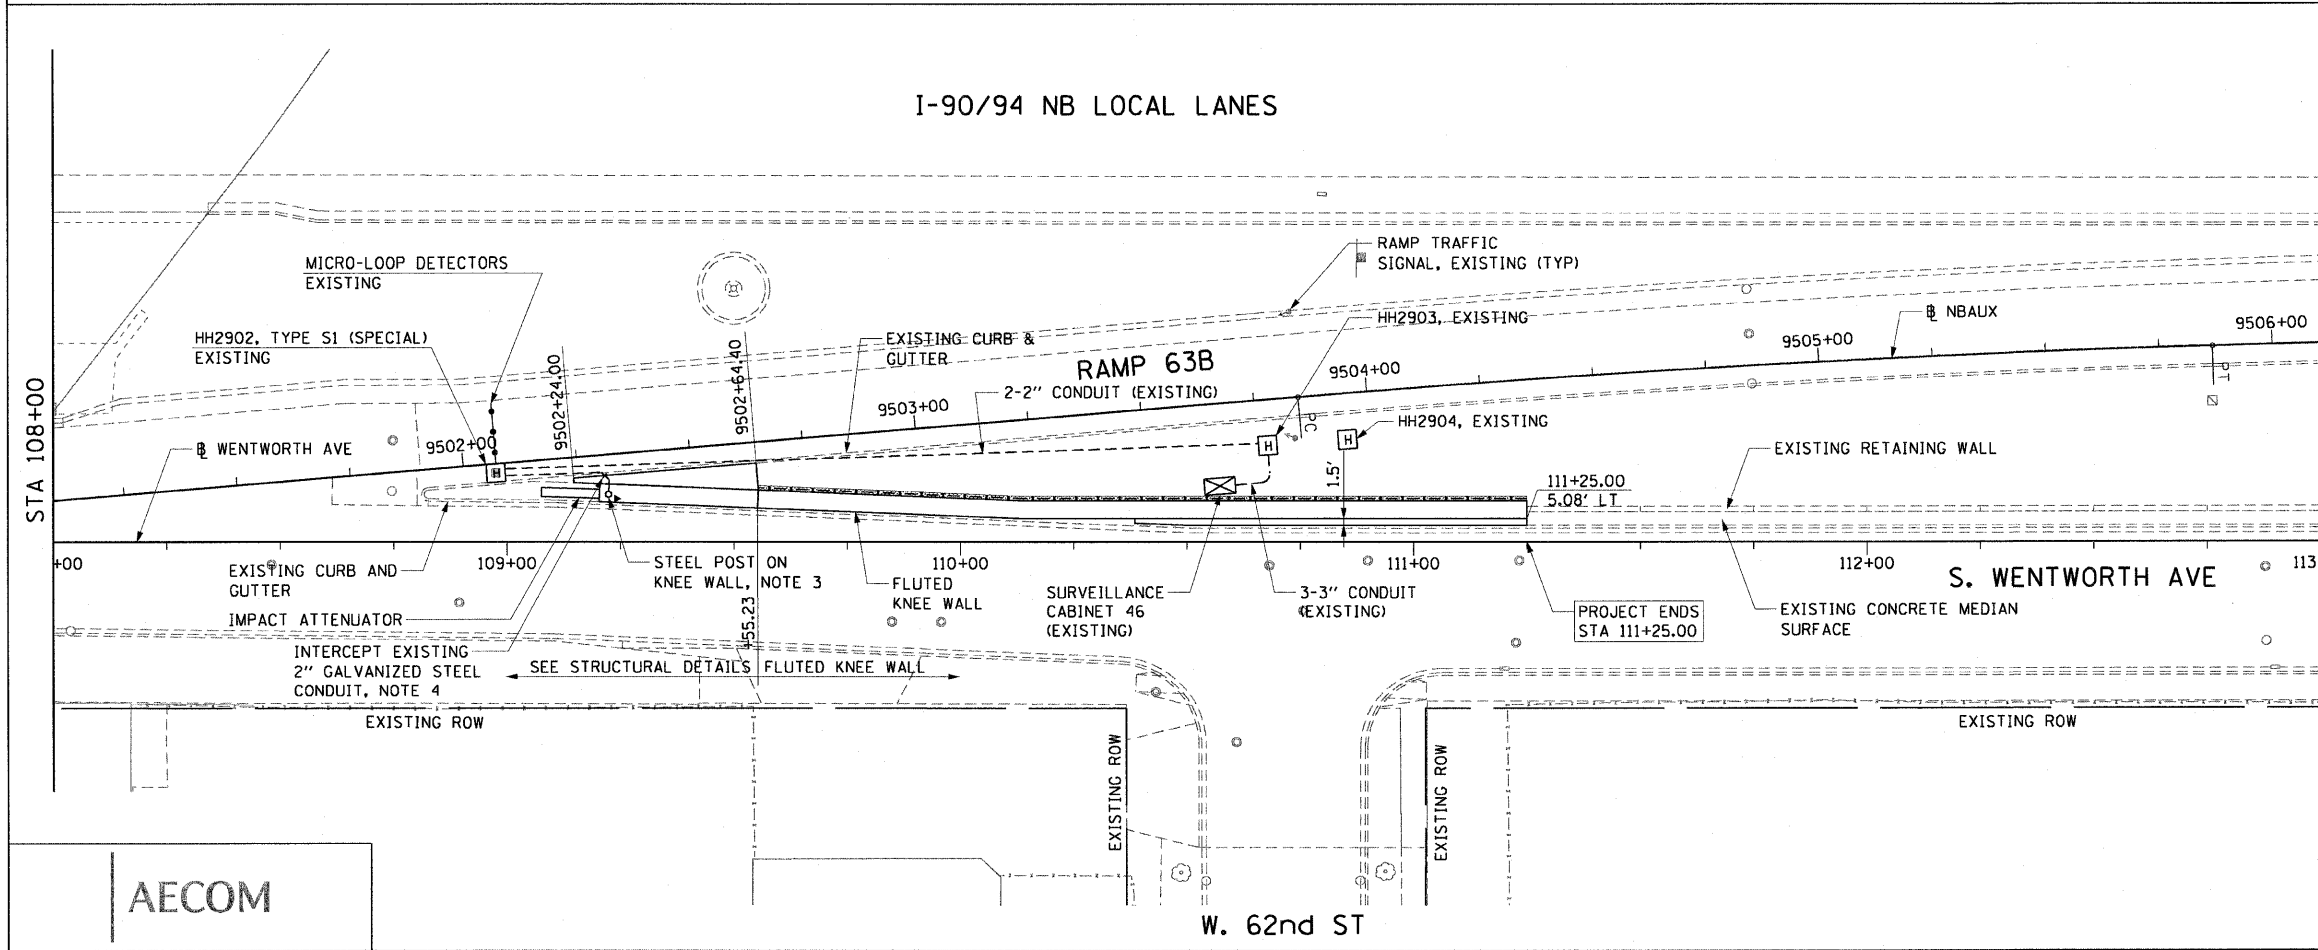

NOTES:

- NEW STEEL POLE TO BE INSTALLED AT END OF NEW KNEE WALL. EXISTING FLASHING BEACONS AND WARNING SIGN REMOVED FROM WOOD POST ARE TO BE INSTALLED ON NEW STEEL POLE. SEE DRAWING DT-35A FOR DETAILS.
- EXISTING 2" GSC TO BE REROUTED TO NEW STEEL POLE BASE ON TOP OF NEW KNEE WALL. NEW 2" GSC CONDUIT TO BE INSTALLED AS NEEDED TO FACILITATE CONNECTION BETWEEN NEW POLE AND HANDHOLE HH2902. NEW 3/C #12 CABLE TO BE INSTALLED AND CONNECTED BETWEEN BEACONS AND EXISTING CABINET 46. SEE STRUCTURAL DETAILS AND DRAWING DT-35A FOR CONDUIT DETAILS.

 FOR INFORMATION ONLY
ALL ELECTRICAL WORK SHOWN ON THIS SHEET WILL BE DONE BY MEADE ELECTRIC UNDER CONTRACT 62583.



REVISIONS	
NAME	DATE

ILLINOIS DEPARTMENT OF TRANSPORTATION
F.A.I. 90/94 (DAN RYAN EXPRESSWAY)
63RD ST TO 59TH ST (NB AND SB KNEE WALLS)

ELECTRICAL PLAN

SCALE: 1"=20'
DATE: JANUARY 14, 2009

DRAWN BY: HR
CHECKED BY: JPC

AECOM

3/10/2009 2:30:02 PM