


F.A.U. ROUTE NO.	SECTION	COUNTY	TOTAL SHEETS	SHEET NO.
4011	07-00072-00-PV	McHENRY	80	23

ILLINOIS PROJECT  
CONTRACT NO. 63137

- NOTES:
1. ALL CURB LINE STRUCTURE LOCATIONS & ELEVATIONS ARE INDICATED AT THE EDGE OF PAVEMENT. ALL OTHER STRUCTURES ARE INDICATED AT THEIR CENTER.
  2. ALL PIPE LENGTHS ARE INDICATED TO INSIDE WALL OF STRUCTURE.

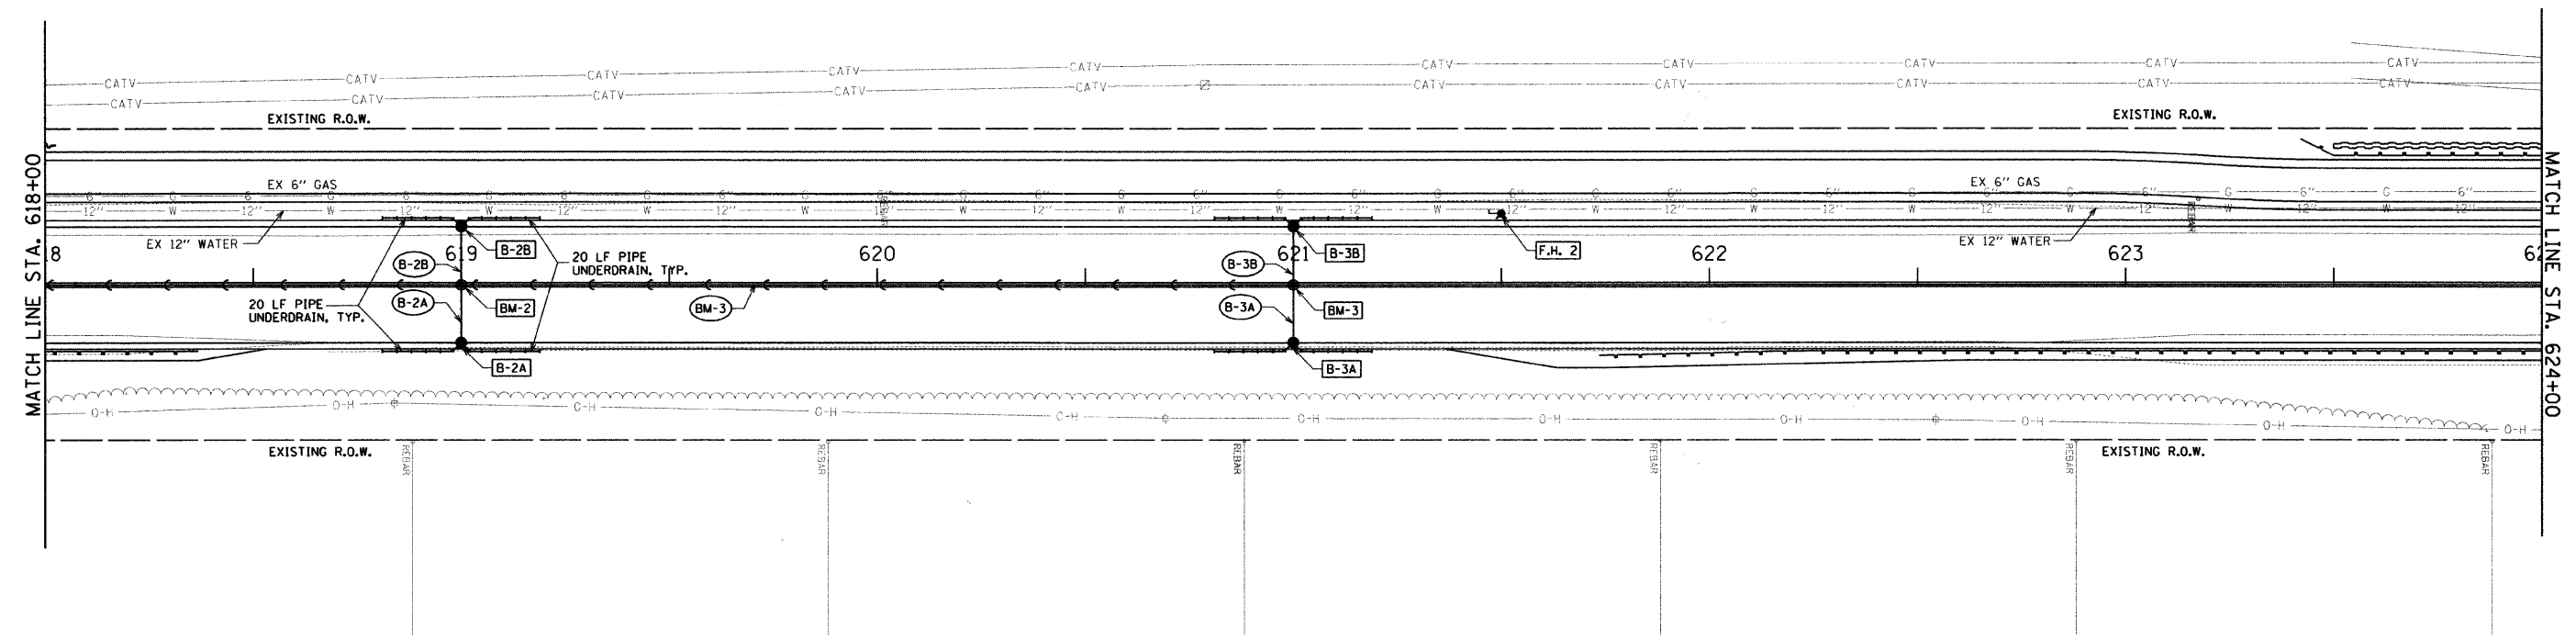


HANSON ROAD  
STORM SEWER PLANS

[F.H. 2]  
FIRE HYDRANT W/ AUX.  
VALVE AND VALVE BOX  
STA. 621+50.0, 17.2' LT

HORIZ. - 1" = 20'  
VERT. - 1" = 10'

SCALE IN FEET  
0 20 40  
0 10 20

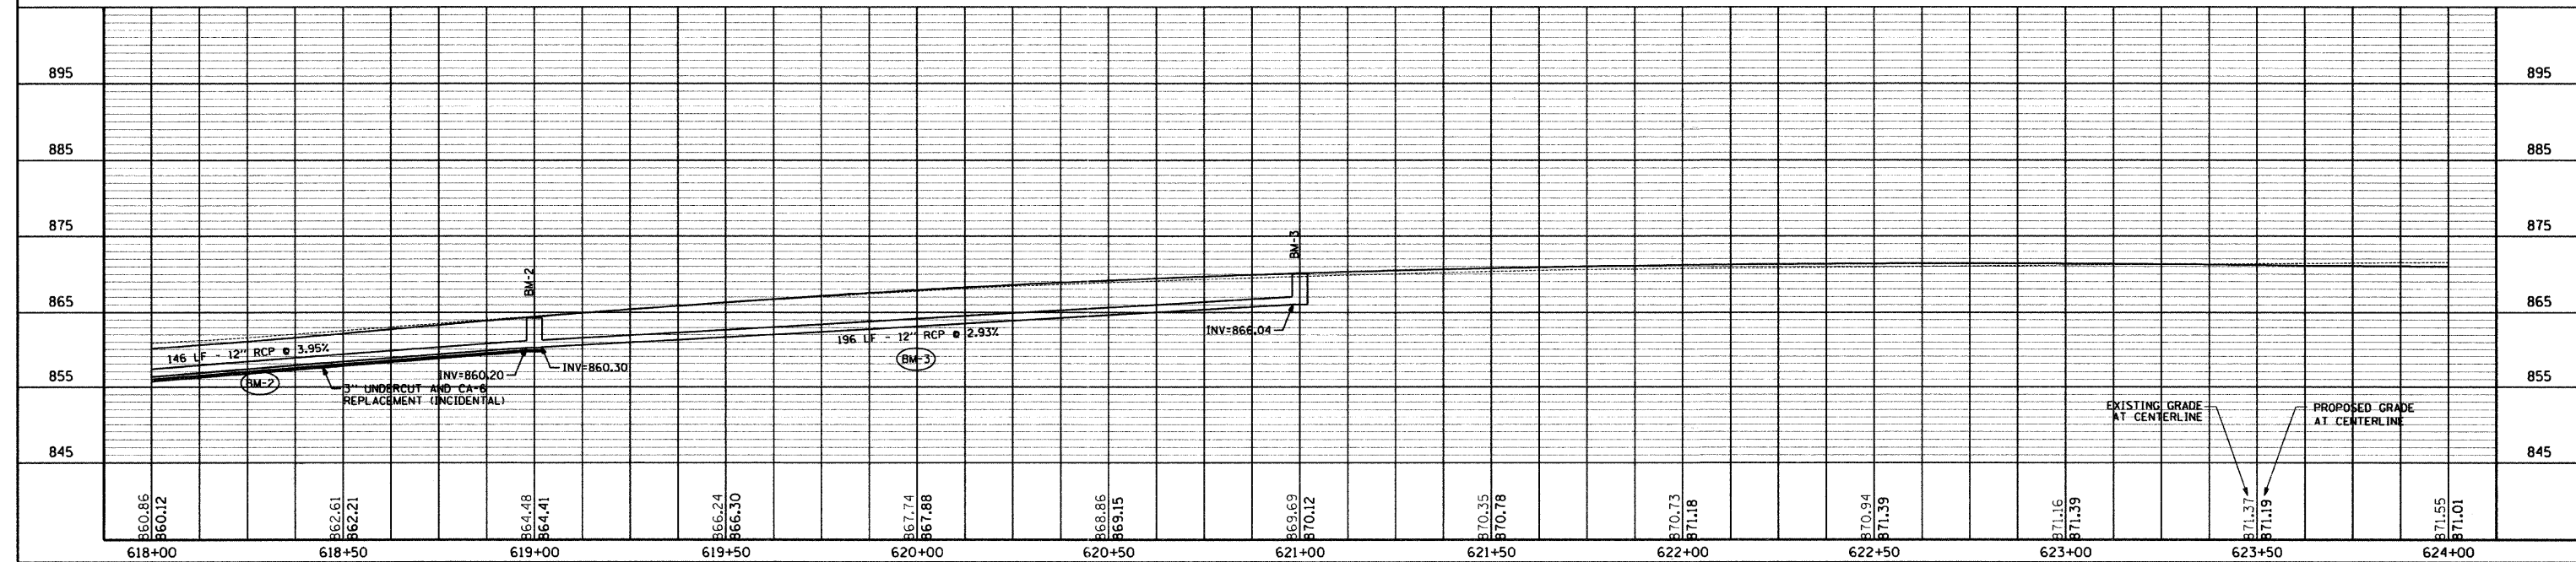

PLAN AND PROFILE

HANSON ROAD STA. 618+00 TO STA. 624+00