

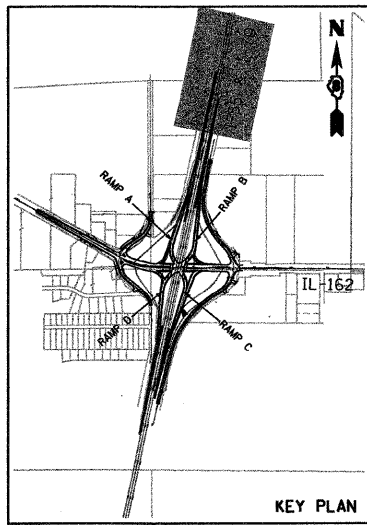


F&P NO.	SECTION	COUNTY	TOTAL SHEETS	SHEET NO.
70	60-10 (K-1,HB)	MADISON	420	183
STA. TO STA.				
CONTRACT NO.: 76709				

NOTES:
 1. ALL UNIT DUCT ON THIS SHEET SHALL BE 4" (2 * 4 XLP, 1 * 4 XLPG, 1.0P) UNLESS NOTED OTHERWISE.

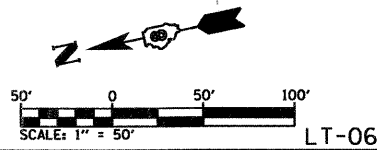

PLAN	DATE
BY	
REVISION	
NO.	

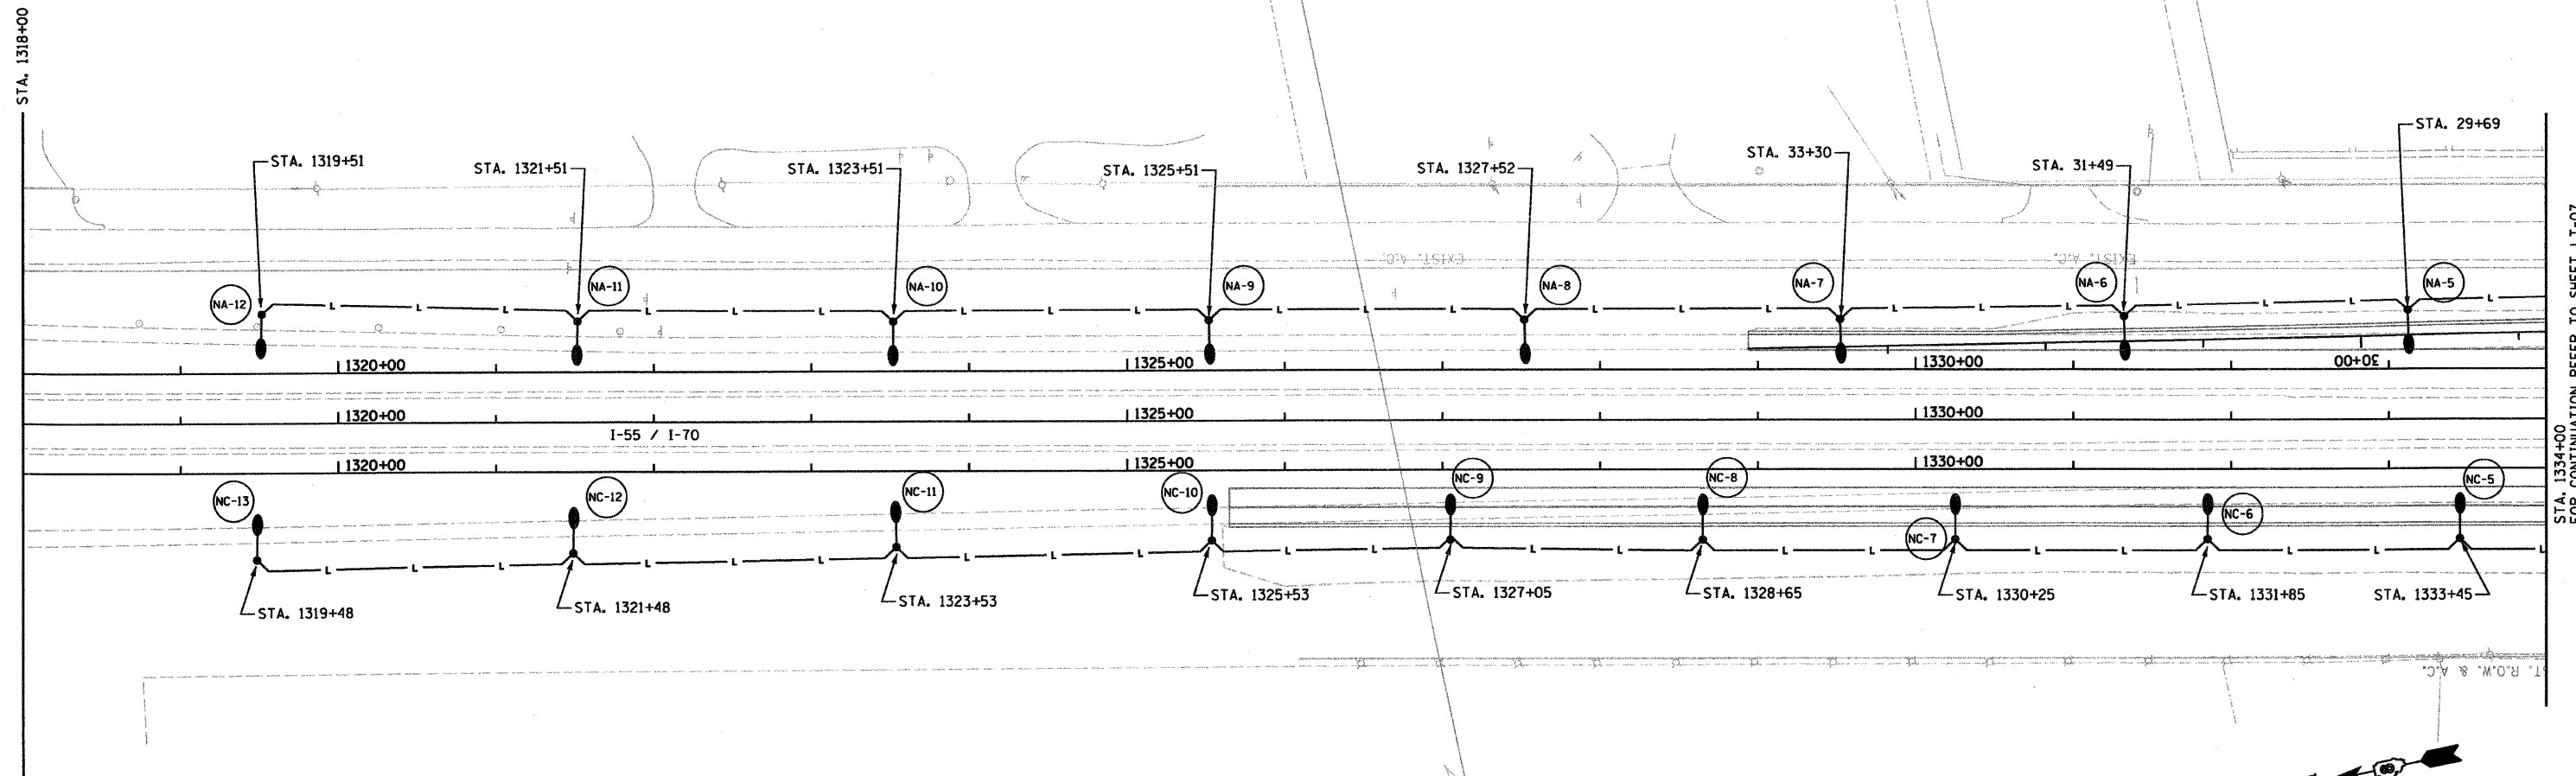

REVISIONS	
NAME	DATE

ILLINOIS DEPARTMENT OF TRANSPORTATION
PROPOSED ROADWAY LIGHTING PLAN
 I-55/70 STA. 1318+00 TO STA. 1334+00
 FAI ROUTE 70
 SECTION 60-10K-1, 60-10HB
 MADISON COUNTY
 DRAWN BY: RPJ CHECKED BY: A. OSHANA, P.E.

XXXXXX - IDOT IL 162 over I-55.70 revisions
 236-LT-06.dgn
 1/28/2009 12:15:11 PM
 Robert Swanson

STA. 1334+00
 FOR CONTINUATION REFER TO SHEET LT-07