
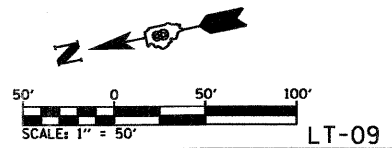
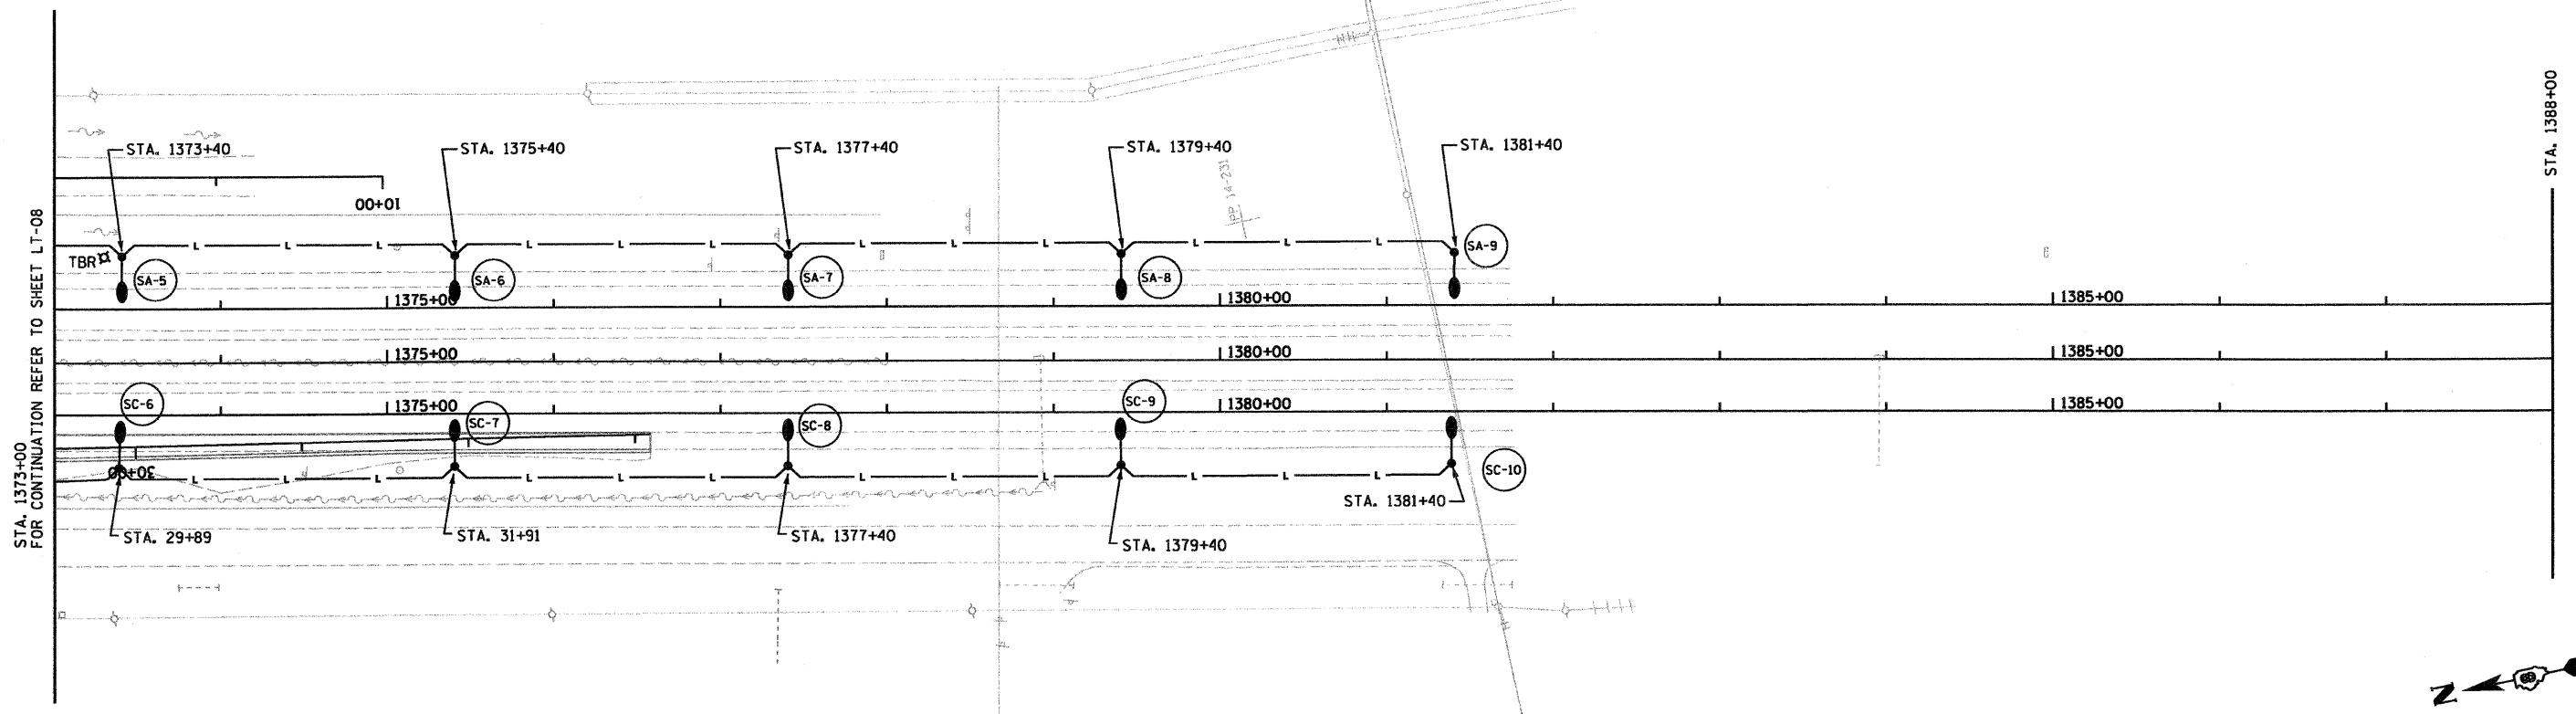


F&P ROUTE	SECTION	COUNTY	TOTAL SHEETS	SHEET NO.
70	60-10 (K-1,HB)	MADISON	420	186
STA.		TO STA.		
CONTRACT NO.: 76709				

NOTES:
 1. ALL UNIT DUCT ON THIS SHEET SHALL BE 4 (2 * 4 XLP, 1 * 4 XLPG, 1.0P) UNLESS NOTED OTHERWISE.

LEGEND
 TBR - TO BE REMOVED
 REMOVE POLE
 REMOVE AND SALVAGE LUMINAIRE
 REMOVE FOUNDATION

PLAN	NO.	NOTE BOOK	DATE
REVISION			
APPROVED			
DESIGNED			
CHECKED			
DRAWN			
BY			

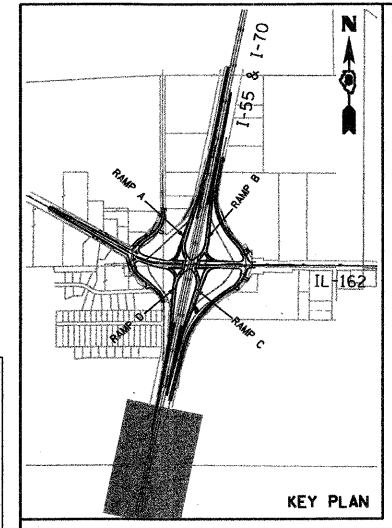

REVISIONS	
NAME	DATE

ILLINOIS DEPARTMENT OF TRANSPORTATION
PROPOSED ROADWAY LIGHTING PLAN
 I-55/70 STA. 1373+00 TO STA. 1388+00
 FAI ROUTE 70
 SECTION 60-10K-1, 60-10HB
 MADISON COUNTY
 DRAWN BY: RPJ CHECKED BY: A. OSHANA, P.E.

XXXXXX - IDOT IL 162 over I-55.70 revisions
 236-LI-09.dgn
 1/28/2009 1:08:44 PM
 Robert Swanson