
 
 
 







PAP	SECTION	COUNTY	TOTAL SHEETS	SHEET NO
70	60-10 (K-1,HB)	MADISON	420	202
STA.		TO STA.		
CONTRACT NO.: 76709				


EXISTING TRAFFIC SIGNALS LEGEND

- CONTROLLER 
- SERVICE INSTALLATION 
- SIGNAL HEAD 
- SIGNAL HEAD WITH BACKPLATE 
- SIGNAL POST 
- MAST ARM ASSEMBLY AND POLE, ALUMINUM 
- HANDHOLE 
- DOUBLE HANDHOLE 

  
- NOTES**
- TEMPORARY TRAFFIC SIGNAL INSTALLATION SHALL REMAIN IN USE DURING CONSTRUCTION UNTIL NEW SIGNALS ARE READY FOR OPERATION.
 - REFER TO LIGHTING PLANS FOR THE REMOVAL OF LIGHT UNITS AND FOUNDATIONS.
 - "TBR" INDICATES EQUIPMENT TO BE REMOVED

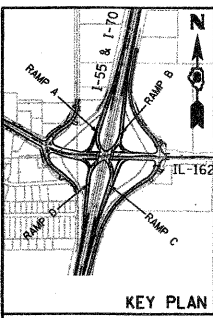

PLAN	DATE	BY
SURVEYED		
NOTE BOOK		
NO. OF SHEETS		
NO. OF THIS SHEET		

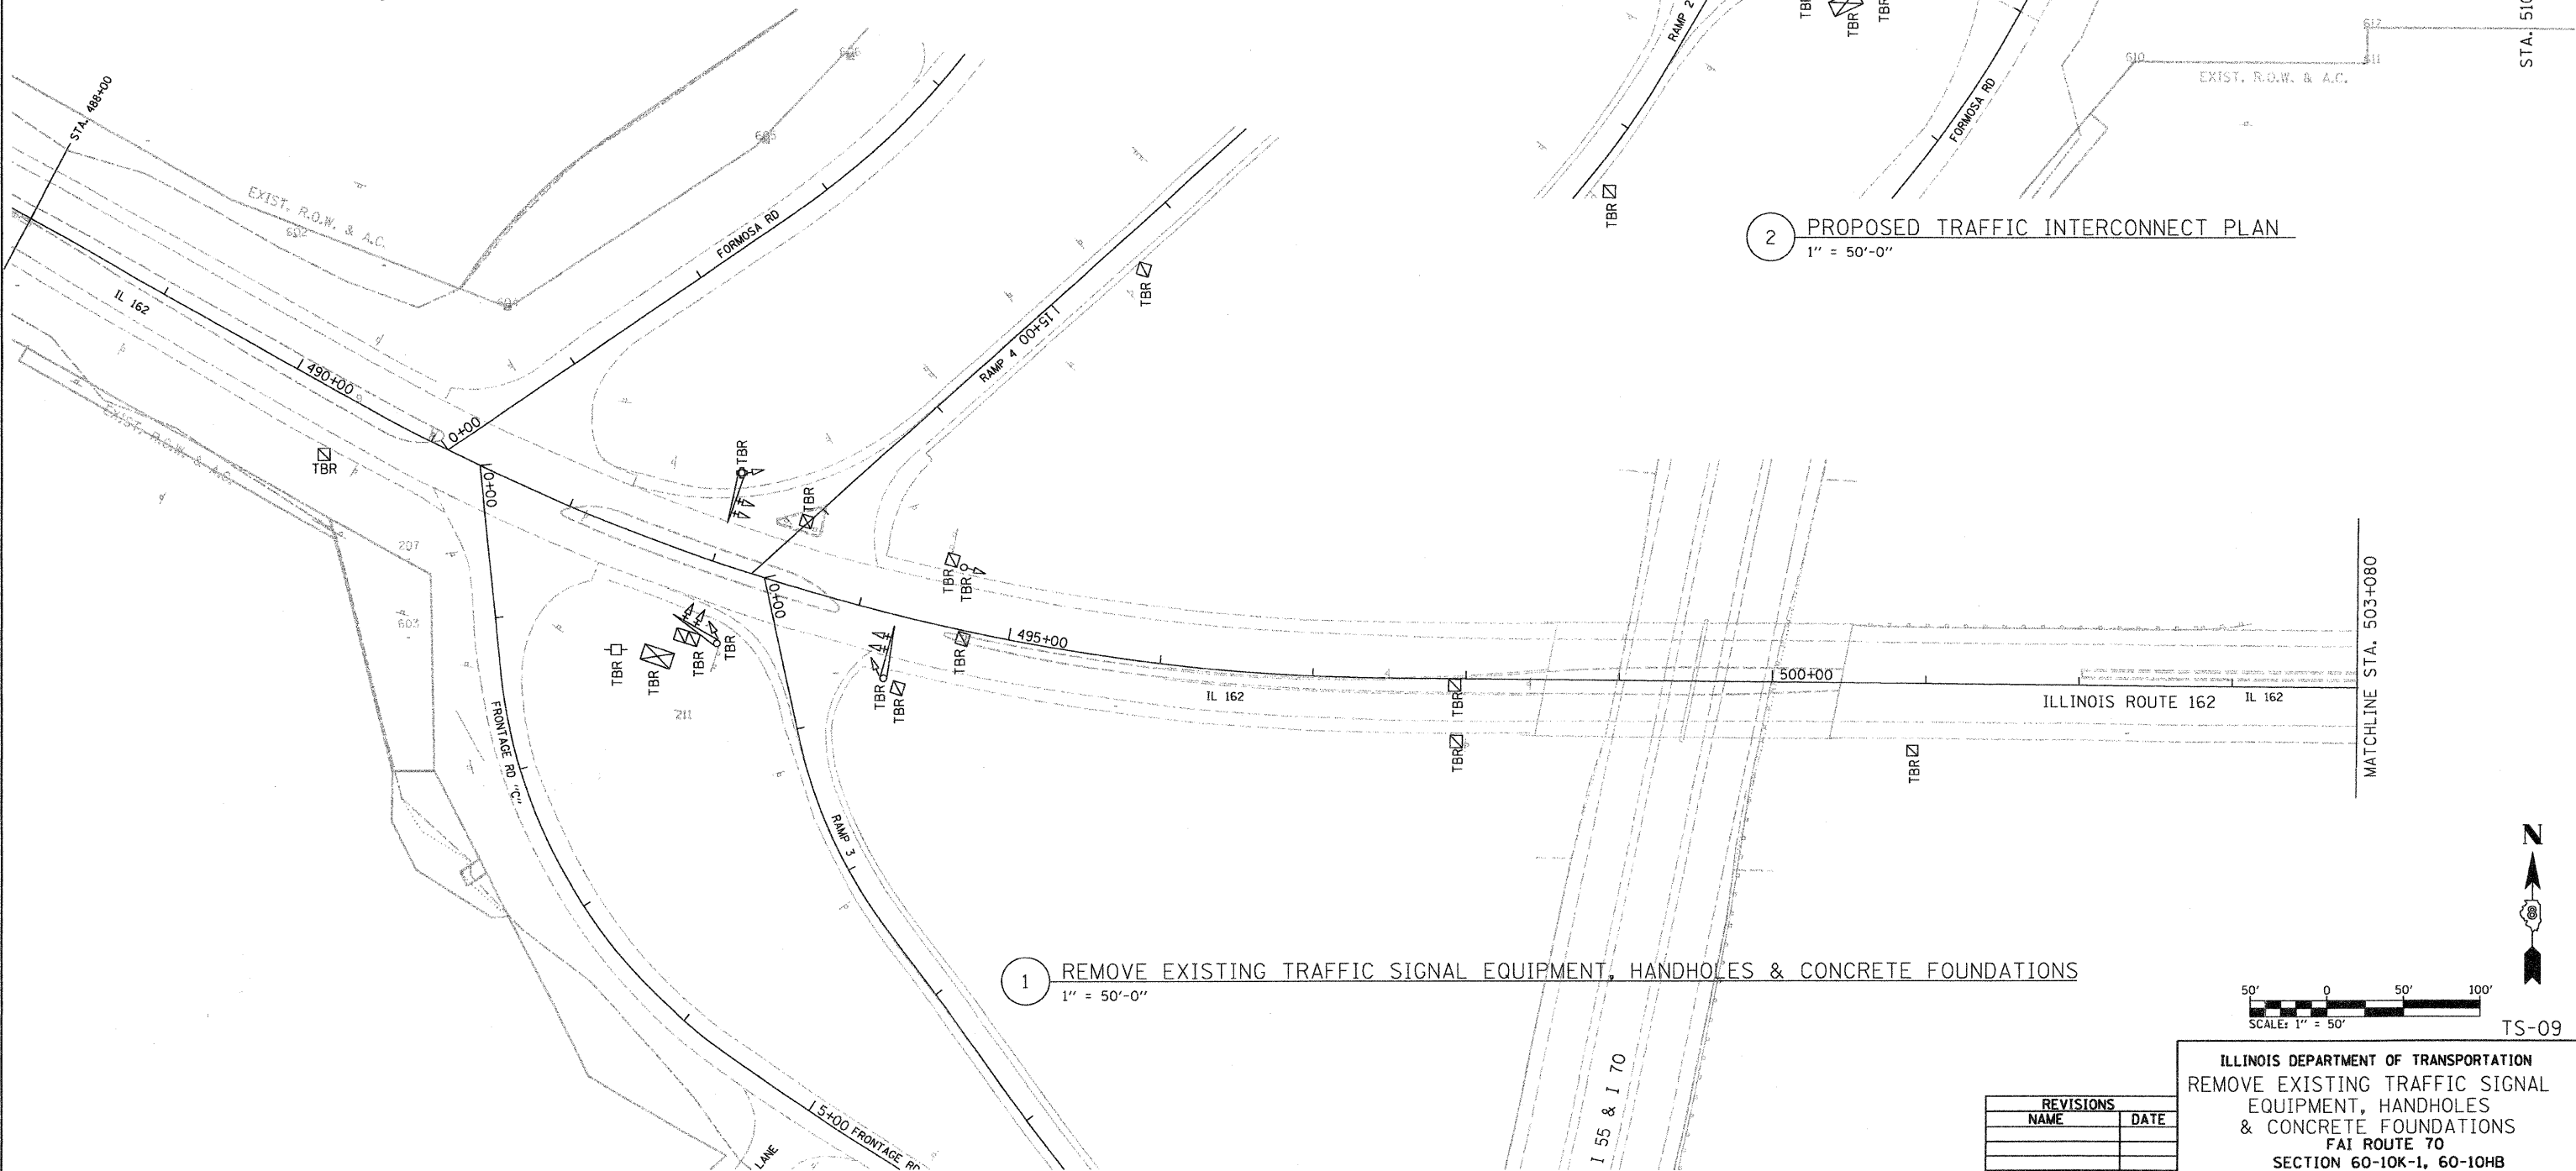

 1 REMOVE EXISTING TRAFFIC SIGNAL EQUIPMENT, HANDHOLES & CONCRETE FOUNDATIONS
1" = 50'-0"



TS-09

REVISIONS	
NAME	DATE

ILLINOIS DEPARTMENT OF TRANSPORTATION
 REMOVE EXISTING TRAFFIC SIGNAL
 EQUIPMENT, HANDHOLES
 & CONCRETE FOUNDATIONS
 FAI ROUTE 70
 SECTION 60-10K-1, 60-10HB
 MADISON COUNTY

DRAWN BY: RPJ CHECKED BY: A. OSHANA, P.E.

XXXX.XXX - IDOT IL 162 over I-55, 70 revisions
 236-TS-09-Removal_Plan.dwg
 1/28/2009
 9:01:23 PM
 Robert Swanson