



McClure
 Engineering Associates, Inc.
 114 East Jackson Street
 Macomb, Illinois 61455
 (609) 833-4599
 FAX: (609) 837-4509
 Design Firm License #184-000616 Copyright 2008 by McClure Engineering Associates, Inc.

PLOTTING SCALE: 1" = 20'
 DRAWN BY: TAB/MS
 CHECKED BY: ECM
 DATE: OCTOBER 2009

REVISIONS

NO.	ITEM	DATE

**WARD STREET IMPROVEMENTS
 PLAN AND PROFILE - STA. 304+00 TO 309+00**
 CITY OF MACOMB
 SOUTH WARD ST.
 FILE NAME: W:\DRAWINGS\MACOMB\WARDS\WARD-ST-2007 FIELD BOOK No. 2257 JOB NUMBER: 02-28-08099

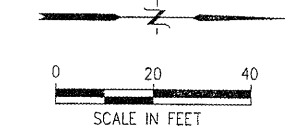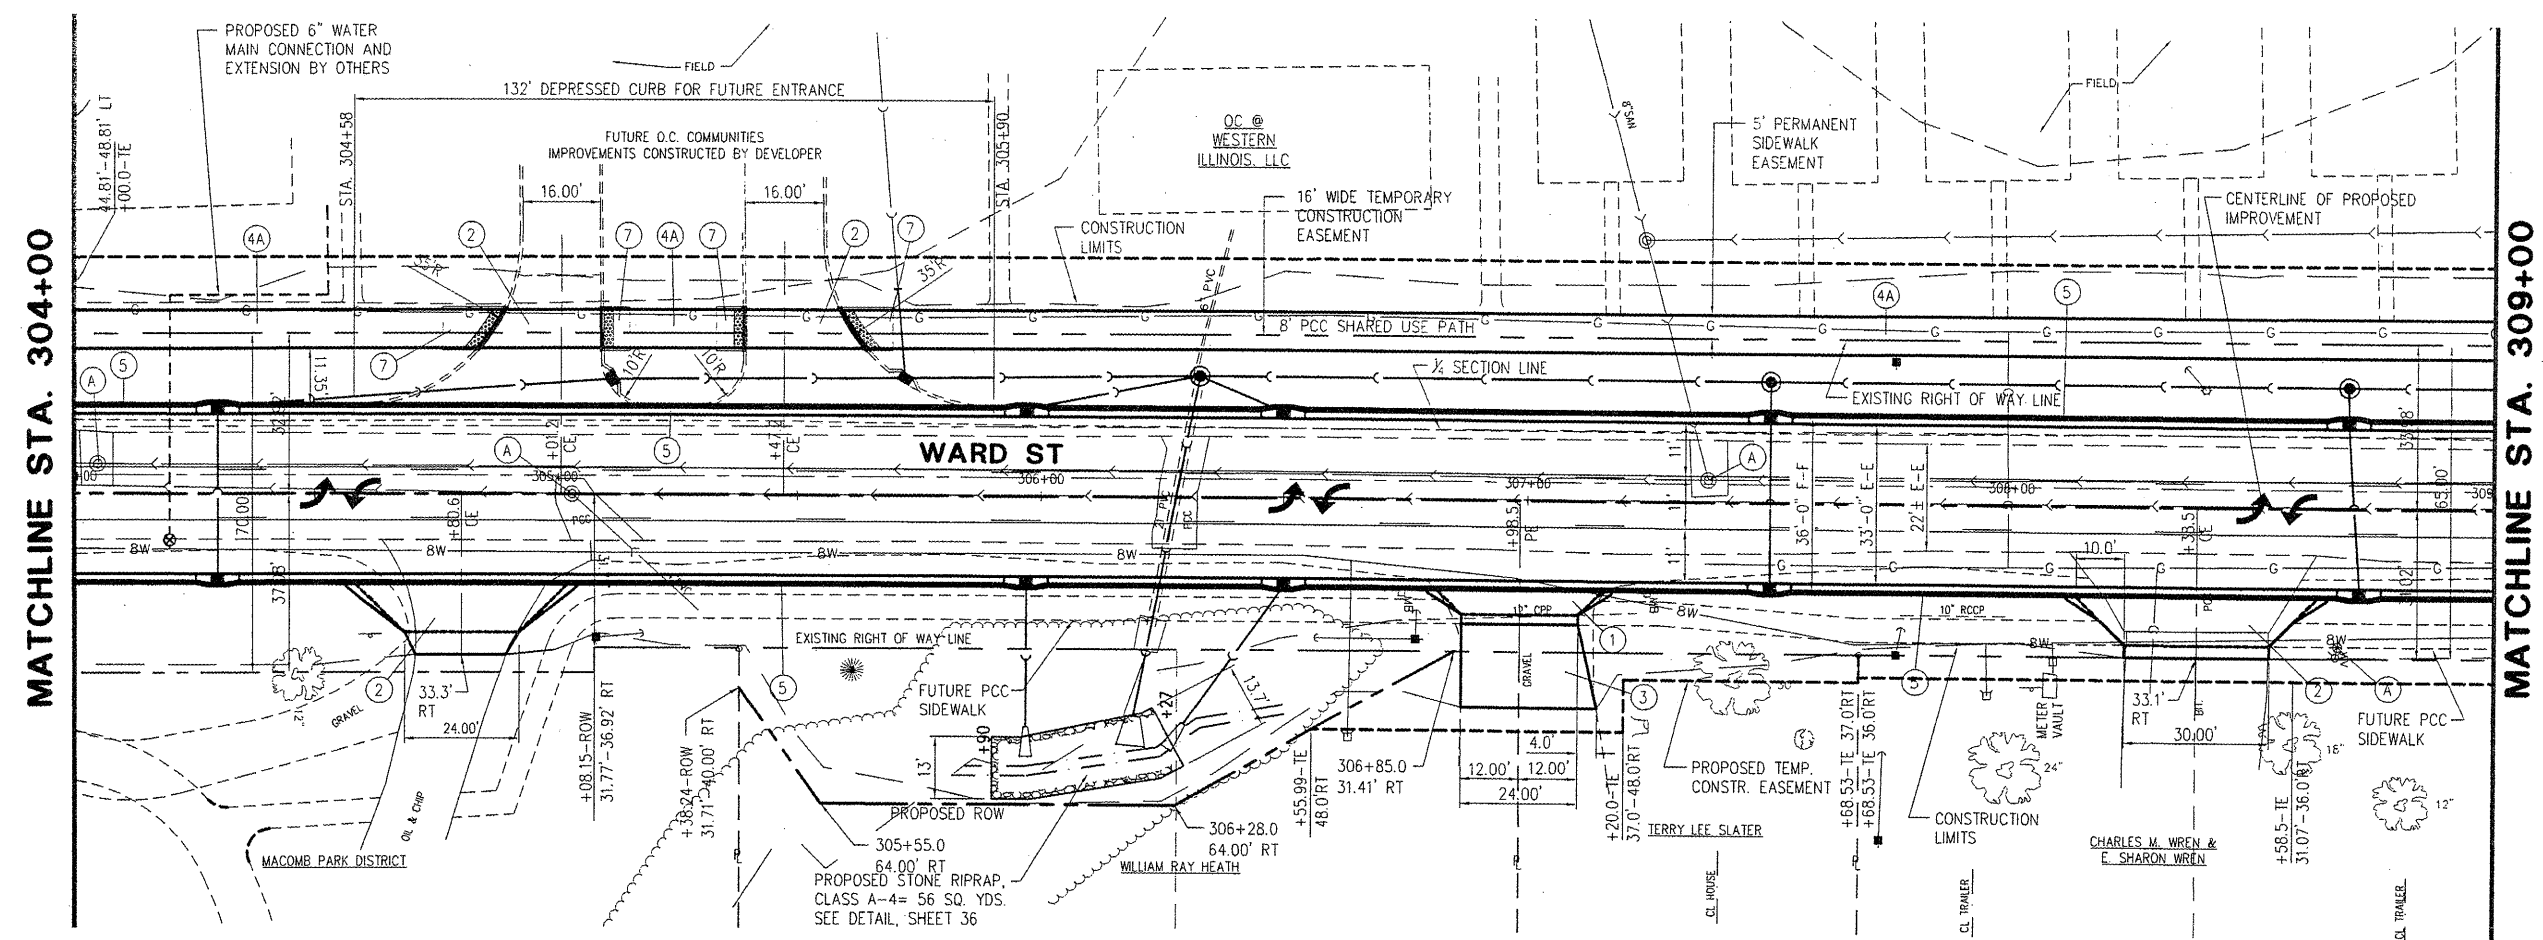

- ITEM LEGEND**
- ① PCC DRIVEWAY PAVEMENT, 6"
 - ② PCC DRIVEWAY PAVEMENT, 7"
 - ③ AGGREGATE SURFACE COURSE, TYPE A, 6"
 - ④ PCC SIDEWALK, 4"
 - ④A PCC SIDEWALK 5"
 - ⑤ COMB. CONC. CURB & GUTTER, TYPE B6.18
 - ⑥ CONCRETE CURB, TYPE B, 6"
 - ⑦ SIDEWALK RAMP W/ DETECTABLE WARNING
 - ⑧ AGGREGATE SURFACE COURSE, TYPE A, 8"
 - (A) MANHOLE, VALVE BOX, WATER SERVICE BOX OR METER VAULT TO BE ADJUSTED

