

MATCHLINE STA. 314+00

MATCHLINE STA. 319+00


**STORM INL-41**  
 MANHOLE SPECIAL TYPE 1  
 STA. 315+56.5, 18.5' LT  
 EP=687.33  
 IE=683.43(E)  
 IE=681.37(N)  
 IE=681.27(S)

**STORM INL-39**  
 MANHOLE SPECIAL TYPE 2  
 STA. 317+65, 18.5' LT  
 EP=687.70  
 IE=684.44(E)  
 IE=683.05(N)  
 IE=682.95(S)

CITY OF MACOMB-WARD STREET  
 SEC. 06-00139-00-PV F.A.U. 6919  
 PROJ. M05040 (009)  
 CONTRACT No. 89469 SHT 21 OF 59

SHEET NO.  
**21**  
 of **59**

**McClure**  
 Engineering Associates, Inc.  
 Macomb, Illinois 61455  
 13091 833-4594  
 FAX 13091 837-4809  
 Design firm License #184-000816 Copyright 2008 by McClure Engineering Associates, Inc.

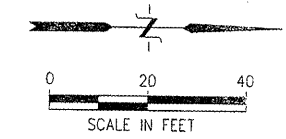

**STORM INL-35**  
 INLET TY A, 2'0", TY 8 GR  
 STA. 318+54.5, 37.5' LT  
 RIM=687.40  
 IE=684.56(E)




**STORM INL-36**  
 MANHOLE SPECIAL TYPE 1  
 STA. 318+59.2, 18.5' LT  
 RIM=688.29  
 IE=684.44(W)  
 IE=684.84(E)  
 IE=684.01(N)  
 IE=683.91(S)

**STORM INL-37**  
 INLET SPECIAL No. 1  
 STA. 318+59.3, 20.21' RT  
 EP=688.24  
 IE=685.10(NE)  
 IE=685.00(W)

**STORM INL-38**  
 INLET TY A 2'0", TY 8 GR  
 STA. 318+70, 30.35' RT  
 RIM=687.97  
 IE=685.18(SW)

**STORM INL-42**  
 INLET SPECIAL No. 1  
 STA. 315+56.5, 21.4' RT  
 EP=687.18  
 IE=683.61(W)

**STORM INL-40**  
 INLET SPECIAL No. 2  
 STA. 317+65, 17.75' RT  
 EP=687.70  
 IE=684.60(W)

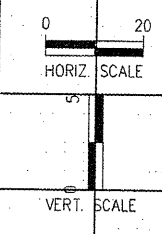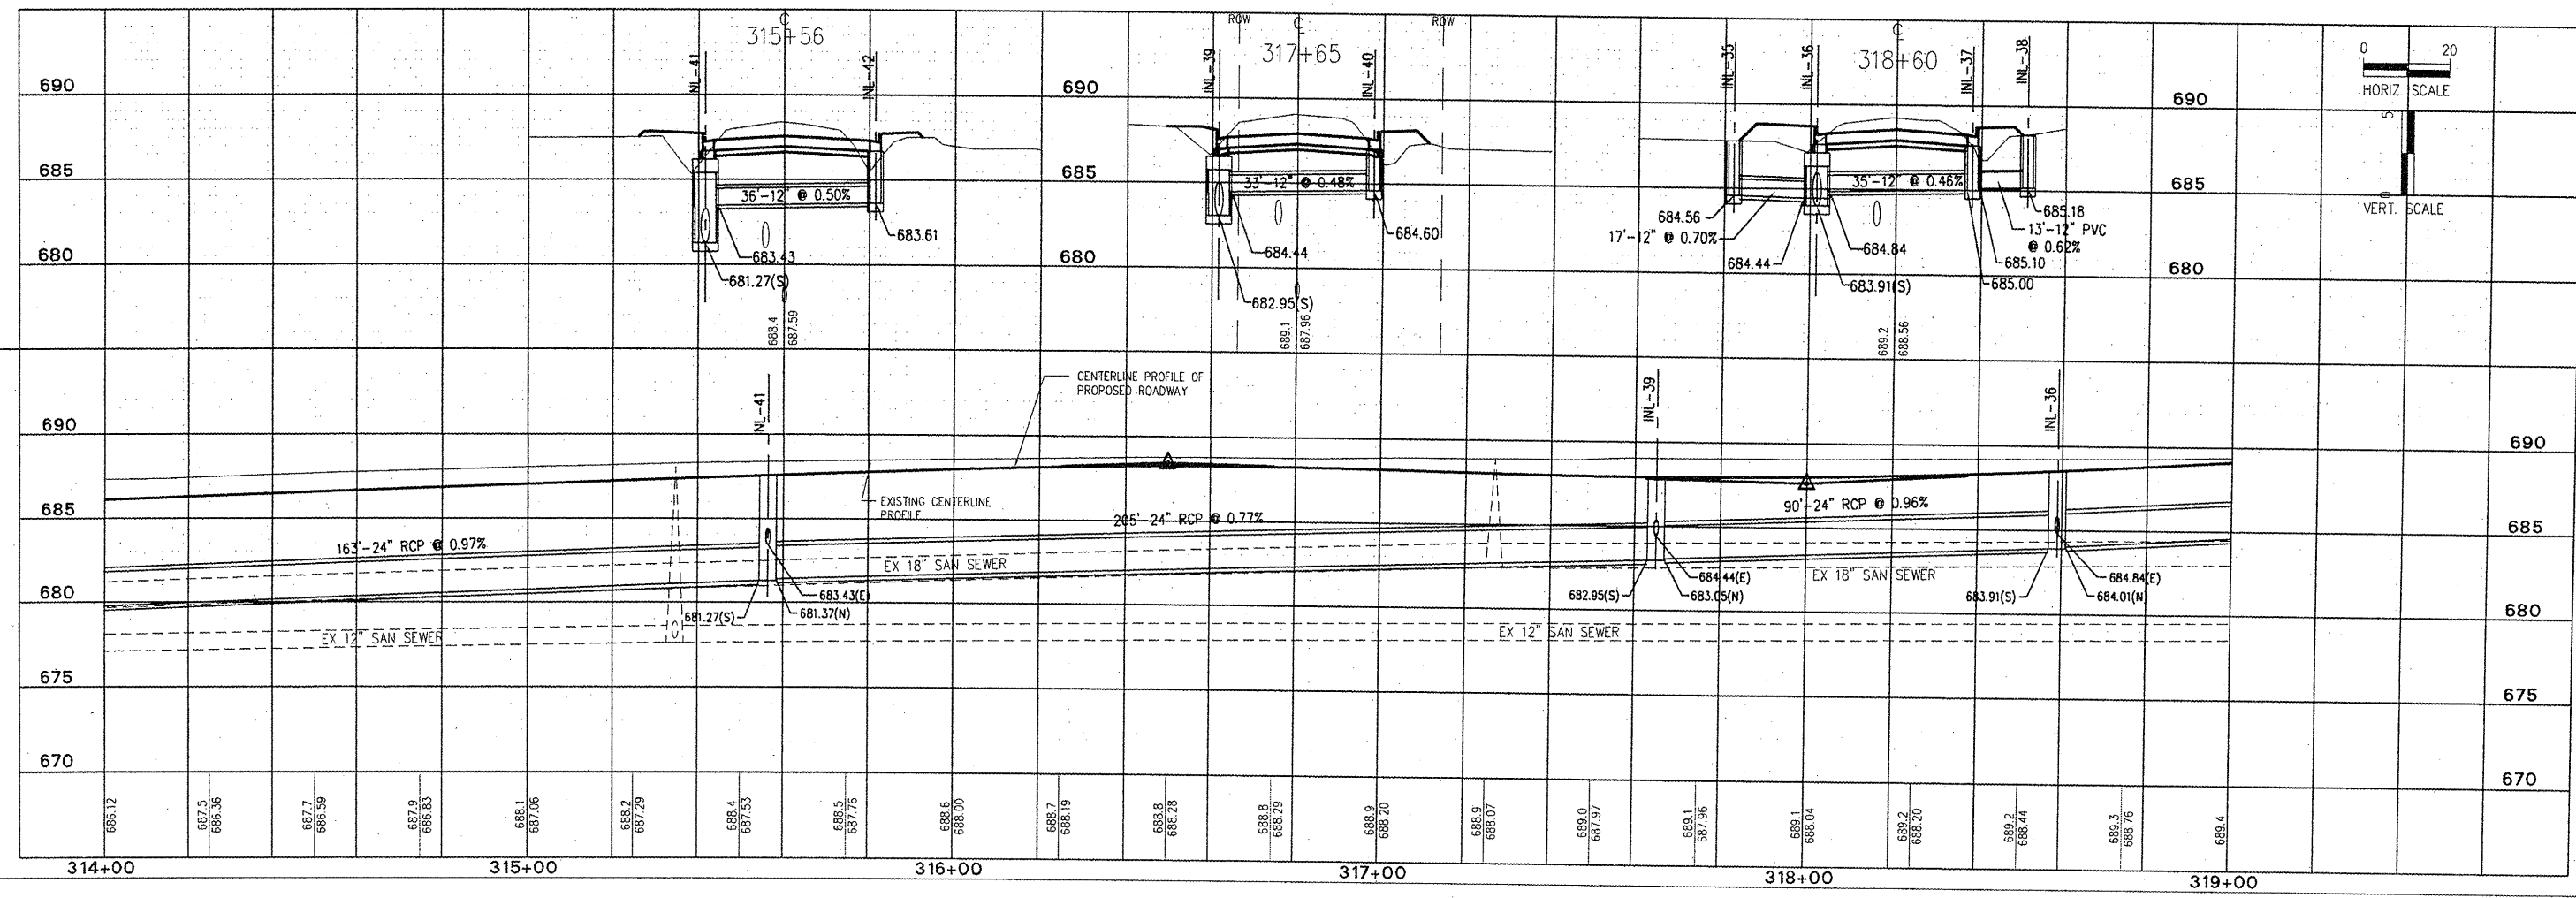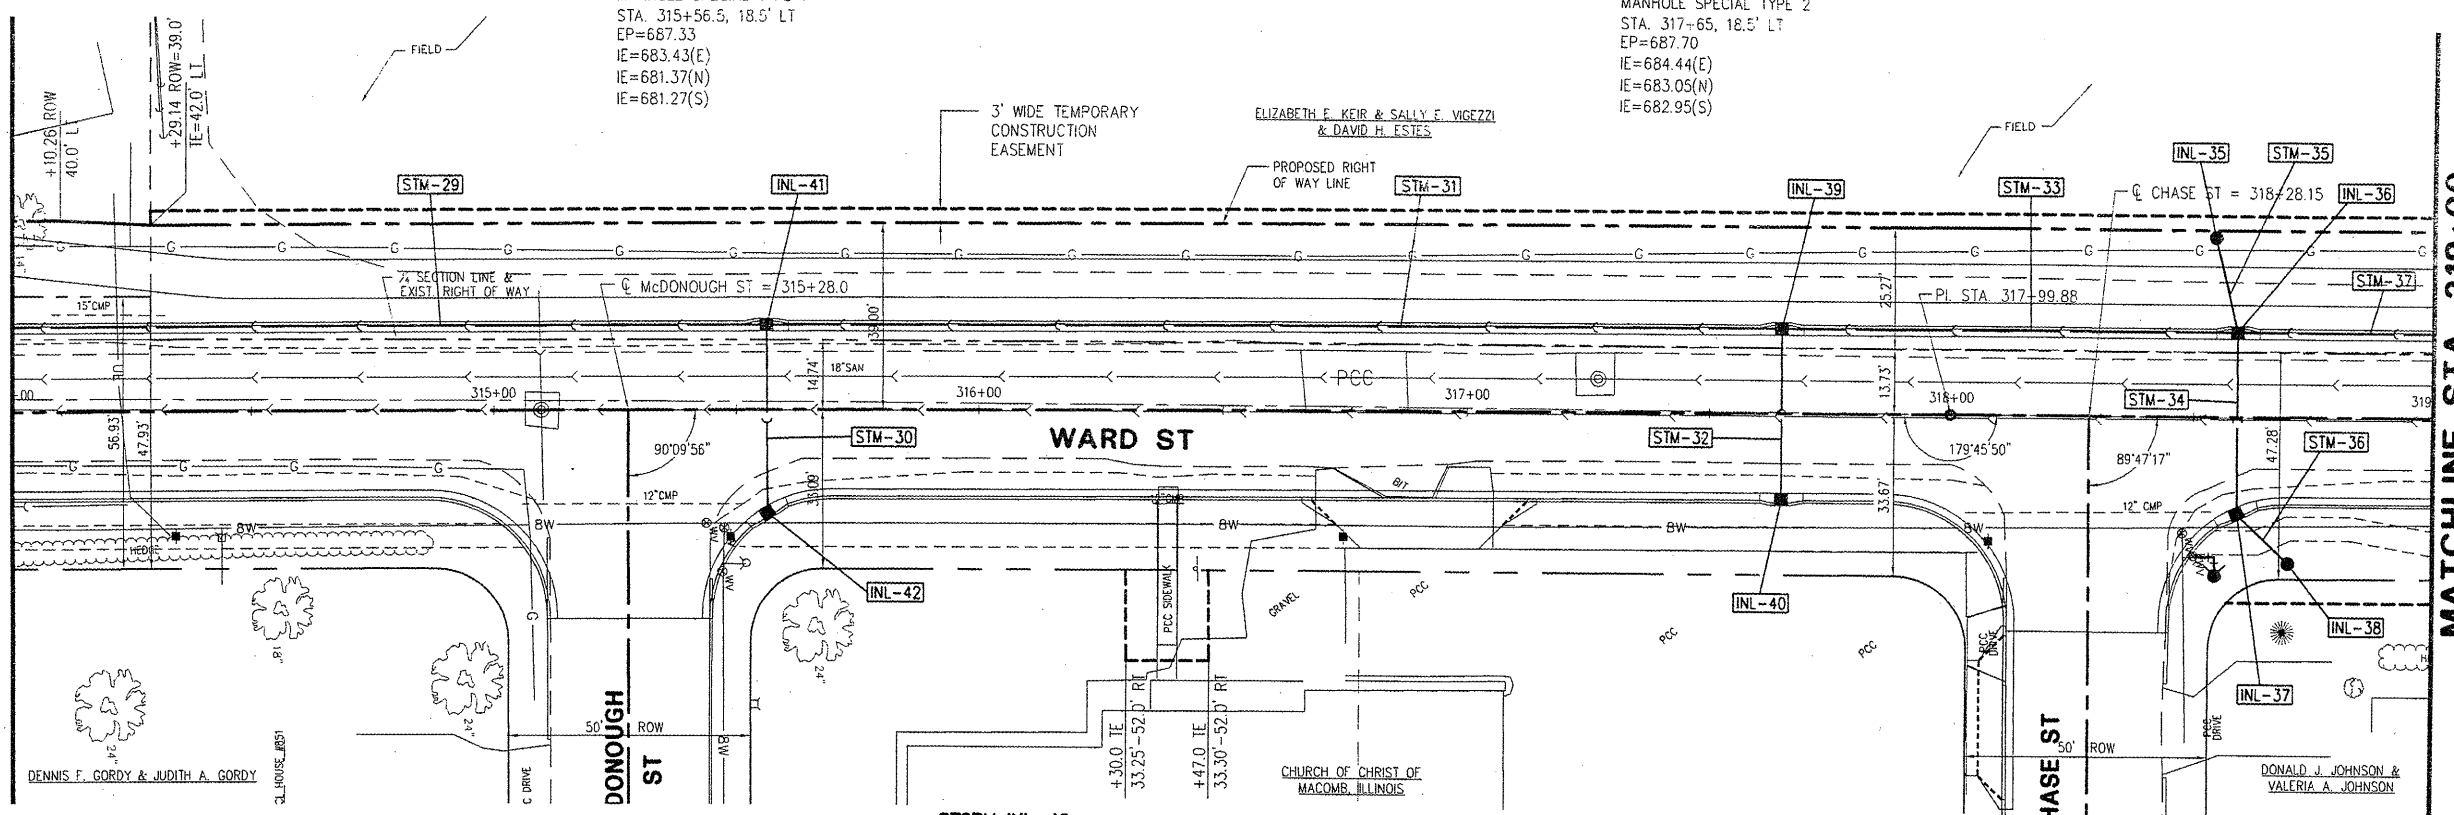

NO.	REVISIONS	DATE

**WARD STREET IMPROVEMENTS**  
**STORM SEWER PLAN AND PROFILE - STA. 314+00 TO 319+00**  
 CITY OF MACOMB  
 SOUTH WARD ST.  
 FILE NAME: W:\DRAWINGS\MACOMB\WARDST\WARD-ST-2007 FIELD BOOK No. 2257 JOB NUMBER: 03-28-0609  
 MACOMB, ILLINOIS

PLOTTING SCALE: 1" = 20'  
 DRAWN BY: TAB  
 CHECKED BY: ECM  
 DATE: OCTOBER 2008