
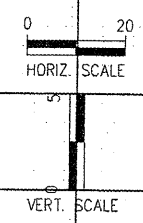
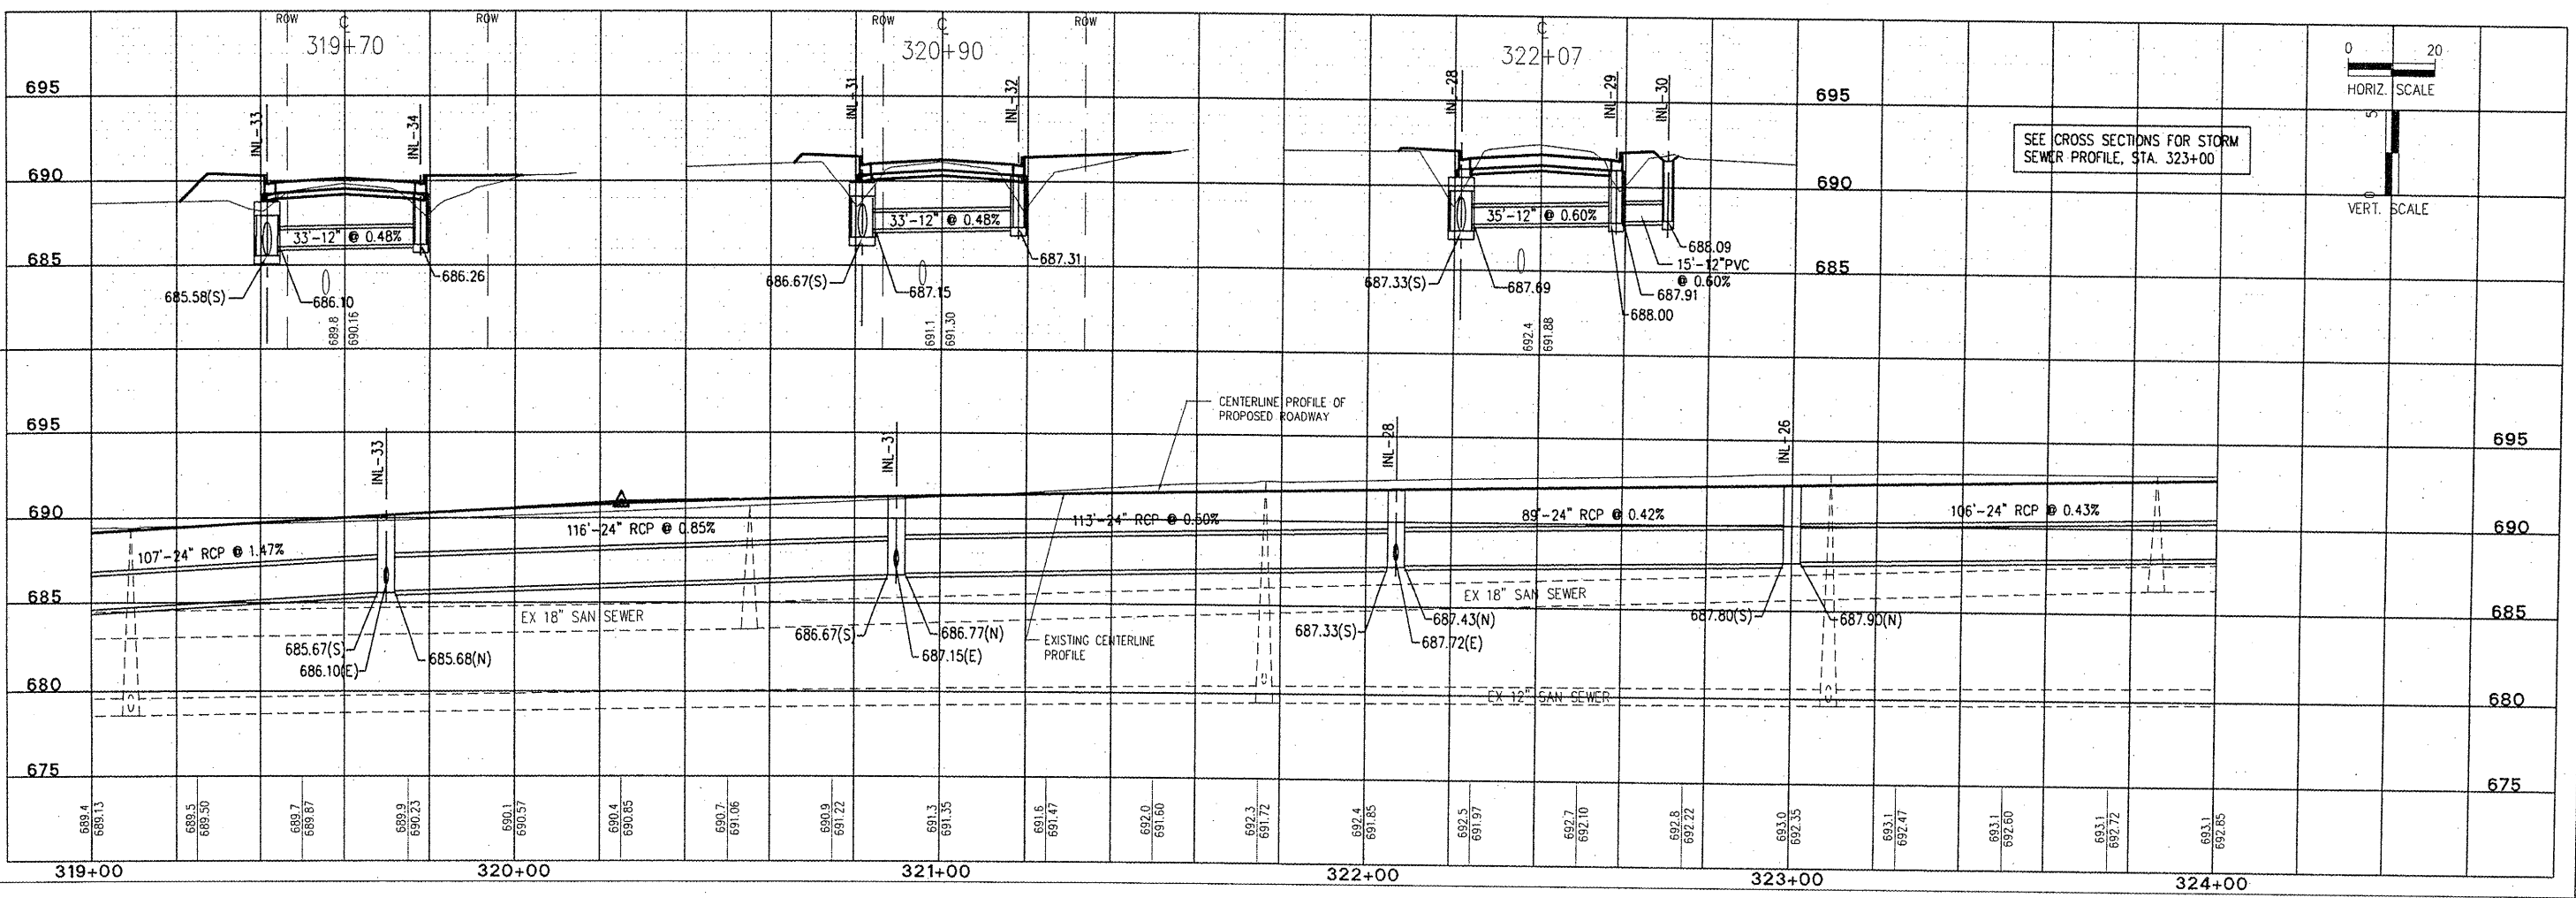
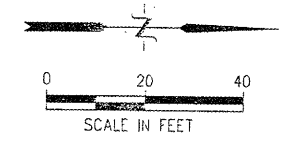


**McClure**  
 Engineering Associates, Inc.  
 Macomb, Illinois 61455  
 714 East Jackson Street  
 (309) 833-4594  
 Design firm License #184-000816 Copyright 2008 by McClure Engineering Associates, Inc.

PLOTTING SCALE: 1" = 20'  
 DRAWN BY: TAB  
 CHECKED BY: JAR  
 DATE: OCTOBER 2008

NO.	REVISIONS	DATE

**WARD STREET IMPROVEMENTS**  
**STORM SEWER PLAN AND PROFILE - STA. 319+00 TO 324+00**  
 CITY OF MACOMB  
 SOUTH WARD ST.  
 FILE NAME: W:\DRAWINGS\MACOMB\WARDST\WARD-ST-2007  
 FIELD BOOK No. 2227 JOB NUMBER: 03-28-0908  
 MACOMB, ILLINOIS

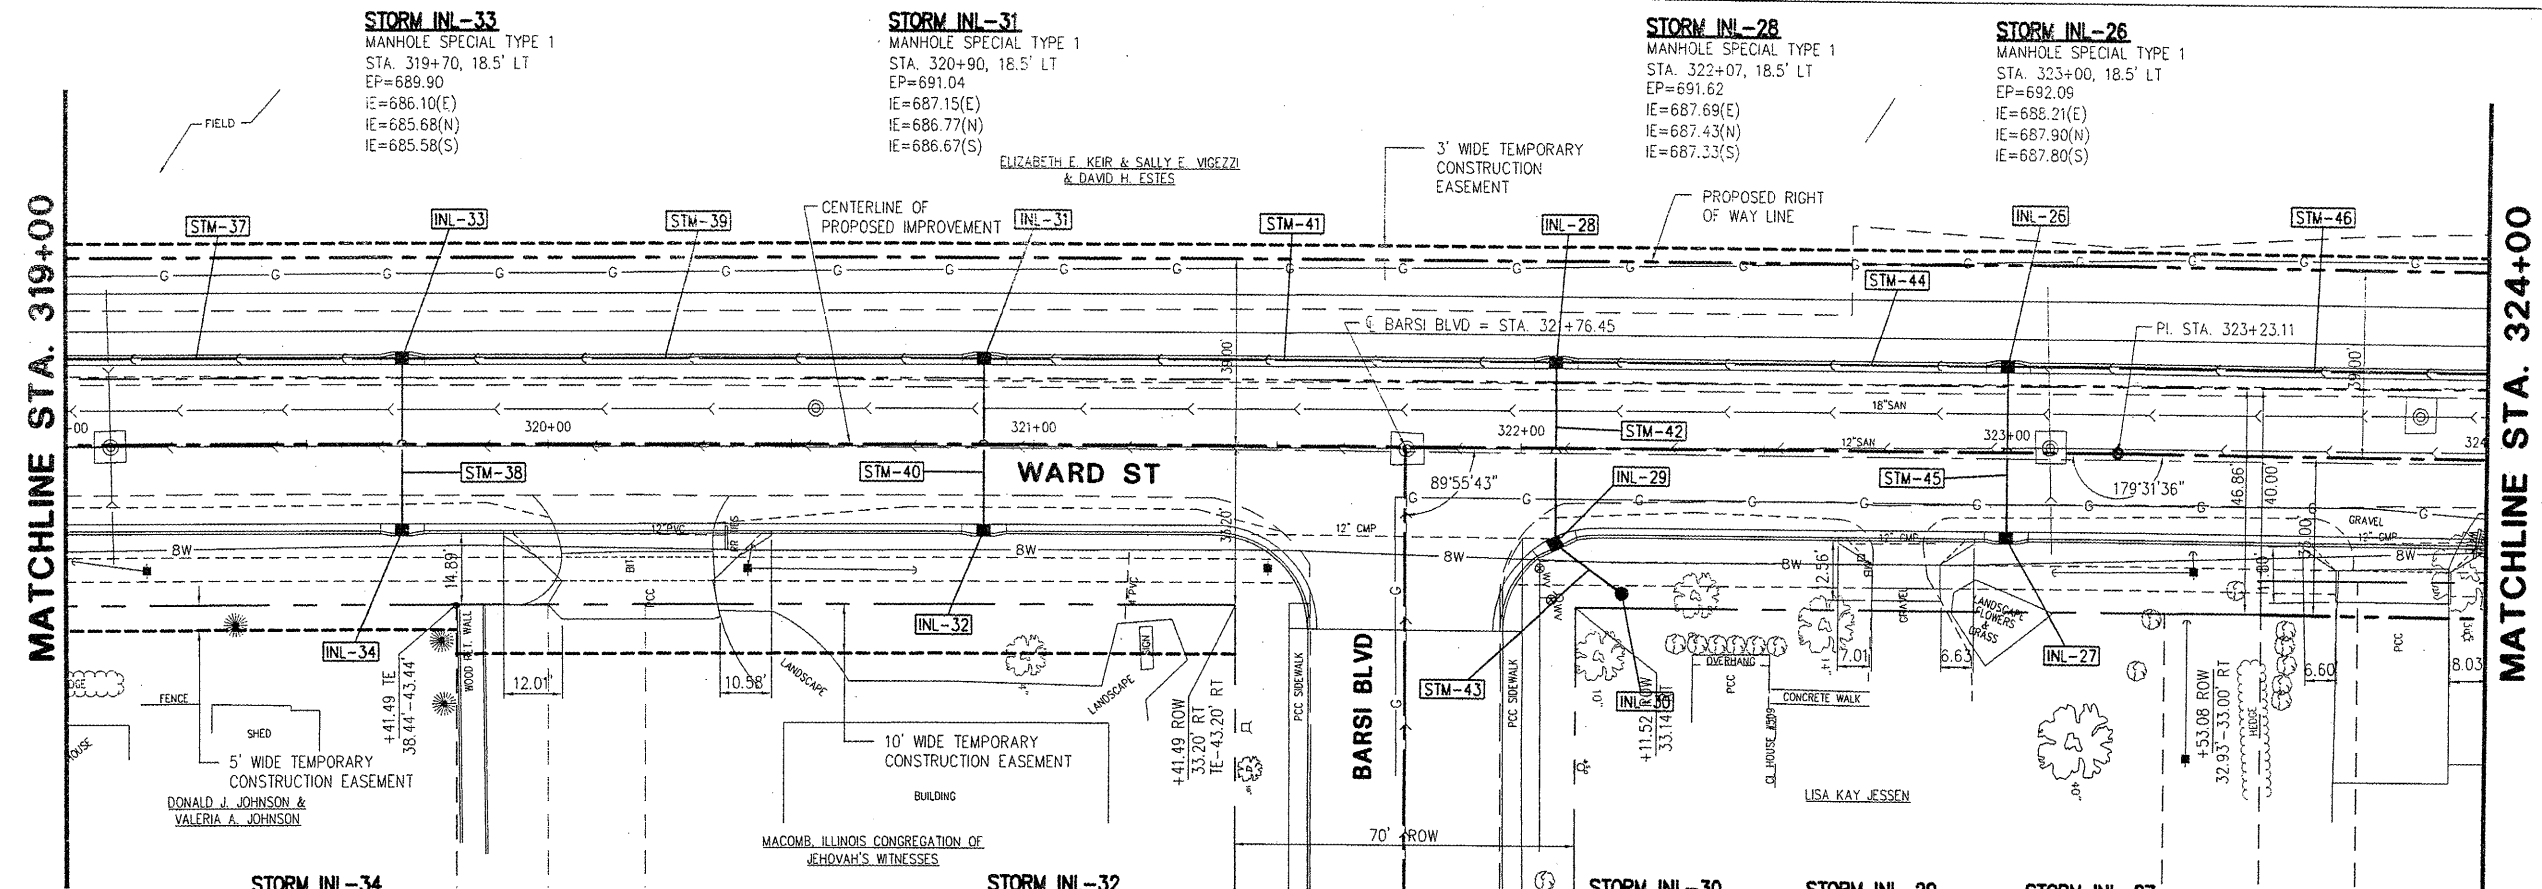

SEE CROSS SECTIONS FOR STORM SEWER PROFILE, STA. 323+00