



DATE: Thursday, February 26, 2009 2:04:42 PM
 FILE: K:\Dwg\0825702 Airfield Signage Phase 1 And 2\Sign-plan_S116.dwg
 UPDATE BY: Jeremy Linke
 LAYOUT: Sheet 6

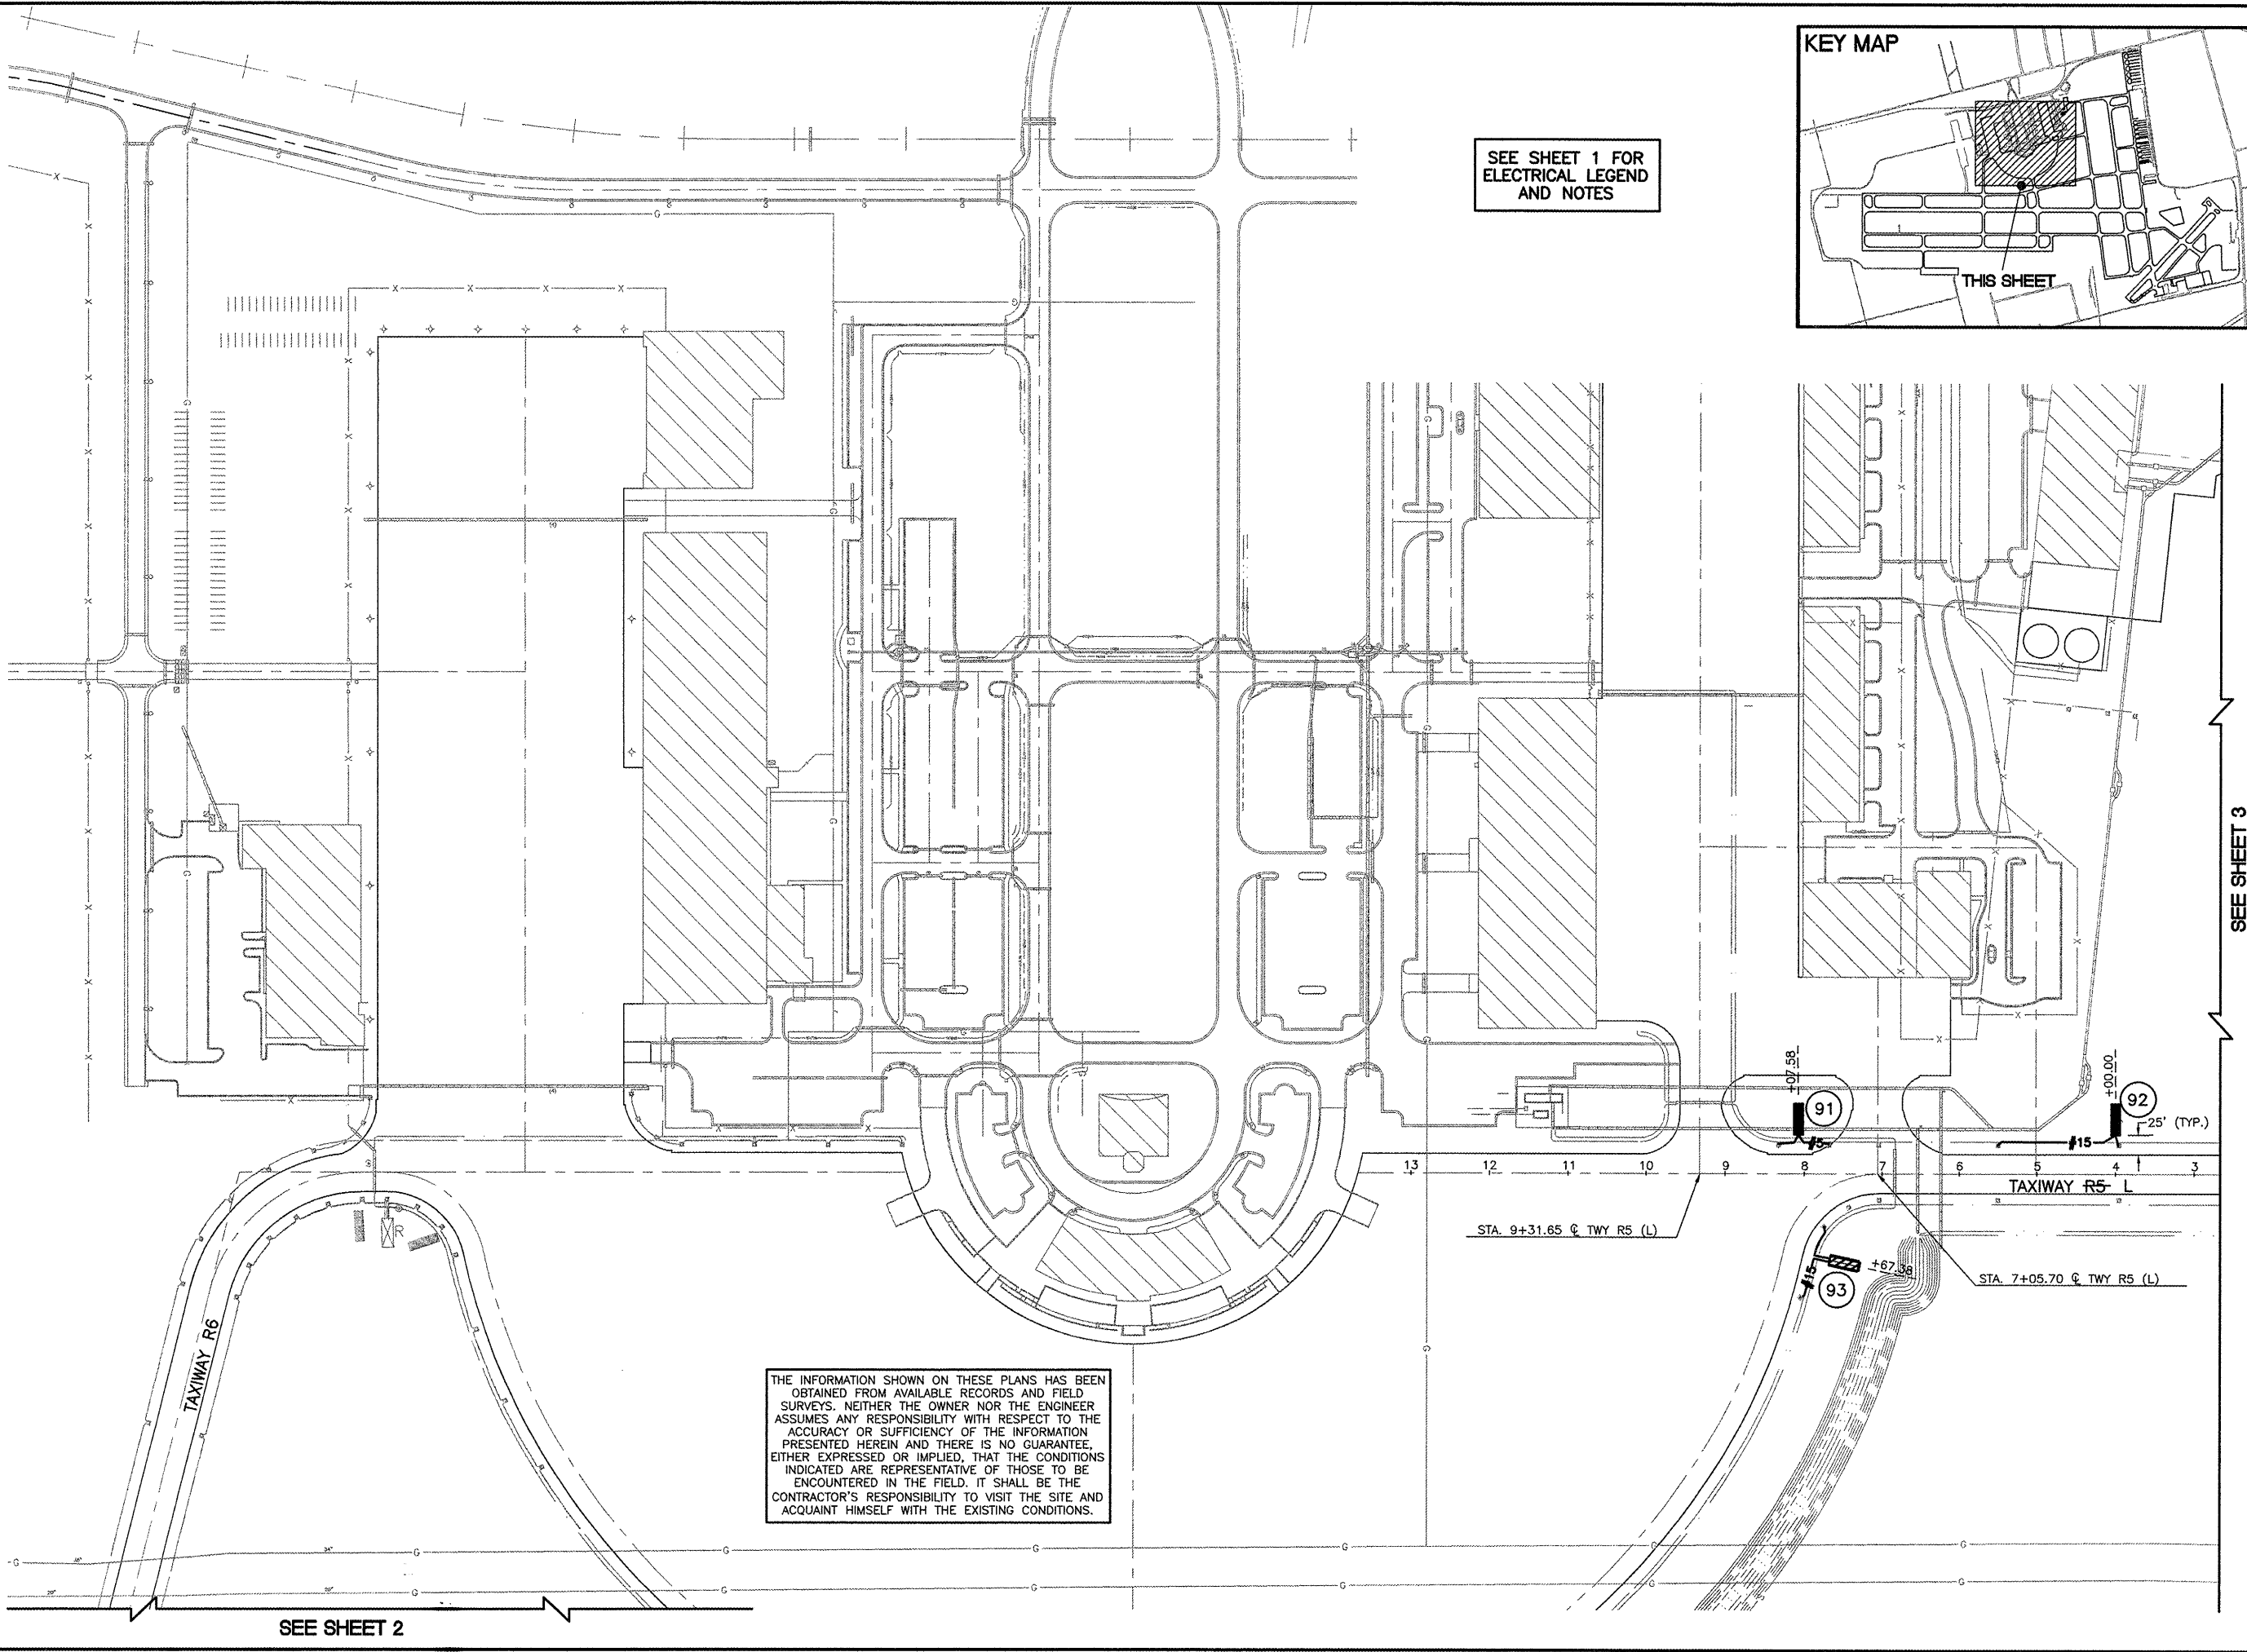


SEE SHEET 1 FOR
ELECTRICAL LEGEND
AND NOTES

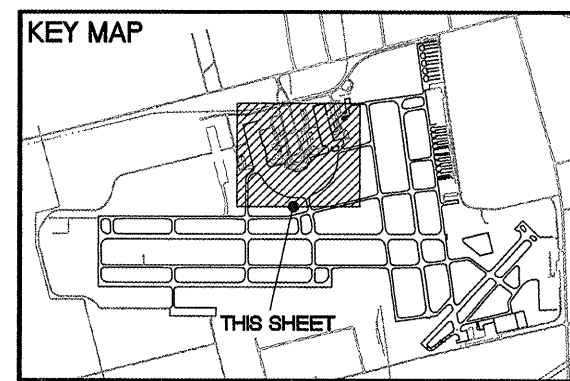

IL CONTRACT: **DU078**
 IL LETTING ITEM: **9A**
 IL PROJECT: **DPA-3836**
 A.I.P. PROJECT: **3-17-0017-B23**

SURVEY BOOK # BOOK #

REVISIONS		
NUMBER	BY	DATE

 

**DUPAGE AIRPORT
 WEST CHICAGO, ILLINOIS
 AIRFIELD SIGNAGE UPDATES**

PROPOSED IMPROVEMENTS - SHEET 6

© Copyright CMT, Inc.

CMT
 CRAWFORD, MURPHY & TILLY, INC.
 CONSULTING ENGINEERS
 License No. 184-000813

DPA
 DuPage Airport

DESIGN BY: JRL / AAO
 DRAWN BY: JRL / JRO
 CHECKED BY: JRL
 APPROVED BY: DLP
 DATE: 2/27/2009
 JOB No: 08257-02-00

FINAL

SHEET 11 OF 18 SHEETS

THE INFORMATION SHOWN ON THESE PLANS HAS BEEN OBTAINED FROM AVAILABLE RECORDS AND FIELD SURVEYS. NEITHER THE OWNER NOR THE ENGINEER ASSUMES ANY RESPONSIBILITY WITH RESPECT TO THE ACCURACY OR SUFFICIENCY OF THE INFORMATION PRESENTED HEREIN AND THERE IS NO GUARANTEE, EITHER EXPRESSED OR IMPLIED, THAT THE CONDITIONS INDICATED ARE REPRESENTATIVE OF THOSE TO BE ENCOUNTERED IN THE FIELD. IT SHALL BE THE CONTRACTOR'S RESPONSIBILITY TO VISIT THE SITE AND ACQUAINT HIMSELF WITH THE EXISTING CONDITIONS.

SEE SHEET 2

SEE SHEET 3