
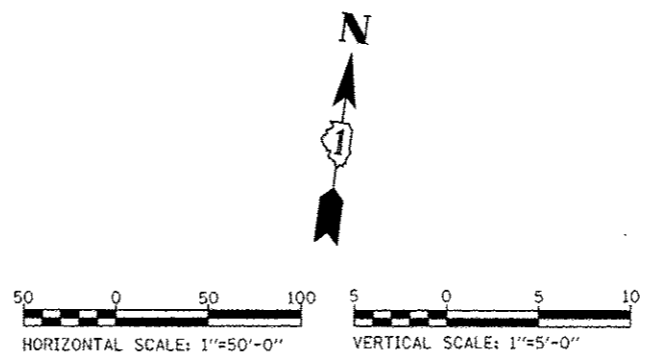



PLAN	DATE
BY	
DESIGNED	
DRAWN	
CHECKED	
DATE	
NOTE BOOK NO.	
FILE NAME	

PROFILE	DATE
BY	
DESIGNED	
DRAWN	
CHECKED	
DATE	
NOTE BOOK NO.	
FILE NAME	

MATCH LINE STA. 1028+00
SEE DRAWING DP-10

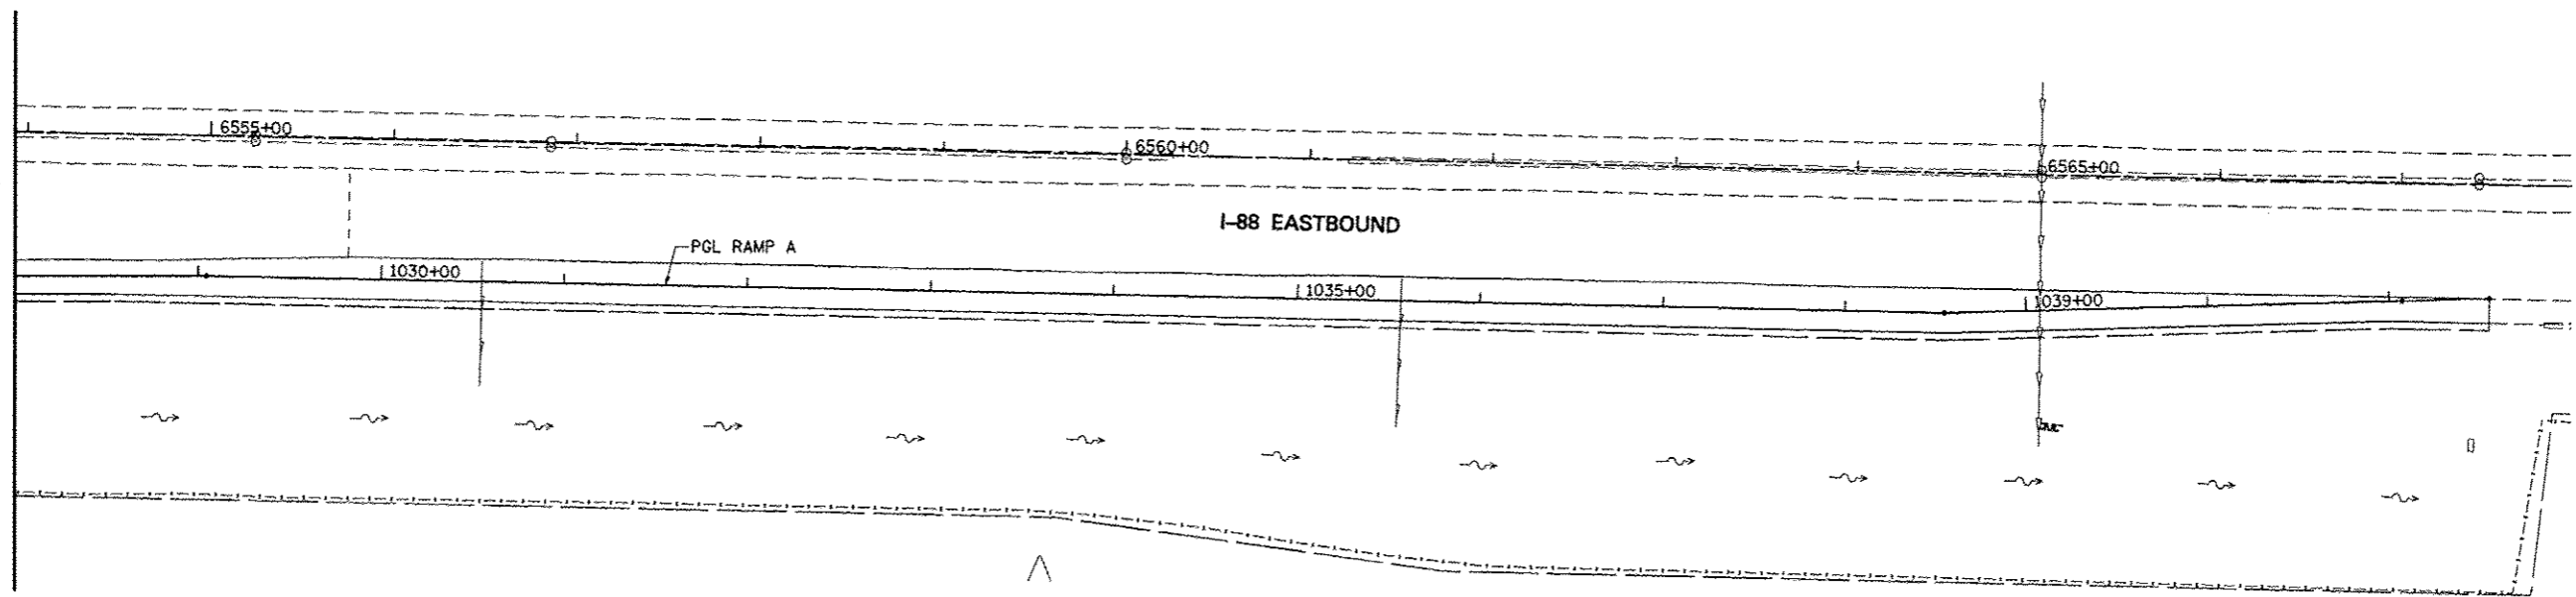

NOTE:
SEE DRAWING DN-01 FOR DRAINAGE LEGEND.

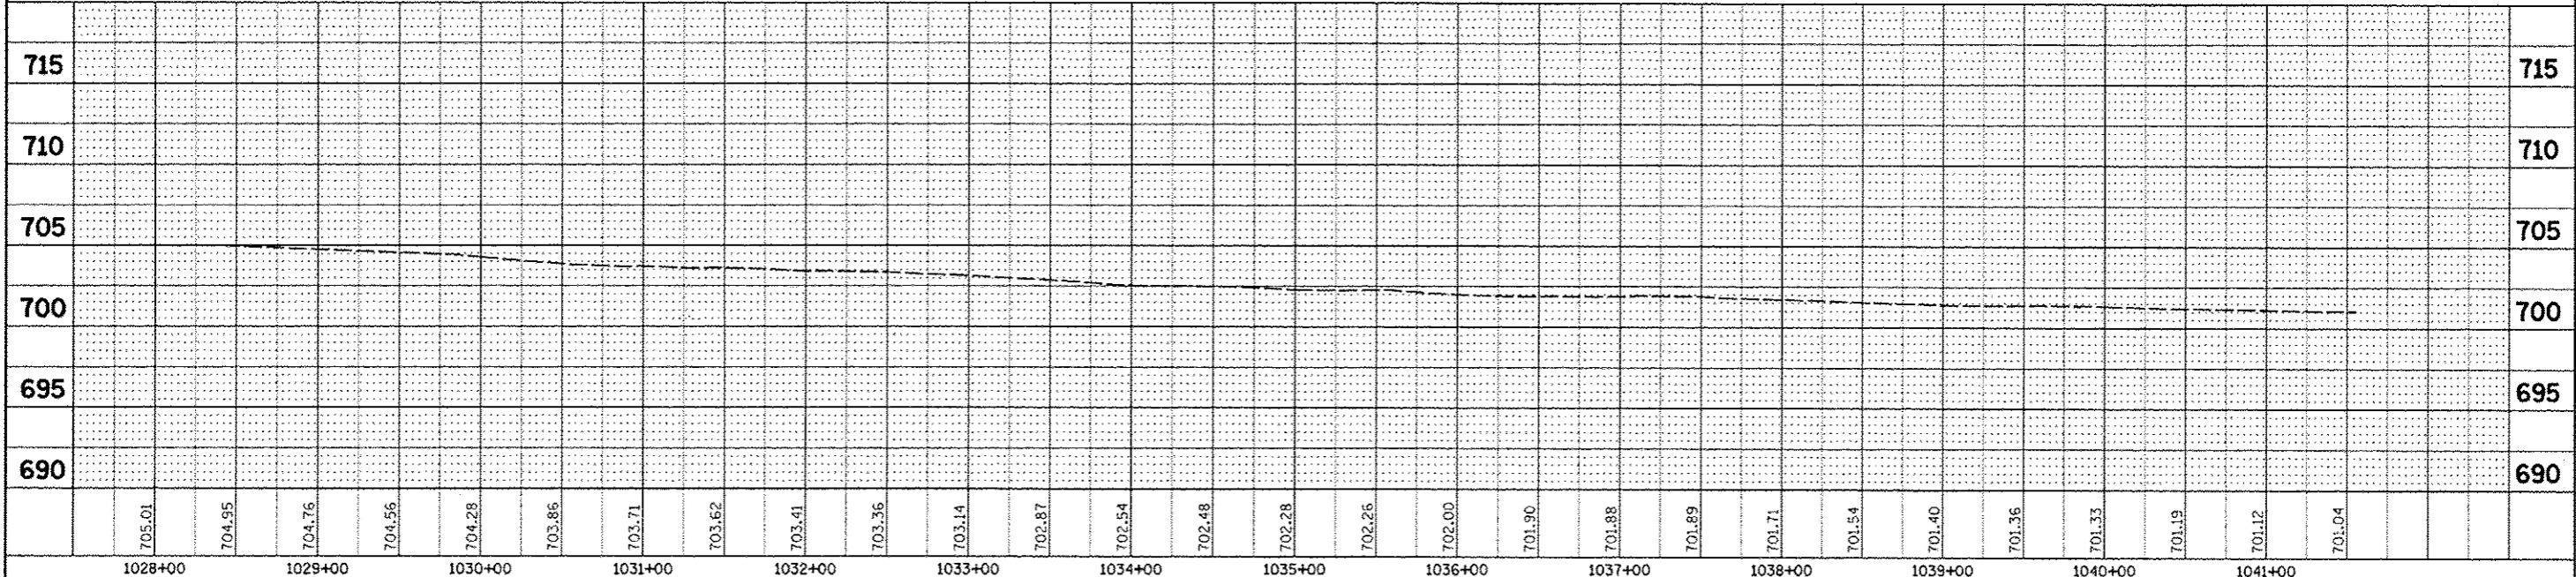

FILE NAME	USER NAME = #USER#	DESIGNED <i>JWM</i>	REVISED -	STATE OF ILLINOIS DEPARTMENT OF TRANSPORTATION	PROPOSED DRAINAGE PLAN & PROFILE- RAMP A	F.A.P. RTE.	SECTION	COUNTY	TOTAL SHEETS	SHEET NO.
#FILE#	DRAWN <i>KES</i>	REVISED -	338			(112 & 113) WRS-5	DUPAGE	963	345	
FILE SCALE = #SCALE#	CHECKED <i>JRS</i>	REVISED -	DP-08			CONTRACT NO. 60131				
FILE DATE = #DATE#	DATE <i>10/15/2012</i>	REVISED -	SCALE: 1"=50'			SHEET NO. 8 OF 12 SHEETS		STA. 1028+00 TO STA. END		
						FED. ROAD DIST. NO. ILLINOIS FED. AID PROJECT				