



TYPICAL SPLICE DETAIL

N.T.S.

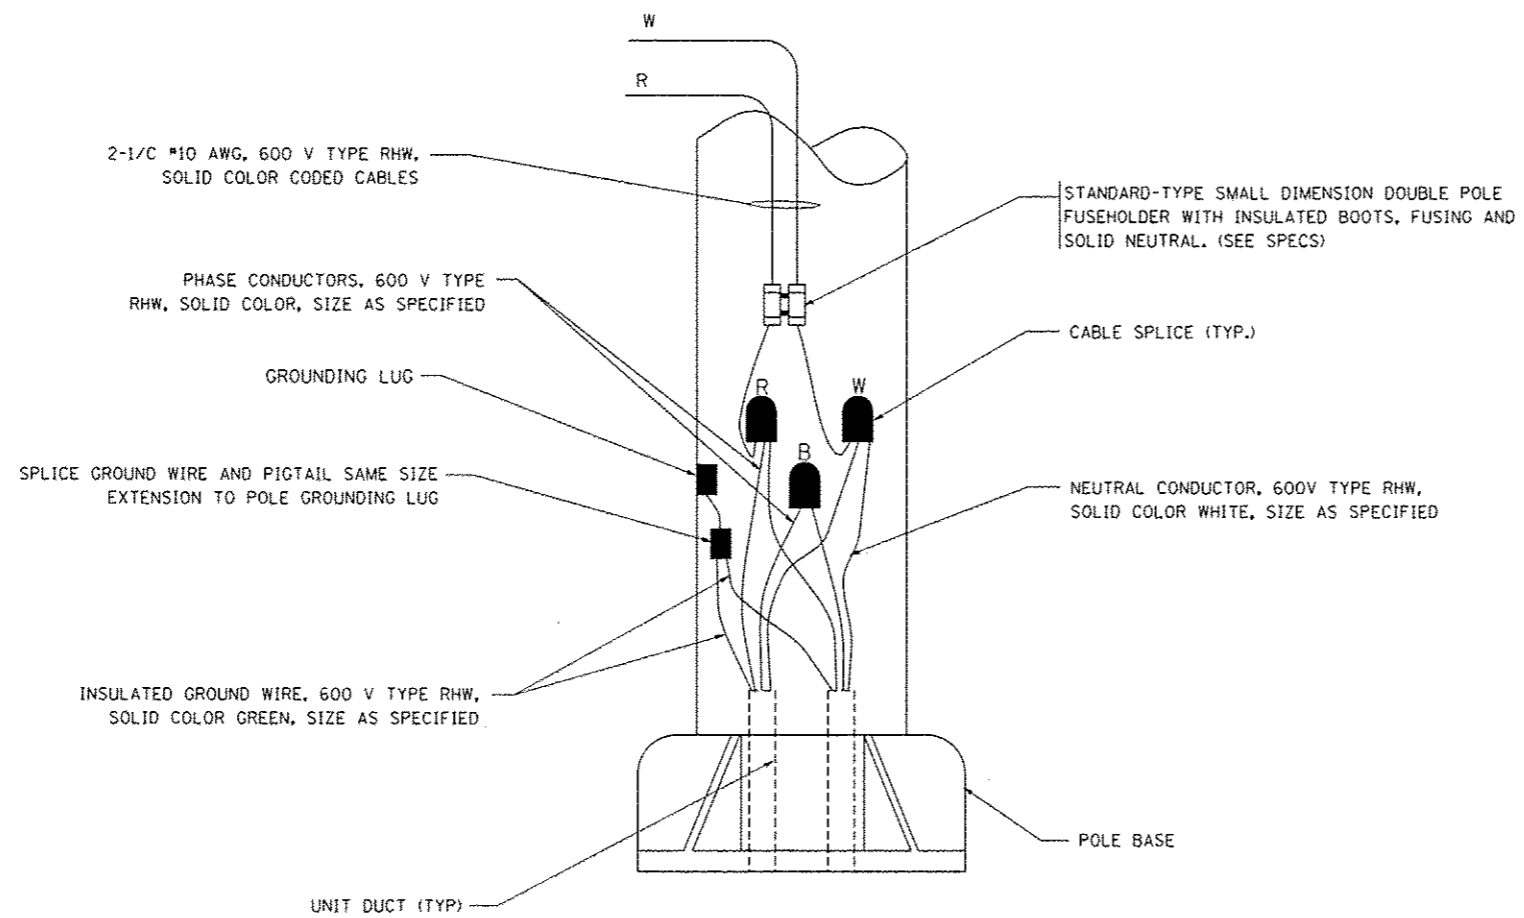

POLE WIRING DETAIL

N.T.S.

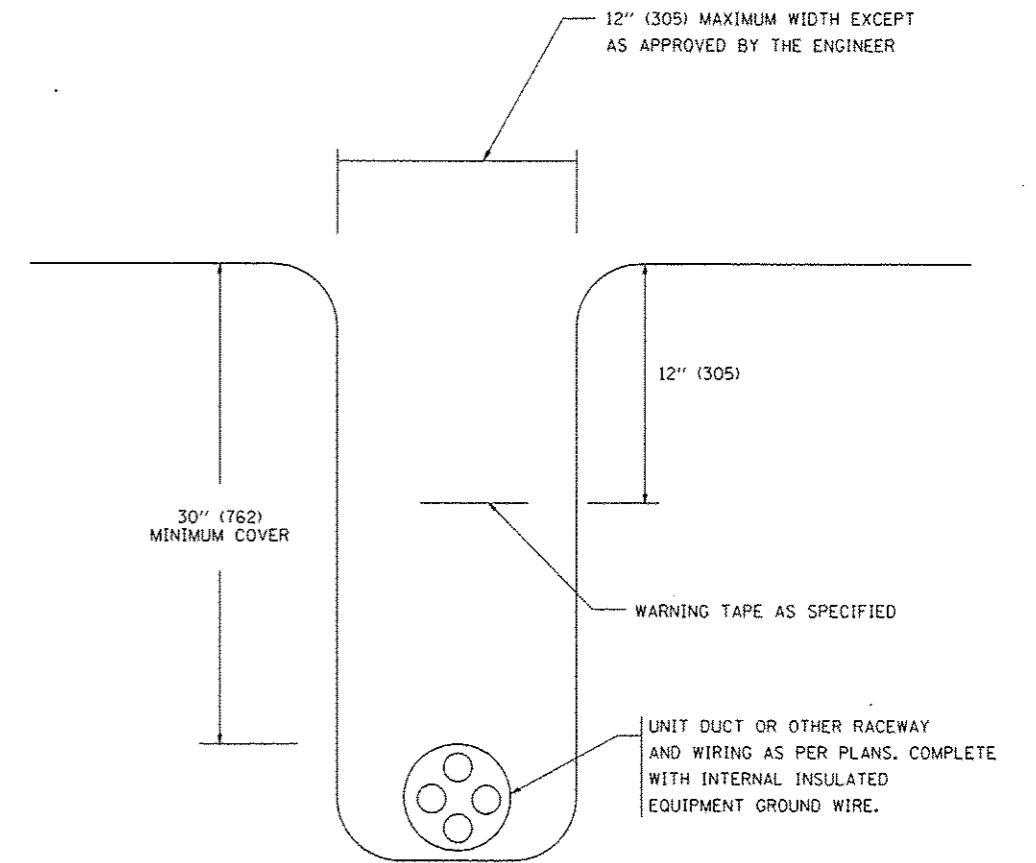

TYPICAL WIRING IN TRENCH DETAIL

N.T.S.

FILE NAME = W:\diststd\22x34\be702.dgn

USER NAME = gaglianobt

DESIGNED -

DRAWN -

PLDT SCALE = 50.000' / IN.

PLOT DATE = 1/4/2000

CHECKED -

DATE -

REVISED - 08-08-03

REVISED -

REVISED -

REVISED -

STATE OF ILLINOIS
DEPARTMENT OF TRANSPORTATION

MISC. ELECTRICAL DETAILS
SHEET A

SCALE: NONE

SHEET NO. 1 OF 1 SHEETS

STA. TO STA.

F.A. RTE.	SECTION	COUNTY	TOTAL SHEETS	SHEET NO.
338	(112 & 113) WRS-5	DUPAGE	963	718
BE-702			CONTRACT NO. 60131	
FED. ROAD DIST. NO. 1 ILLINOIS FED. AID PROJECT				