



MATCHLINE "0"
SEE SHEET NO. 183

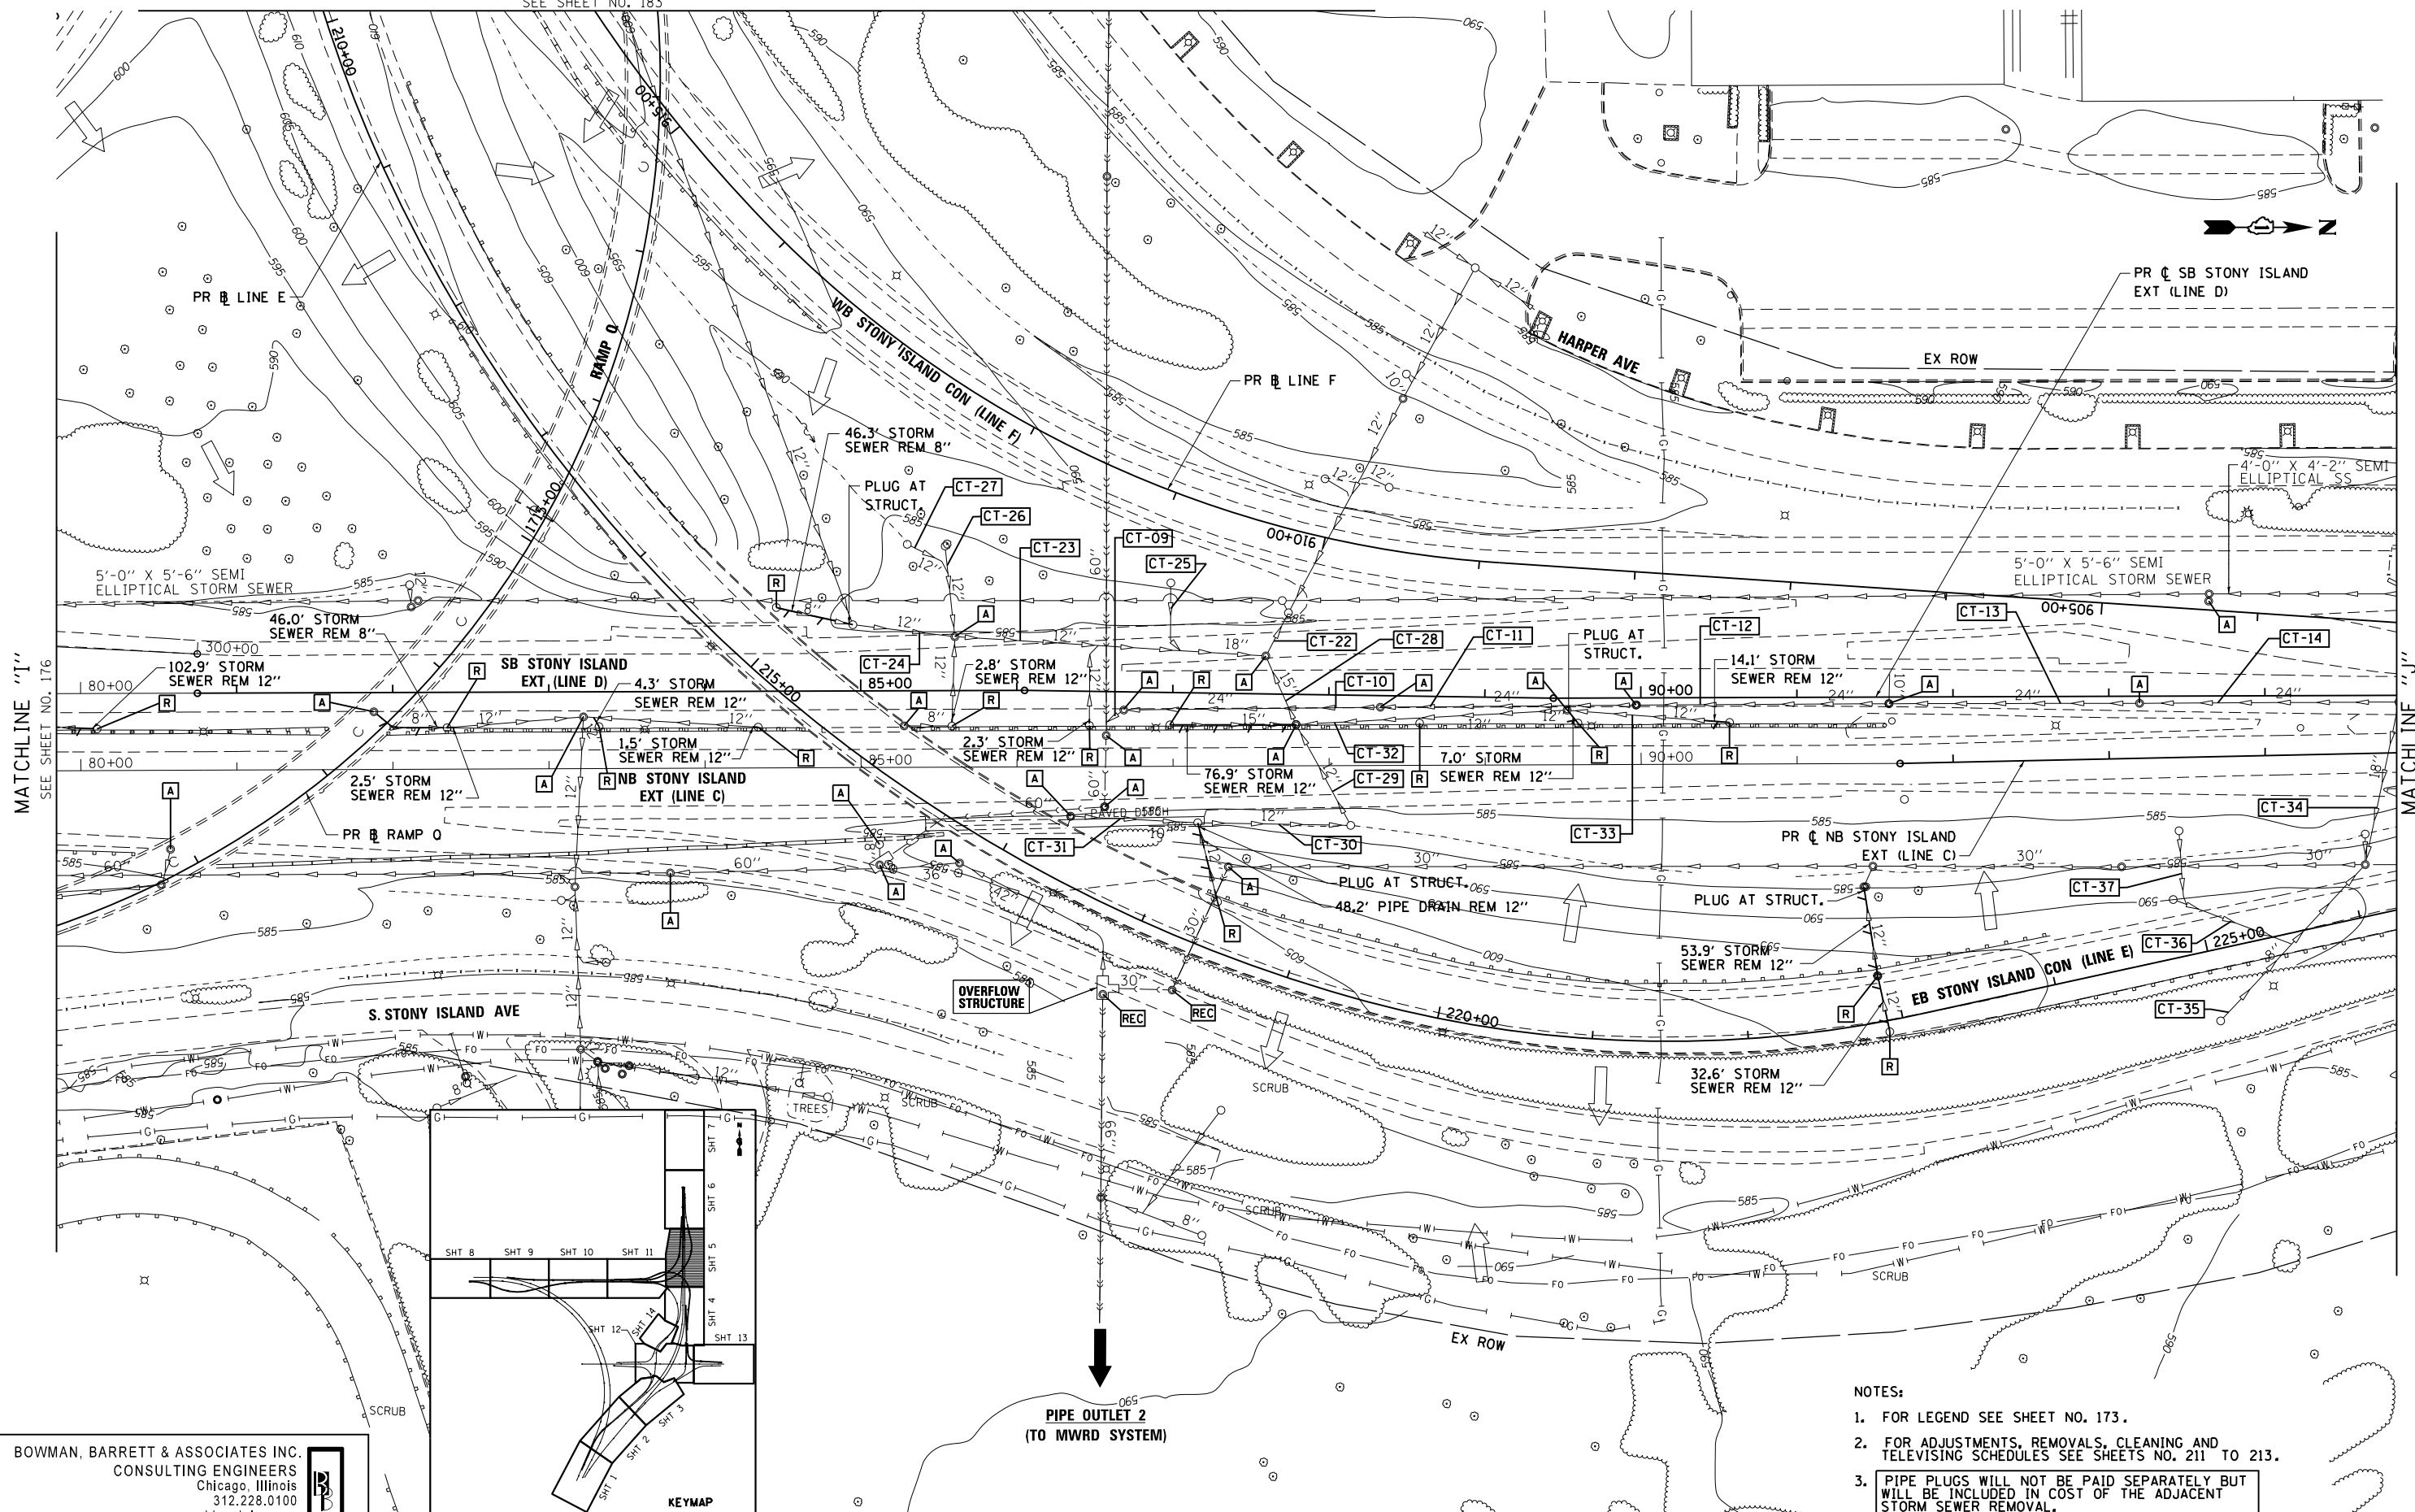

MATCHLINE "I"
SEE SHEET NO. 176

MATCHLINE "J"
SEE SHEET NO. 178

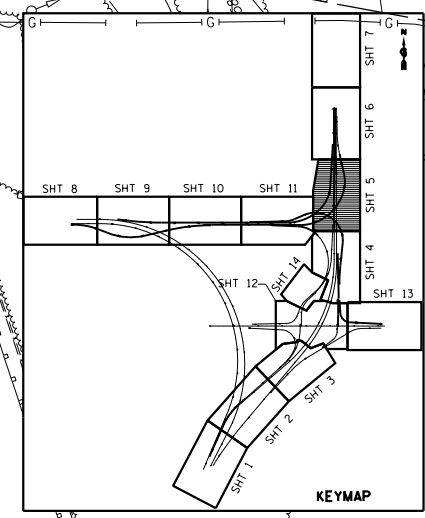

BOWMAN, BARRETT & ASSOCIATES INC.
CONSULTING ENGINEERS
Chicago, Illinois
312.228.0100
www.bbandainc.com

- NOTES:
- FOR LEGEND SEE SHEET NO. 173.
 - FOR ADJUSTMENTS, REMOVALS, CLEANING AND TELEVISION SCHEDULES SEE SHEETS NO. 211 TO 213.
 - PIPE PLUGS WILL NOT BE PAID SEPARATELY BUT WILL BE INCLUDED IN COST OF THE ADJACENT STORM SEWER REMOVAL.

FILE NAME =	USER NAME = default	DESIGNED - JAM	REVISED -
#FILE#		DRAWN - JAM	REVISED -
	PLOT SCALE = #SCALE#	CHECKED - RGR	REVISED -
	PLOT DATE = 4/2/2013	DATE - 03/29/2013	REVISED -

STATE OF ILLINOIS
DEPARTMENT OF TRANSPORTATION

EXISTING DRAINAGE PLAN
STONY ISLAND EXTENSION

SCALE: 1"=50' SHEET NO. 5 OF 14 SHEETS STA. TO STA.

F.A.I. RTE.	SECTION	COUNTY	TOTAL SHEETS	SHEET NO.
94	2012-059-BR	COOK	631	177
				CONTRACT NO. 60J12
ILLINOIS FED. AID PROJECT				

S:\1072\05-CADD\01680112-Sheet\01680112-shr-twst-drawn.dwg