



**NOTES:**  
 1. ALL JUNCTION BOXES SHOWN ON THIS SHEET ARE NON-METALLIC, EMBEDDED IN STRUCTURE.

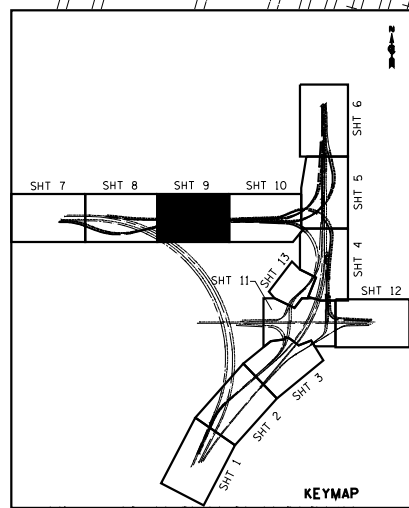

MATCHLINE "M"  
SEE SHEET 8 OF 13  
FOR CONTINUATION

MATCHLINE "N"  
SEE SHEET 10 OF 13  
FOR CONTINUATION

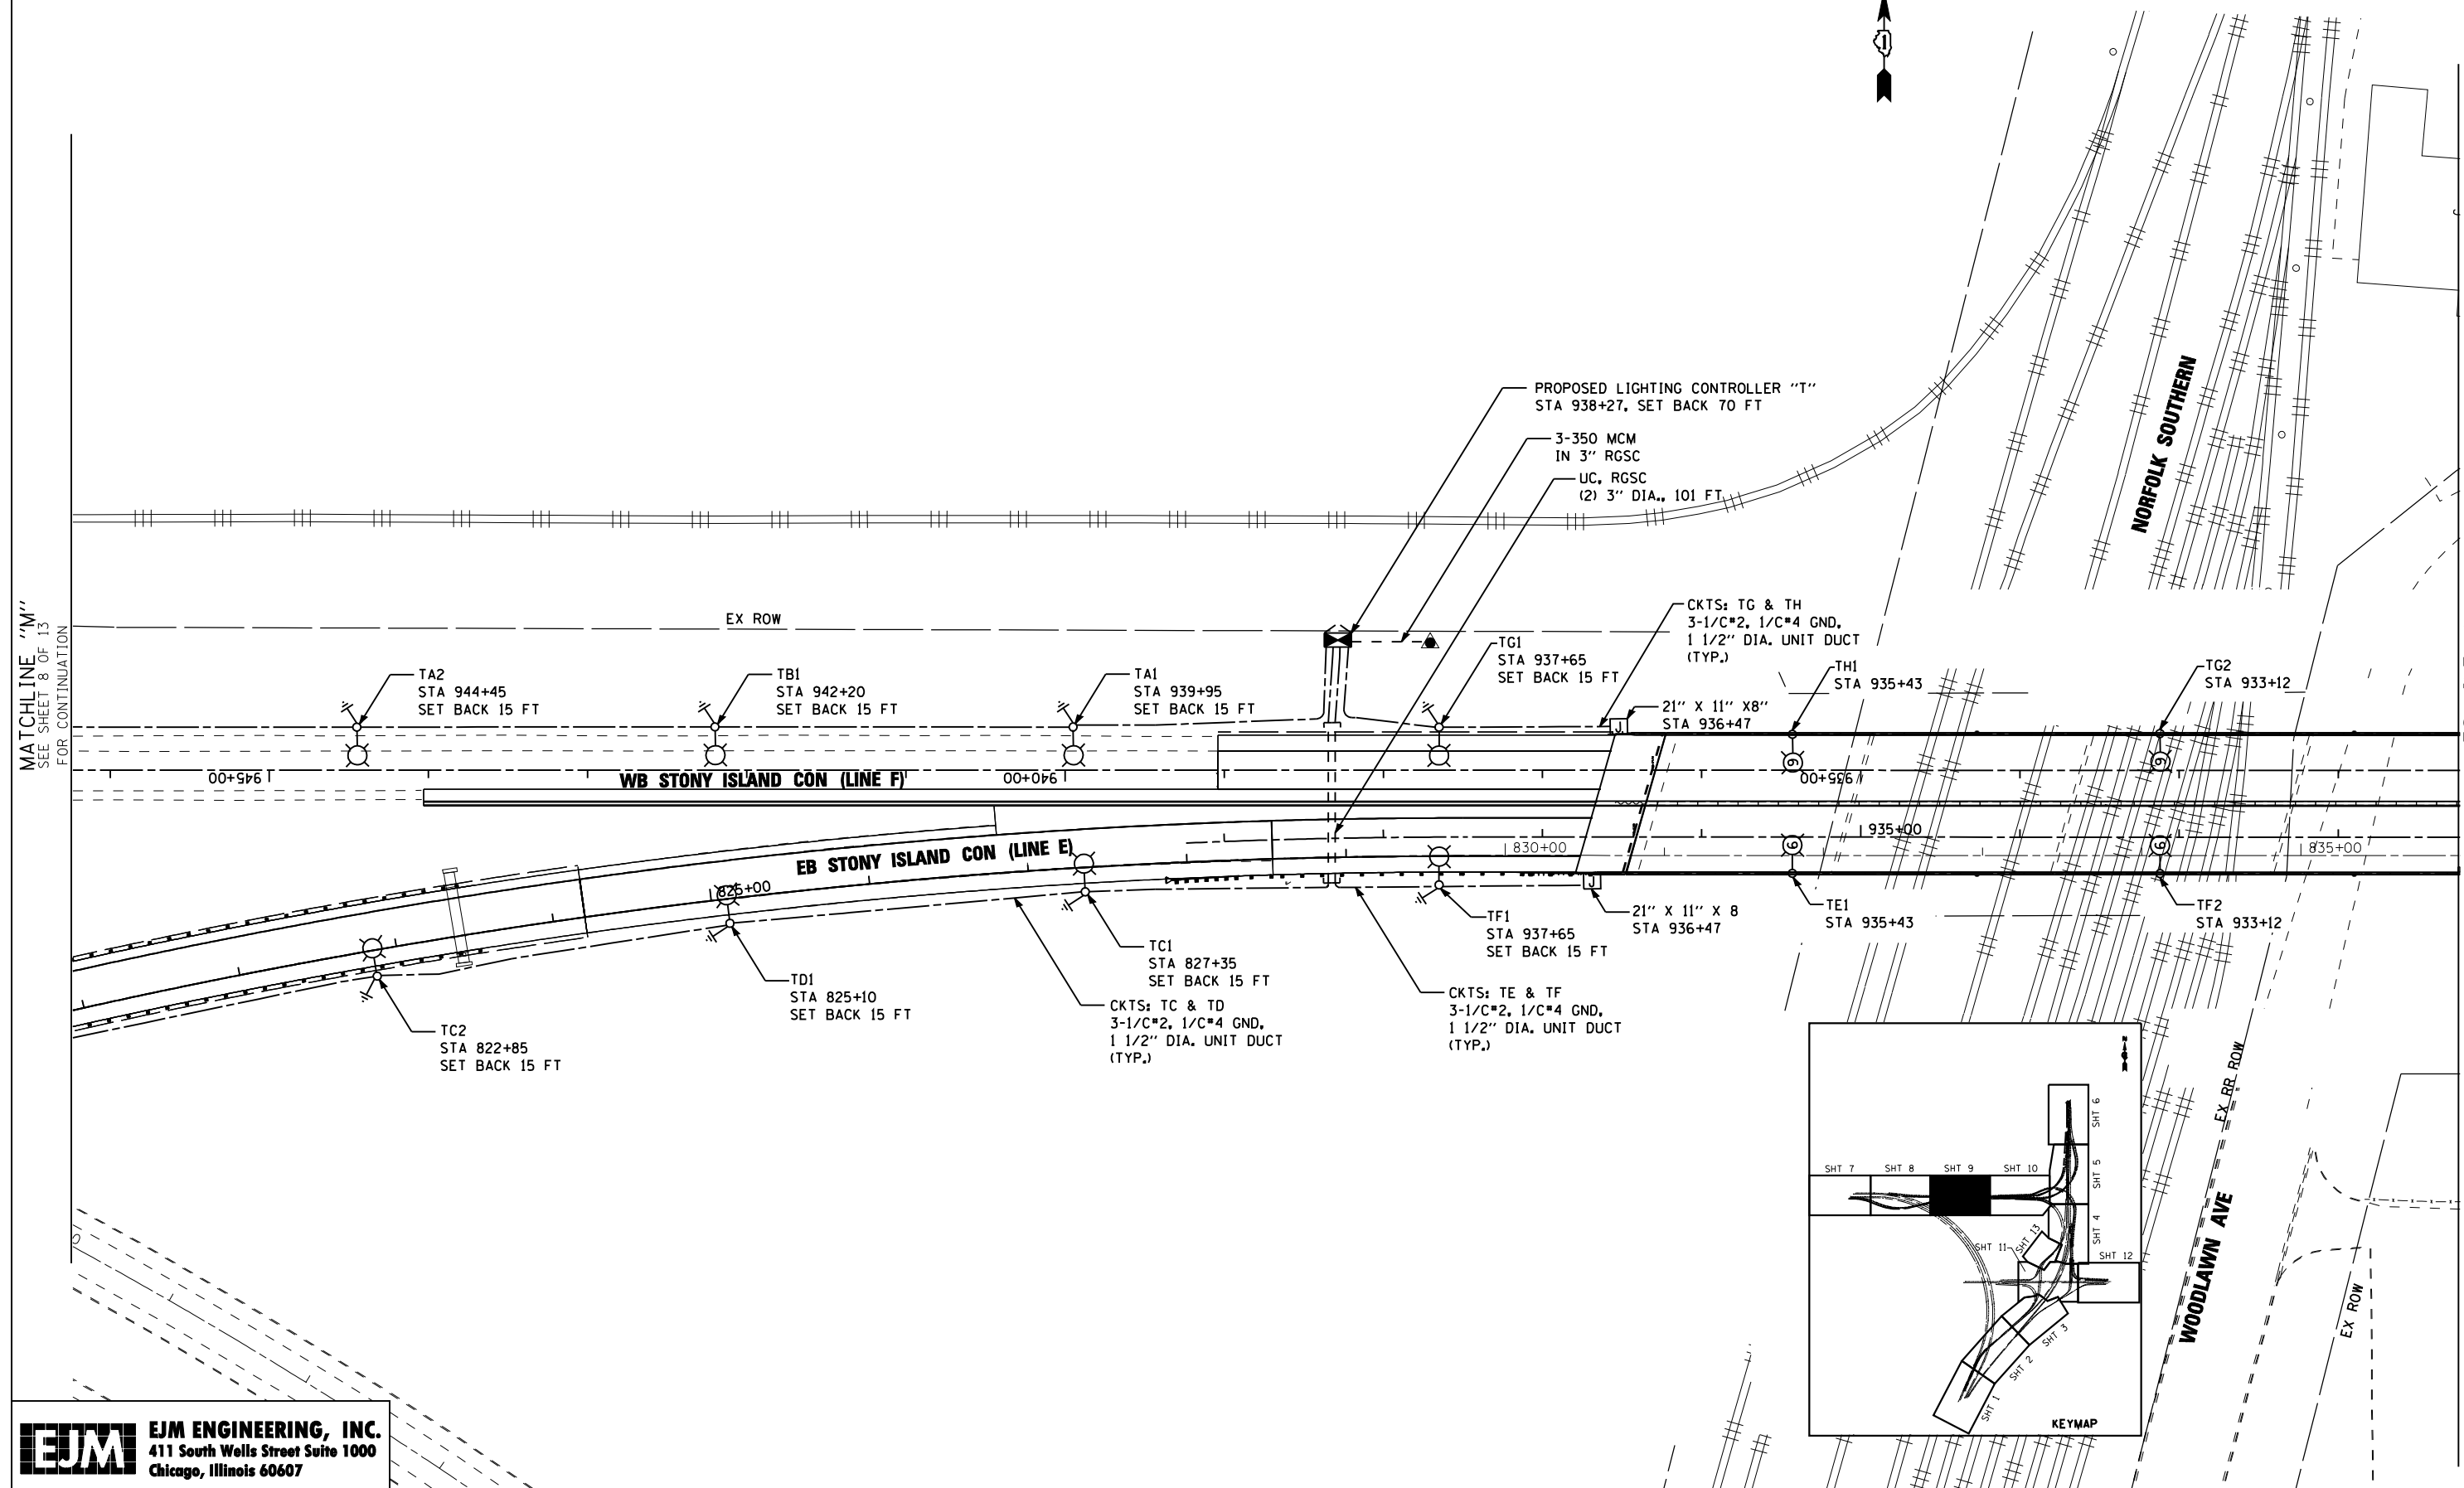

**EJM ENGINEERING, INC.**  
 411 South Wells Street Suite 1000  
 Chicago, Illinois 60607

FILE NAME :	USER NAME : rswanson	DESIGNED : JWL	REVISED :
		DRAWN : BHH	REVISED :
	PLOT SCALE = 50.000' / IN.	CHECKED : MKR	REVISED :
	PLOT DATE = 5/3/2013	DATE : 3/29/13	REVISED :

**STATE OF ILLINOIS  
 DEPARTMENT OF TRANSPORTATION**

**PROPOSED LIGHTING PLAN  
 STONY ISLAND CONNECTOR**

SCALE: 1"=50'    SHEET NO. 9 OF 13 SHEETS    STA.                    TO STA.

F.A.I. RTE.	SECTION	COUNTY	TOTAL SHEETS	SHEET NO.
94	2012-059-BR	COOK	631	301
CONTRACT NO. 60J12			ILLINOIS FED. AID PROJECT	

LT-23

S:\Projects\3810 Stony Island Feeder - BBA\Project - Work\CADD Sheets\1168012-akt-light-23.dgn