



TYPICAL SPLICE DETAIL

N.T.S.

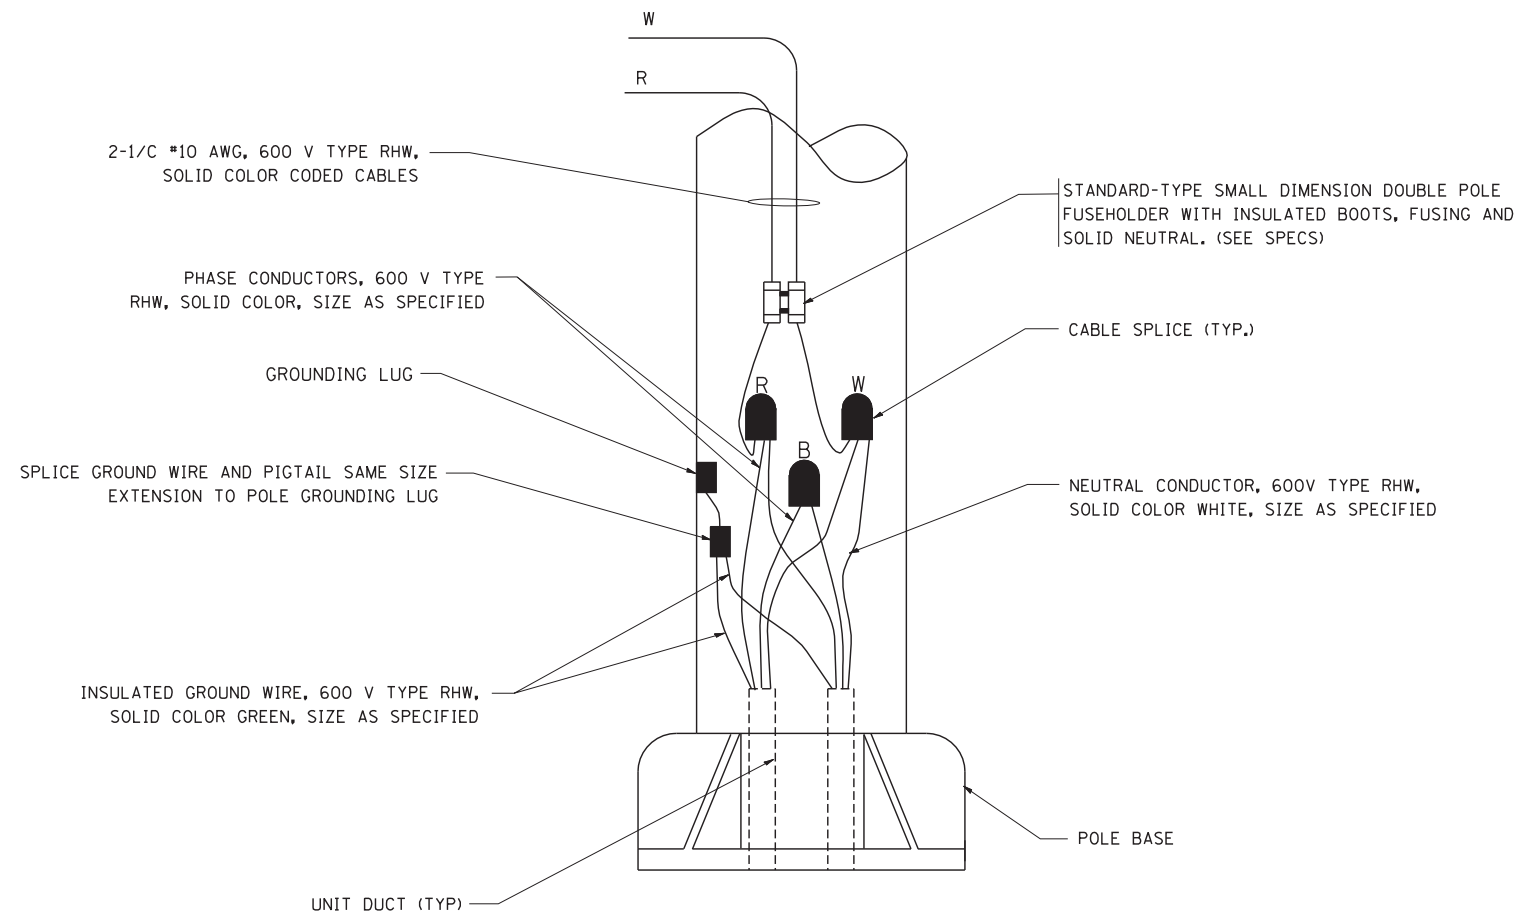

POLE WIRING DETAIL

N.T.S.

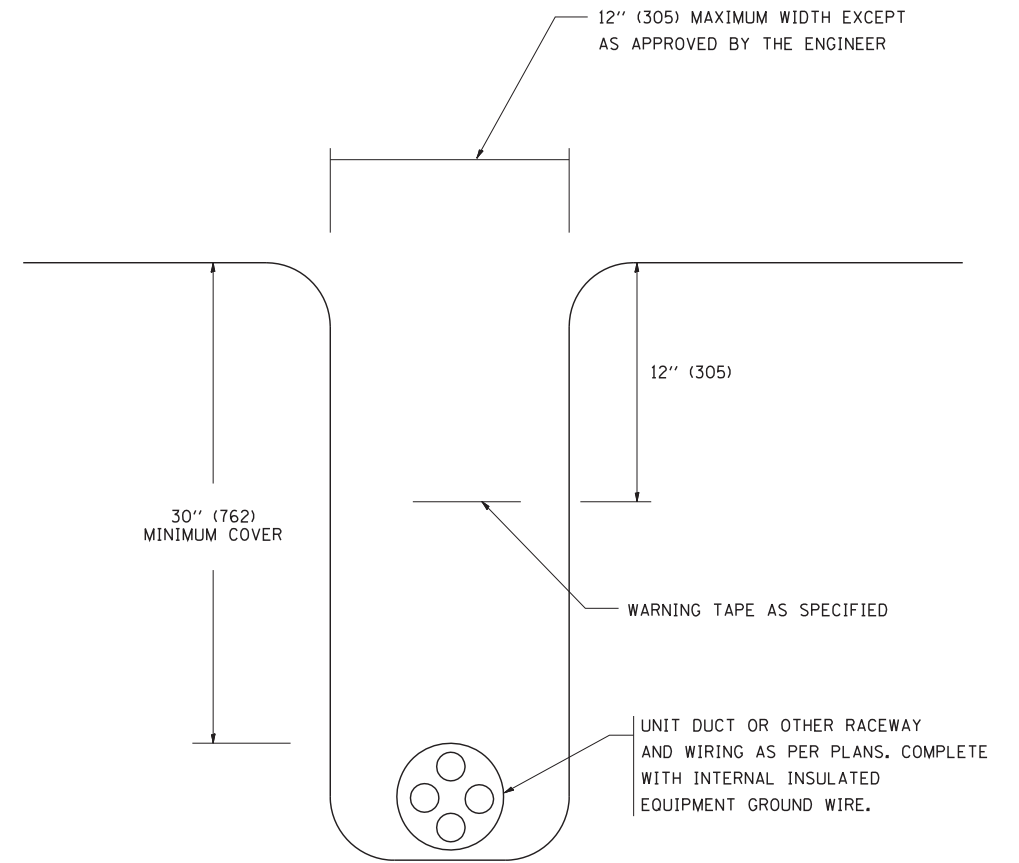

TYPICAL WIRING IN TRENCH DETAIL

N.T.S.

FILE NAME =	USER NAME = gaglionobt
W:\diststd\22x34\be702.dgn	

DESIGNED -	REVISD - 08-08-03
DRAWN -	REVISD -
PLOT SCALE = 50.000' / IN.	CHECKED -
PLOT DATE = 1/4/2008	DATE -

DESIGNED -	REVISD - 08-08-03
DRAWN -	REVISD -
CHECKED -	REVISD -
DATE -	REVISD -

DESIGNED -	REVISD - 08-08-03
DRAWN -	REVISD -
CHECKED -	REVISD -
DATE -	REVISD -

**STATE OF ILLINOIS
DEPARTMENT OF TRANSPORTATION**

MISC. ELECTRICAL DETAILS SHEET A			
SCALE: NONE	SHEET NO. 1 OF 1 SHEETS	STA.	TO STA.

F.A. RTE.	SECTION	COUNTY	TOTAL SHEETS	SHEET NO.
	2012-059-BR	COOK	631	323
BE-702		CONTRACT NO. 60J12		
FED. ROAD DIST. NO. 1 ILLINOIS FED. AID PROJECT				