



F.A.I. RTE.	SECTION	COUNTY	TOTAL SHEETS	SHEET NO.
55	99 (1&2) WRS-2	WILL.	228	118
STA.		TO STA.		
FED. ROAD DIST. NO.		ILLINOIS FED. AID PROJECT		

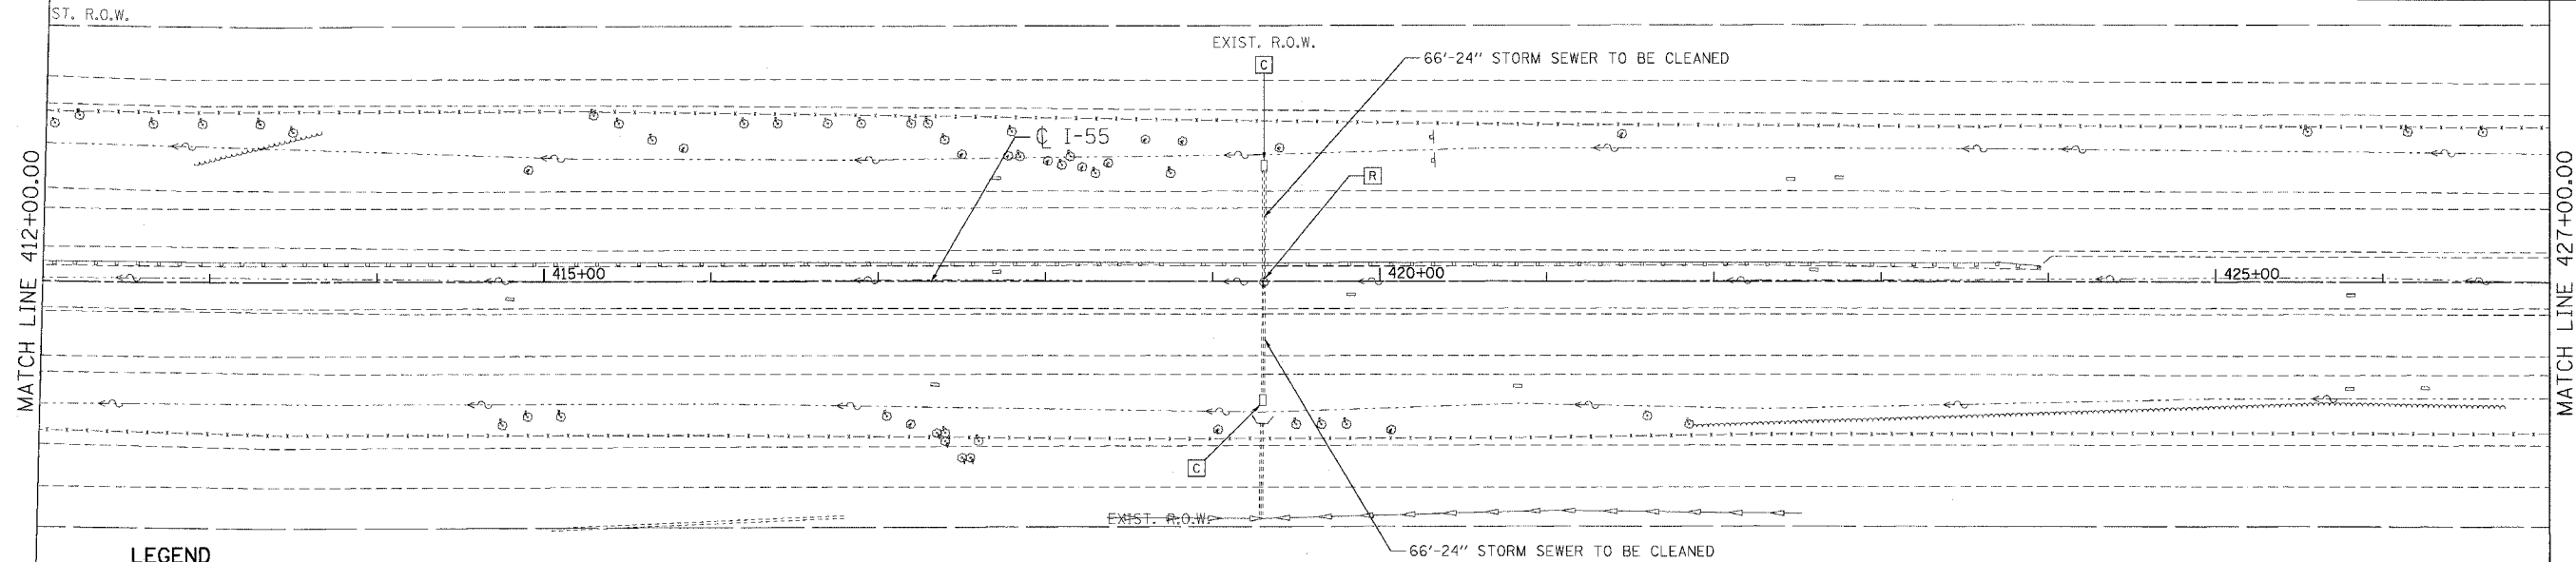

LEGEND

- ////// PIPE REMOVAL
- [R] STRUCTURES TO BE REMOVED
- [C] STRUCTURES TO BE CLEANED

EXISTING PLAN

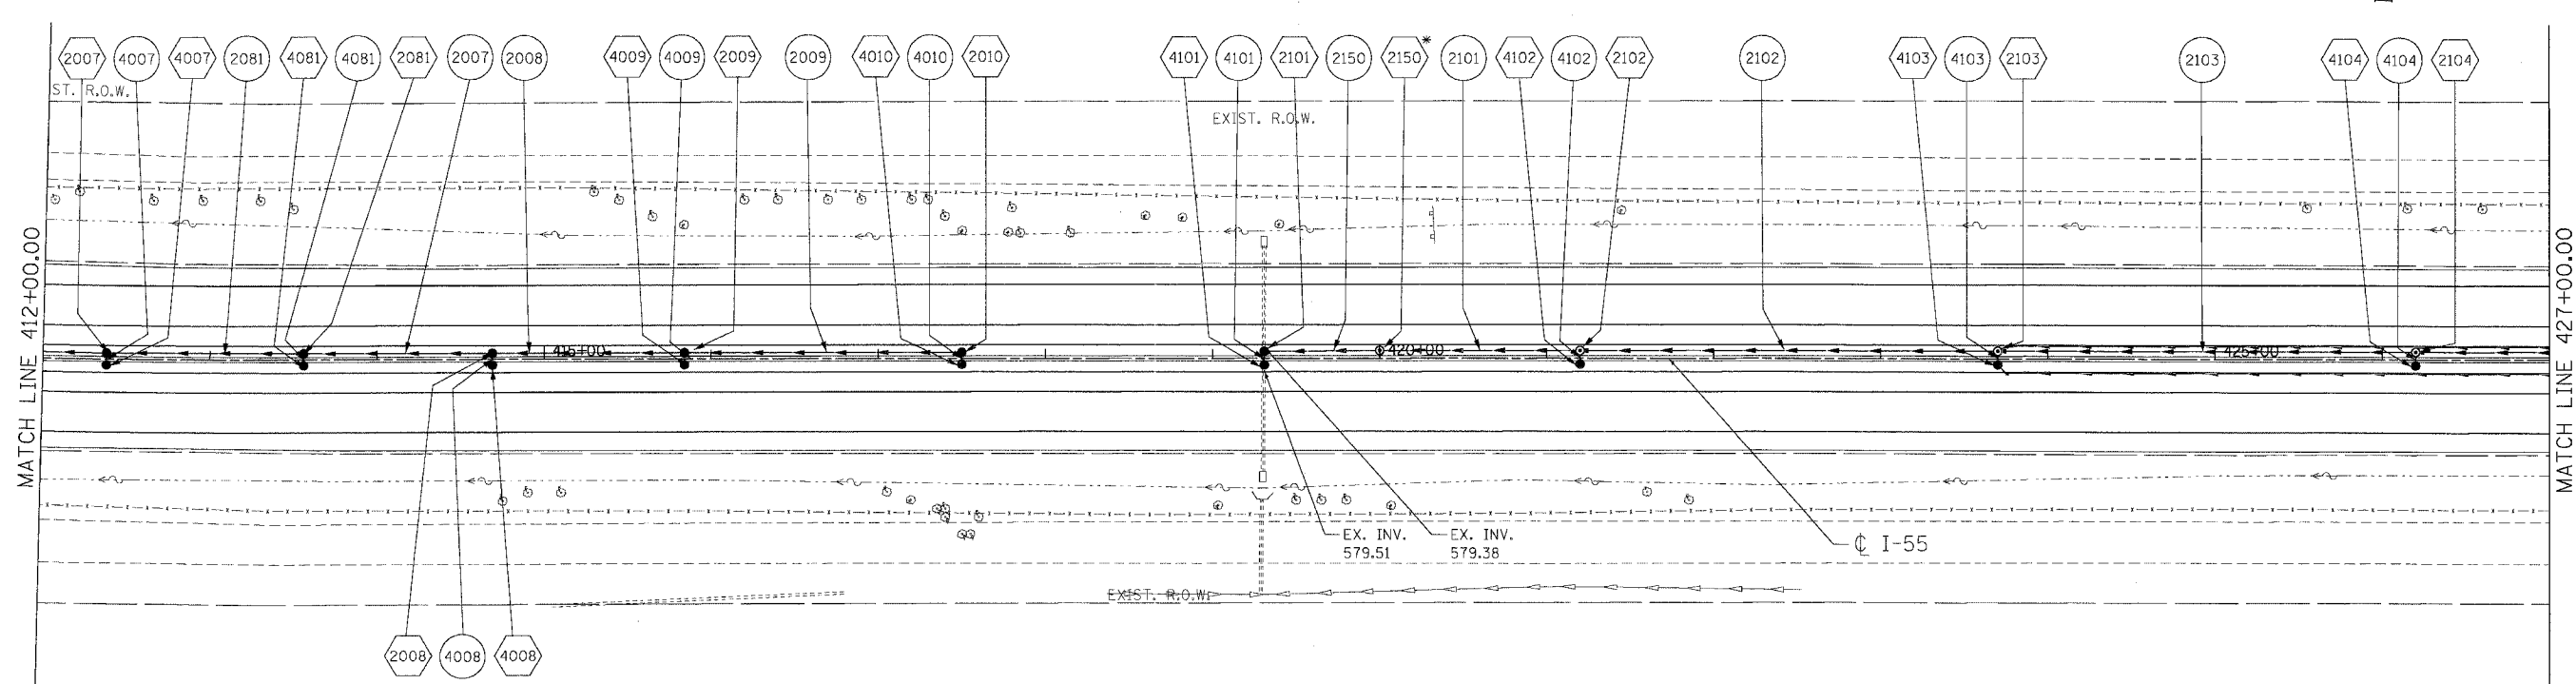

LEGEND

- (1001) STRUCTURE NUMBER
- (1001) GRATING FOR STRUCTURE
- (1001) PIPE NUMBER
- STORM SEWER
- CATCH BASIN
- MANHOLE
- ◄ FLARED END SECTION
- ⌒ HEADWALL
- PIPE UNDERDRAINS

NOTES

1. FOR STRUCTURE AND PIPE INFORMATION SEE DRAINAGE SCHEDULES, SHEETS 129, 130, 131, 132, AND 133.
 2. PROPOSED SEWER AND CULVERT CROSSING BENEATH THE EXISTING PAVEMENT SHALL BE CONSTRUCTED DURING PRE-STAGE PER THE STAGING AND TRAFFIC CONTROL PLANS. SEE ROADWAY PLANS FOR PATCHING DETAILS.

(2150)* DRAINAGE STRUCTURE WITH RESTRICTOR. FOR DETAILS SEE SHEET 143.

PROPOSED PLAN

REVISIONS	
NAME	DATE

ILLINOIS DEPARTMENT OF TRANSPORTATION
 FAI ROUTE 55 (BLACK ROAD TO U.S. 30)
 WIDENING AND RESURFACING

DRAINAGE AND UTILITY PLAN
FAI 55
STA. 412+00.00 TO STA. 427+00.00

SCALE: 1"=50'
 DATE 03/15/07
 DRAWN BY MRK
 CHECKED BY TKL

TENG
 TENG & ASSOCIATES, INC.
 ENGINEERS/ARCHITECTS/PLANNERS
 CHICAGO, ILLINOIS

PLOT DATE = 03/15/07
 FILE NAME = 03/15/07
 PLOT SCALE = 1"=50'
 USER NAME = TENG