


F.A.I. RTE.	SECTION	COUNTY	TOTAL SHEETS	SHEET NO.
55	99 (1&2) WRS-2	WILL	228	124
STA.		TO STA.		
FED. ROAD DIST. NO.		ILLINOIS FED. AID PROJECT		

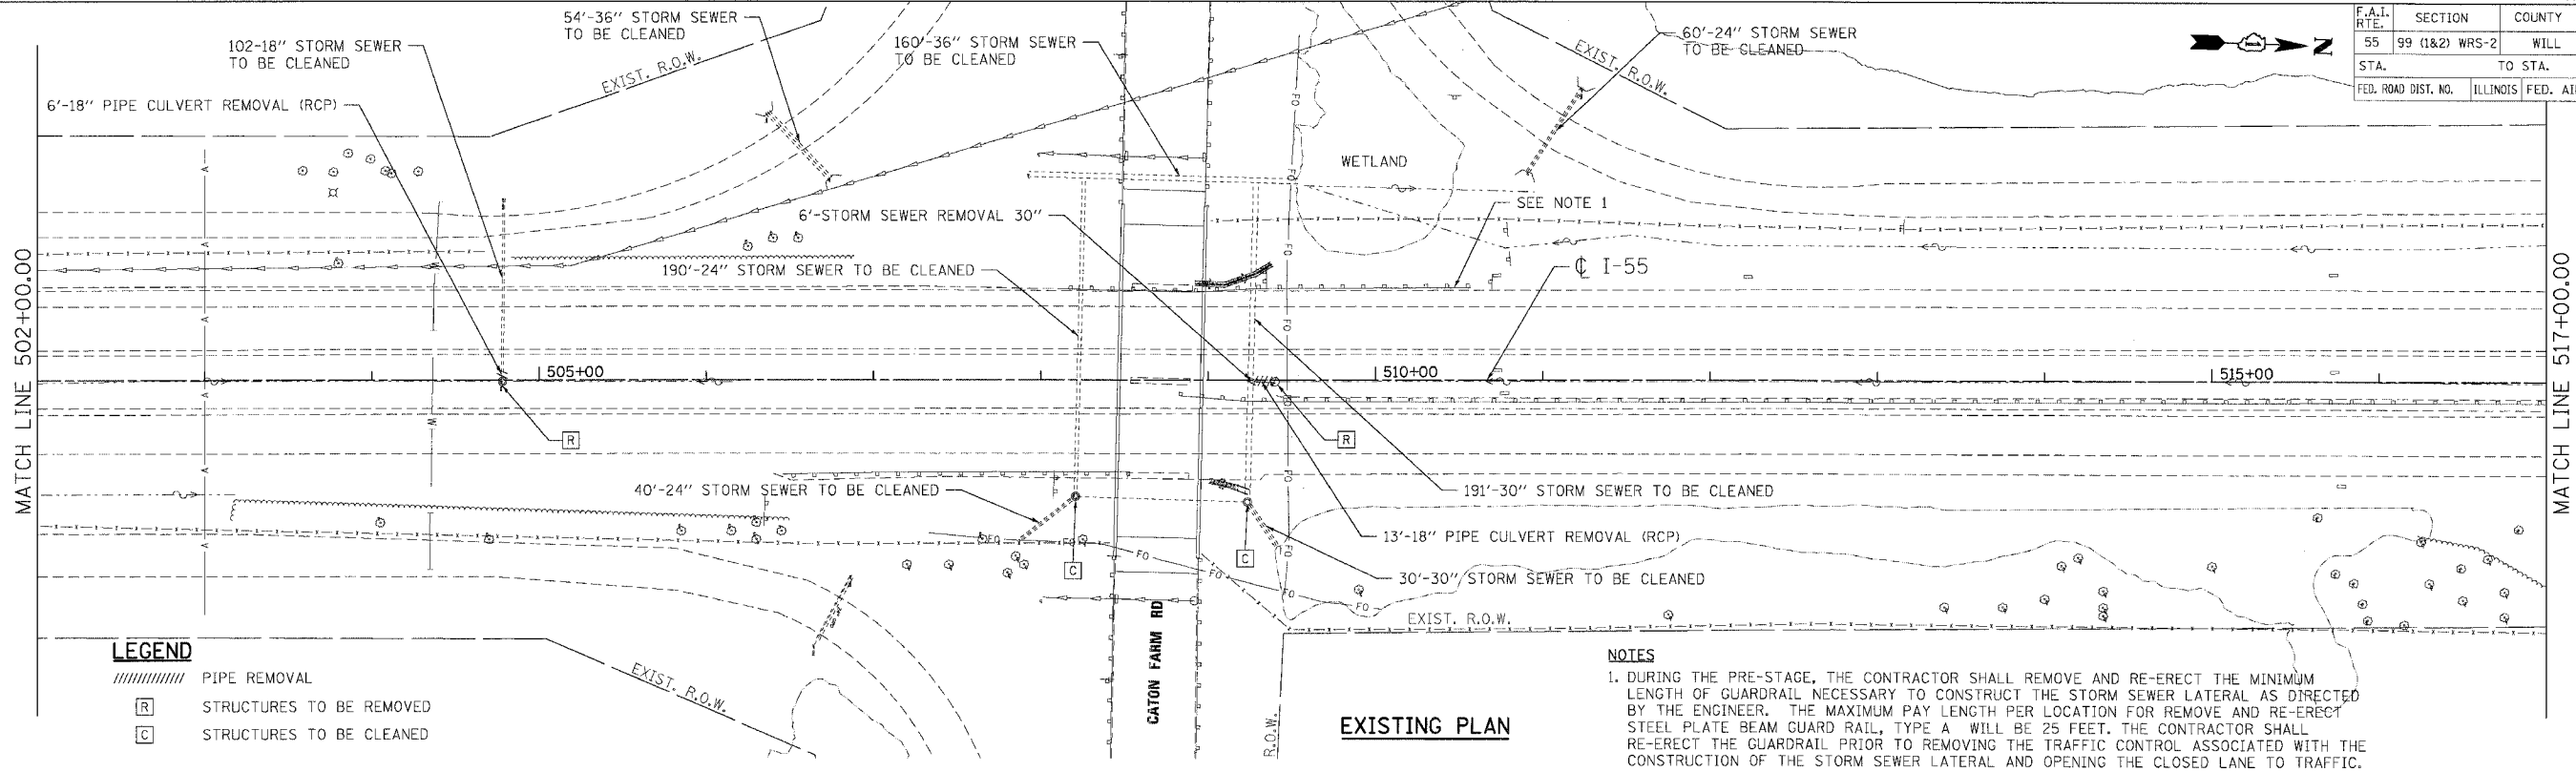


LEGEND

////	PIPE REMOVAL
[R]	STRUCTURES TO BE REMOVED
[C]	STRUCTURES TO BE CLEANED

NOTES

1. DURING THE PRE-STAGE, THE CONTRACTOR SHALL REMOVE AND RE-ERECT THE MINIMUM LENGTH OF GUARDRAIL NECESSARY TO CONSTRUCT THE STORM SEWER LATERAL AS DIRECTED BY THE ENGINEER. THE MAXIMUM PAY LENGTH PER LOCATION FOR REMOVE AND RE-ERECT STEEL PLATE BEAM GUARD RAIL, TYPE A WILL BE 25 FEET. THE CONTRACTOR SHALL RE-ERECT THE GUARDRAIL PRIOR TO REMOVING THE TRAFFIC CONTROL ASSOCIATED WITH THE CONSTRUCTION OF THE STORM SEWER LATERAL AND OPENING THE CLOSED LANE TO TRAFFIC.

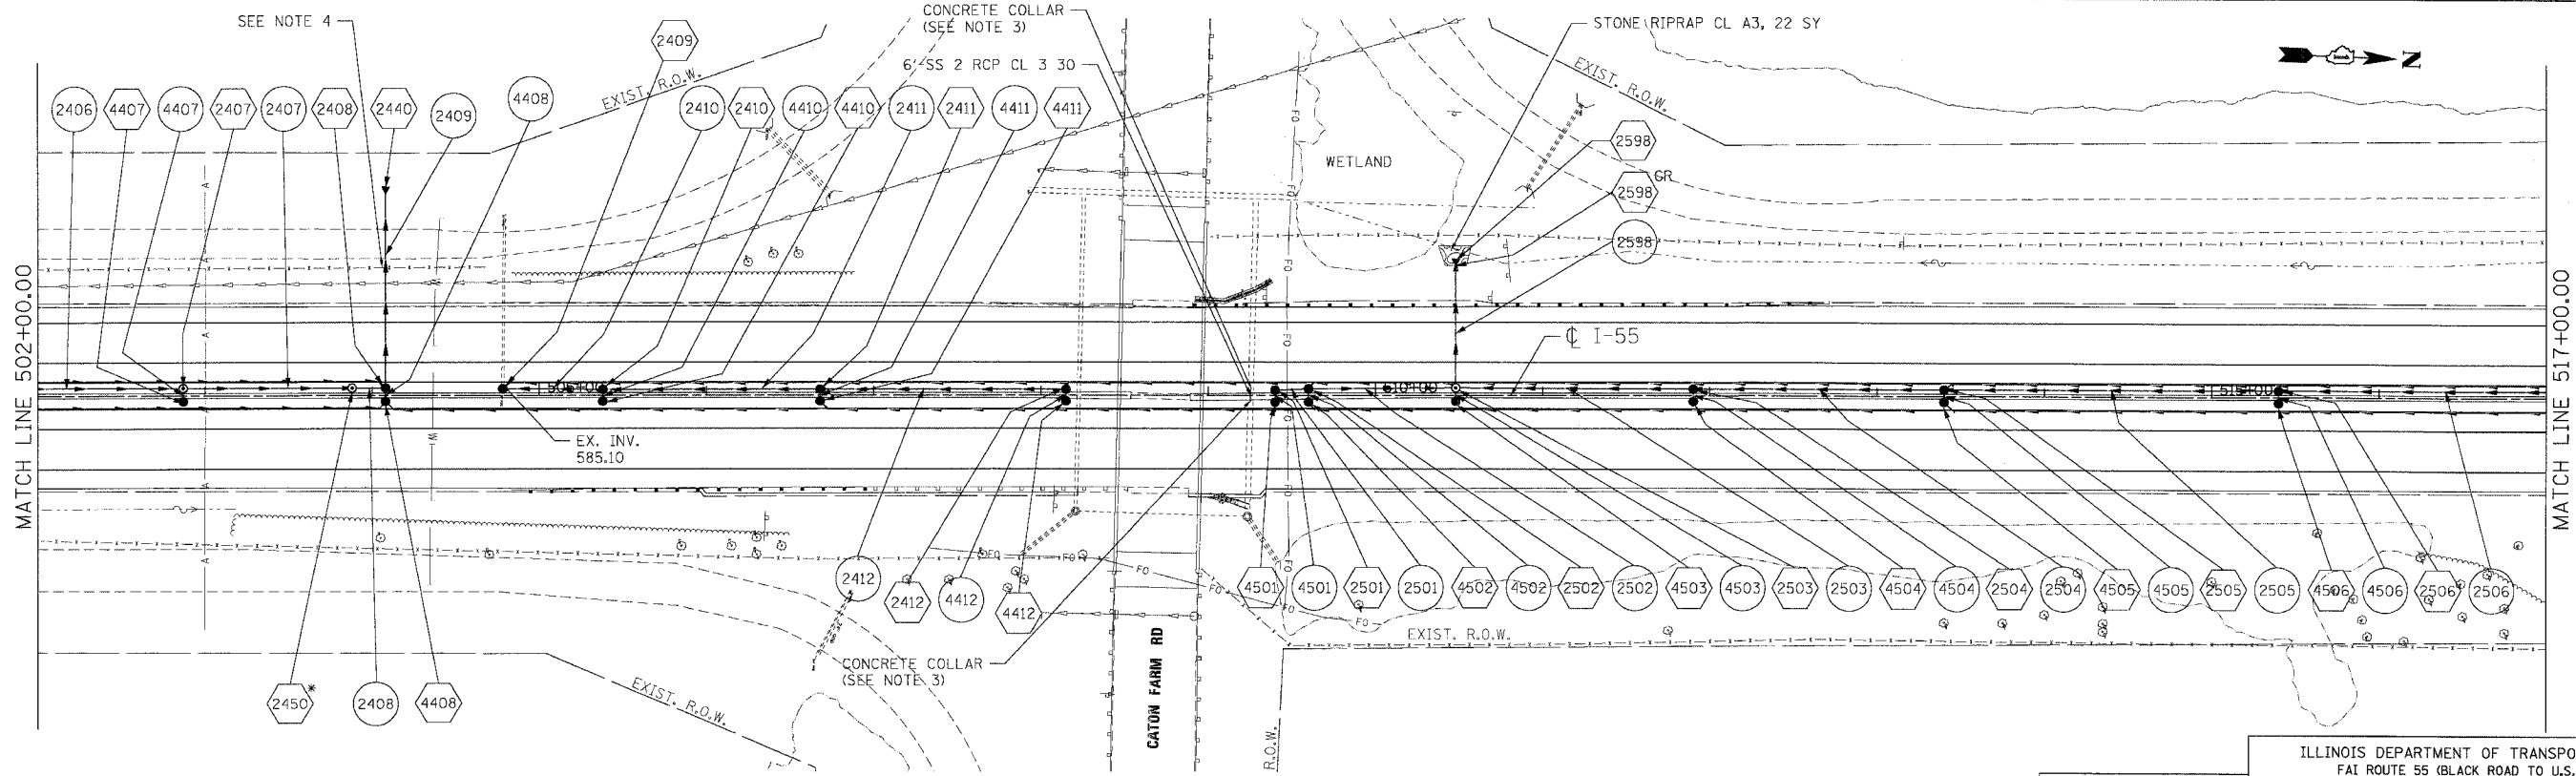

LEGEND

(1001)	STRUCTURE NUMBER	●	CATCH BASIN
(1001)GR	GRATING FOR STRUCTURE	○	MANHOLE
(1001)	PIPE NUMBER	▲	FLARED END SECTION
—	STORM SEWER	—	HEADWALL
- - -		- - -	PIPE UNDERDRAINS

NOTES

1. FOR STRUCTURE AND PIPE INFORMATION SEE DRAINAGE SCHEDULES, SHEETS 129, 130, 131, 132, AND 133.

2. PROPOSED SEWER AND CULVERT CROSSING BENEATH THE EXISTING PAVEMENT SHALL BE CONSTRUCTED DURING PRE-STAGE PER THE STAGING AND TRAFFIC CONTROL PLANS. SEE ROADWAY PLANS FOR PATCHING DETAILS.

3. SEE DISTRICT 1 DETAIL BD-7 FOR CONCRETE COLLAR DETAILS.

4. THE CONTRACTOR SHALL REMOVE AND RESTORE THE FENCE WHERE NECESSARY AT THE PROPOSED STORM SEWER TO THE SATISFACTION OF THE ENGINEER AND THE COST SHALL BE INCLUDED IN THE CONTRACT UNIT PRICE FOR STORM SEWER OF TYPE, SIZE AND CLASS SPECIFIED.

(2450)* DRAINAGE STRUCTURE WITH RESTRICTOR. FOR DETAILS SEE SHEET 143.

PROPOSED PLAN

REVISIONS	
NAME	DATE

ILLINOIS DEPARTMENT OF TRANSPORTATION
 FAI ROUTE 55 (BLACK ROAD TO U.S. 30)
 WIDENING AND RESURFACING

**DRAINAGE AND UTILITY PLAN
 FAI 55
 STA. 502+00.00 TO STA. 517+00.00**

SCALE: 1"=50'
 DATE 03/15/07

DRAWN BY MRK
 CHECKED BY TKL

TENG
 TENG & ASSOCIATES, INC.
 ENGINEERS/ARCHITECTS/PLANNERS
 CHICAGO, ILLINOIS

PLOT DATE = 04/24/07
 FILE NAME = 031507.DWG
 PLOT SCALE = 1"=50'
 USER NAME = J15878
 PLOT DATE = 04/24/07
 FILE NAME = 031507.DWG
 PLOT SCALE = 1"=50'
 USER NAME = J15878