



*REF-drain05
*REF-drain06

CONTRACT NO. 62719

F.A.P. RTE.	SECTION	COUNTY	TOTAL SHEETS	SHEET NO.
344	3034N-1	COOK	71	15
STA.		TO STA.		
FED. ROAD DIST. NO.		ILLINOIS FED. AID PROJECT		

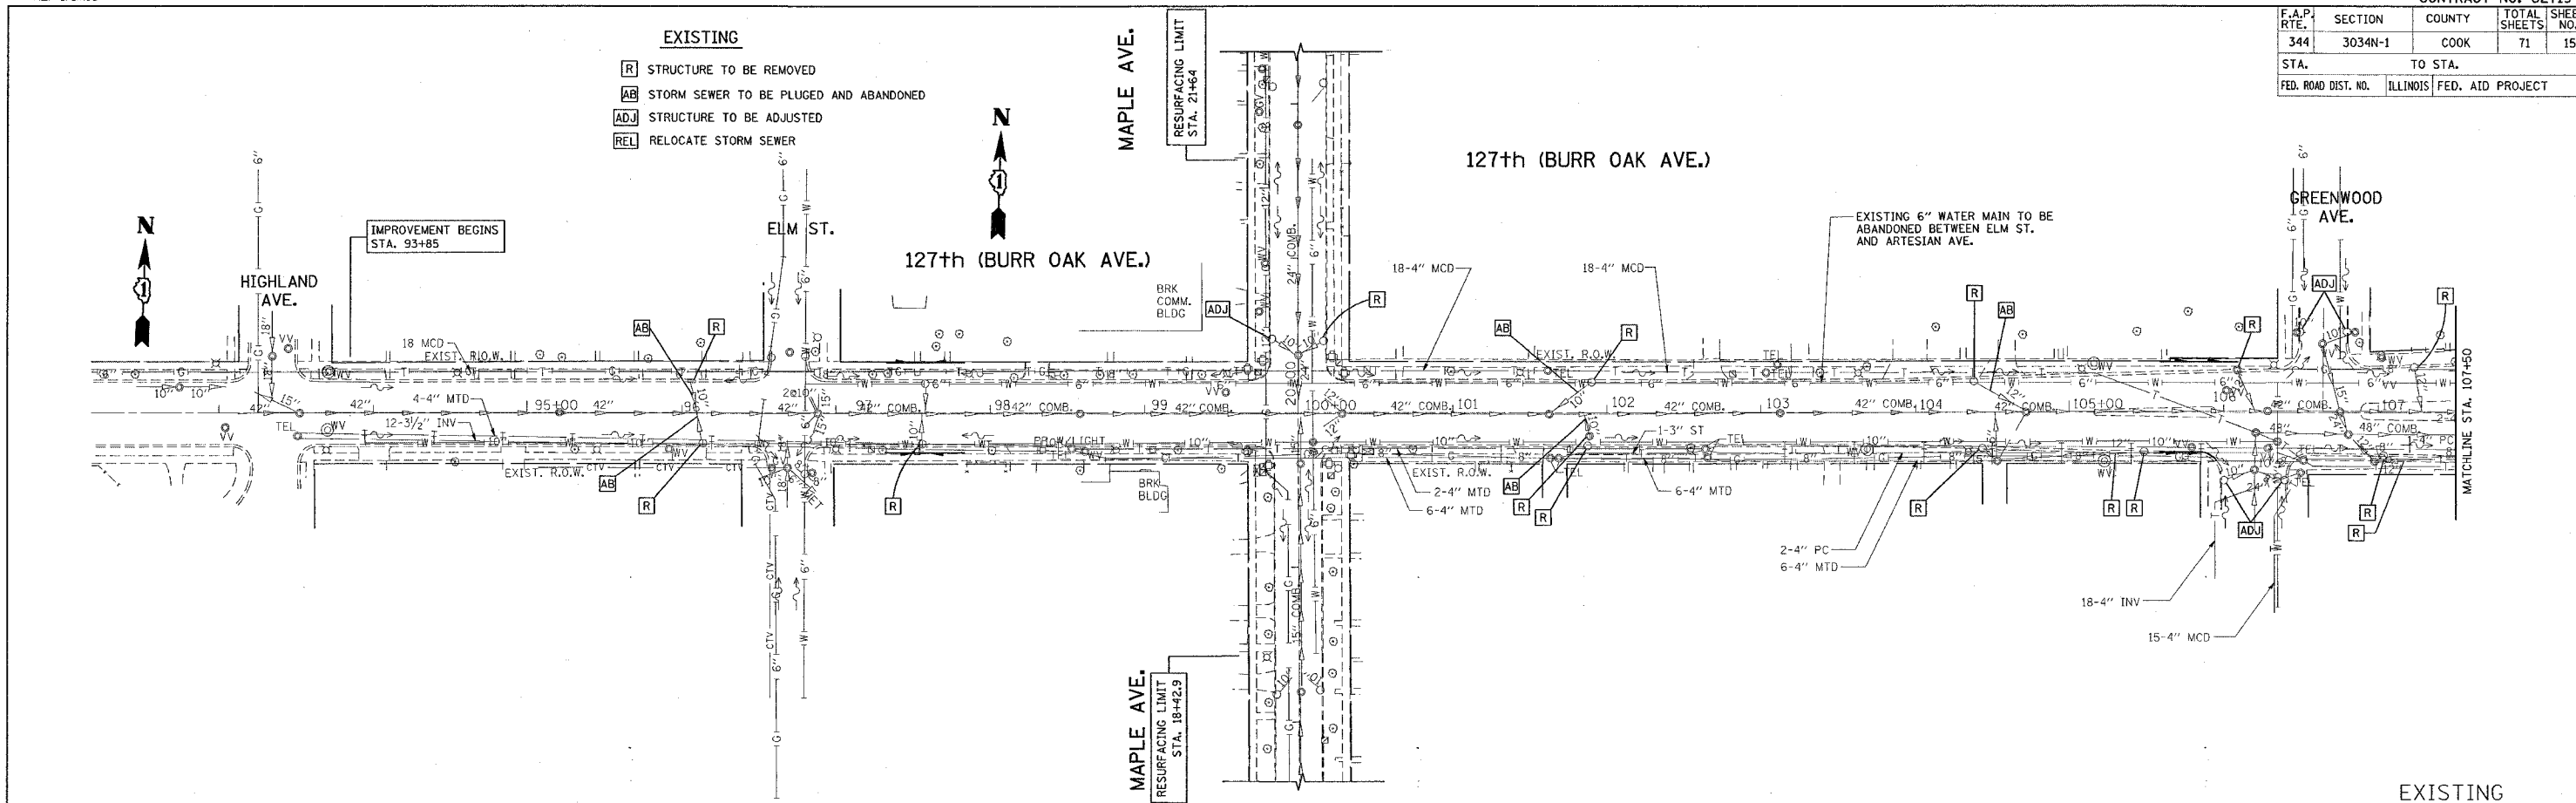

EXISTING

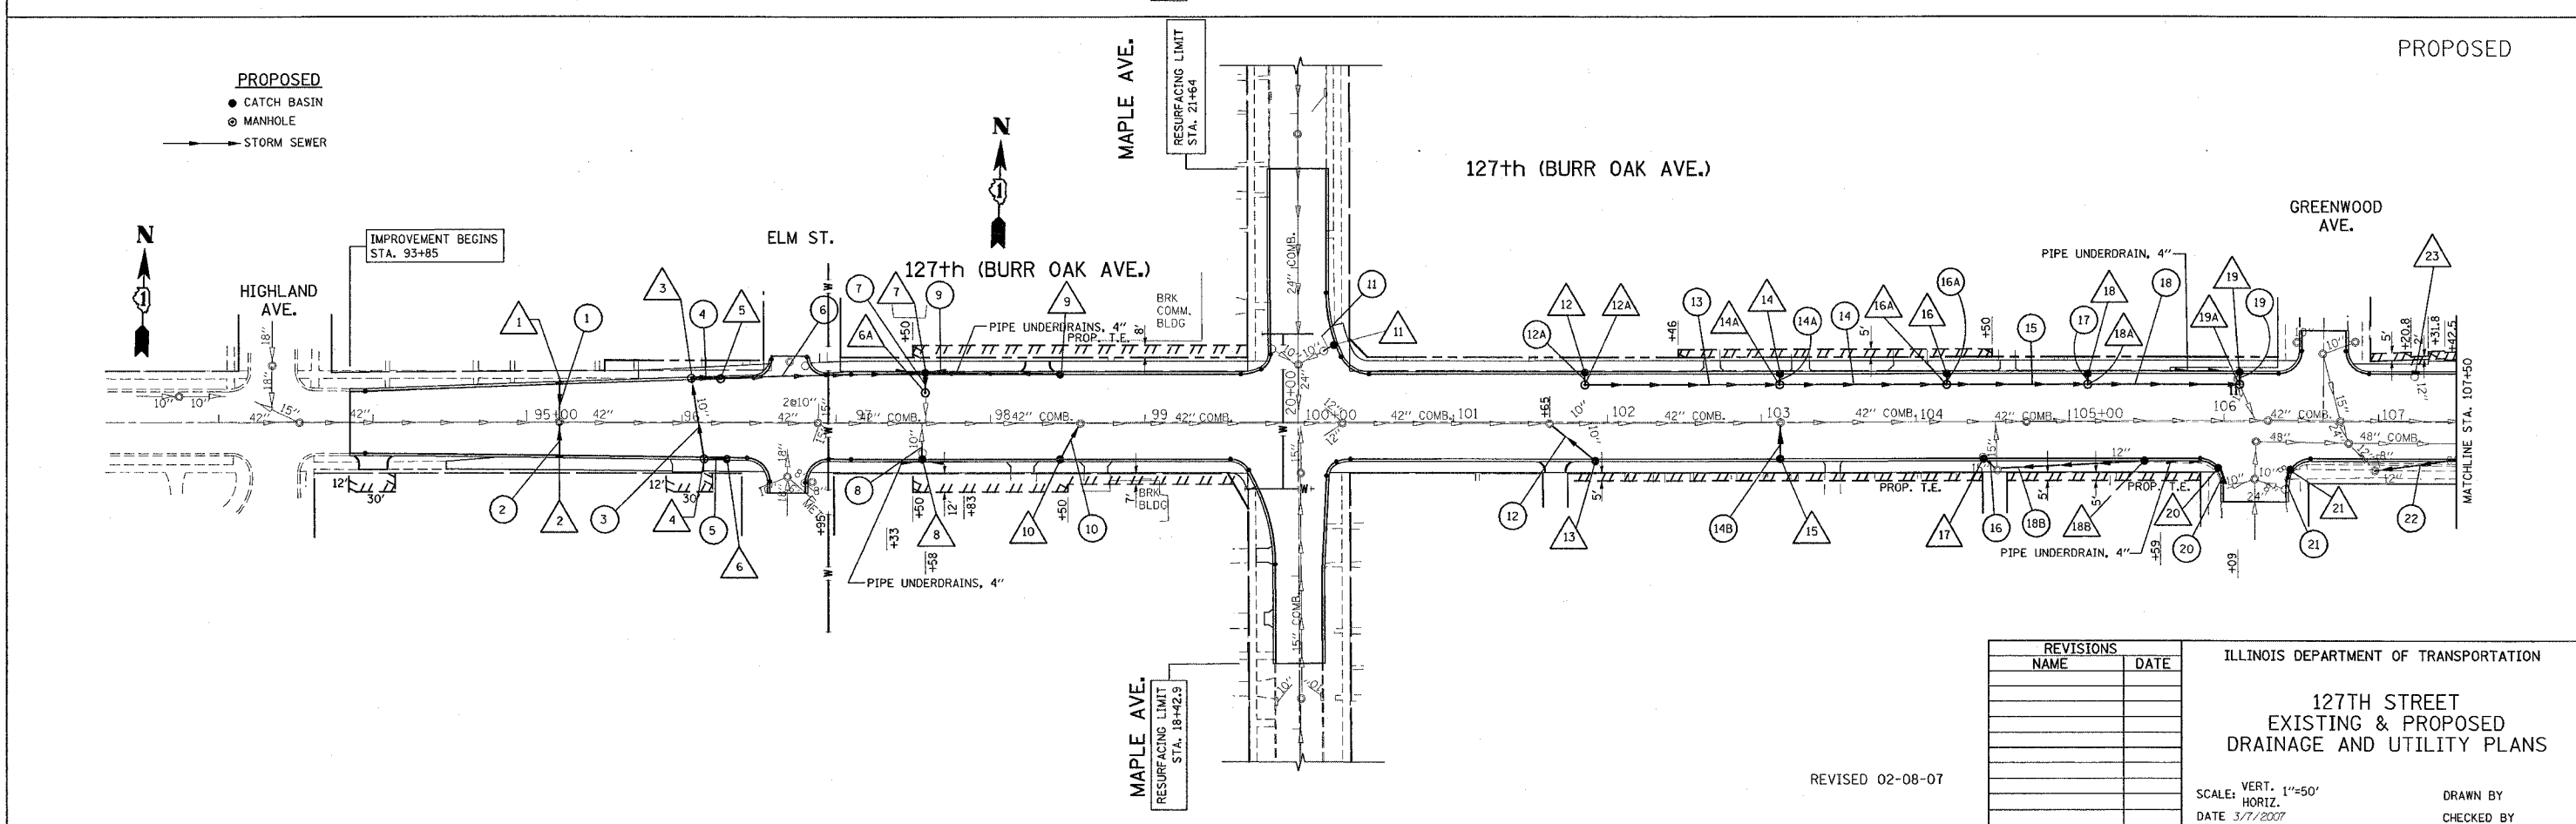

PROPOSED

PLOT DATE = 3/7/2007
FILE NAME = c:\projects\108403\sh.drain.dgn
USER NAME = druckoski

REVISED 02-08-07

REVISIONS	
NAME	DATE

ILLINOIS DEPARTMENT OF TRANSPORTATION

127TH STREET
EXISTING & PROPOSED
DRAINAGE AND UTILITY PLANS

SCALE: VERT. 1"=50'
HORIZ.
DATE 3/7/2007

DRAWN BY
CHECKED BY