


*REF-drain05-1
*REF-drain06-1

CONTRACT NO. 62719

F.A.P. RTE.	SECTION	COUNTY	TOTAL SHEETS	SHEET NO.
344	3034N-1	COOK	71	16
STA. 107+50		TO STA. 110+07.8		
FED. ROAD DIST. NO.		ILLINOIS FED. AID PROJECT		

EXISTING


- [R] STRUCTURE TO BE REMOVED
- [AB] STORM SEWER TO BE PLUGGED AND ABANDONED
- [ADJ] STRUCTURE TO BE ADJUSTED
- [REL] RELOCATE STORM SEWER

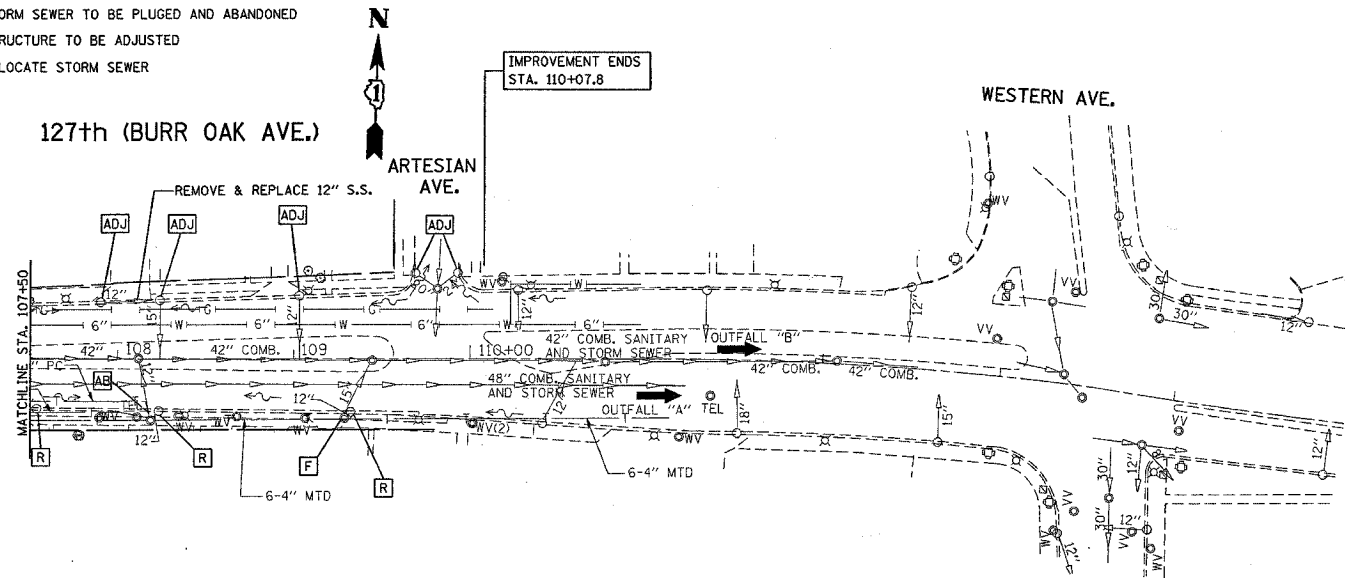

EXISTING

PROPOSED

- PROPOSED**
- CATCH BASIN
 - ⊙ MANHOLE
 - STORM SEWER

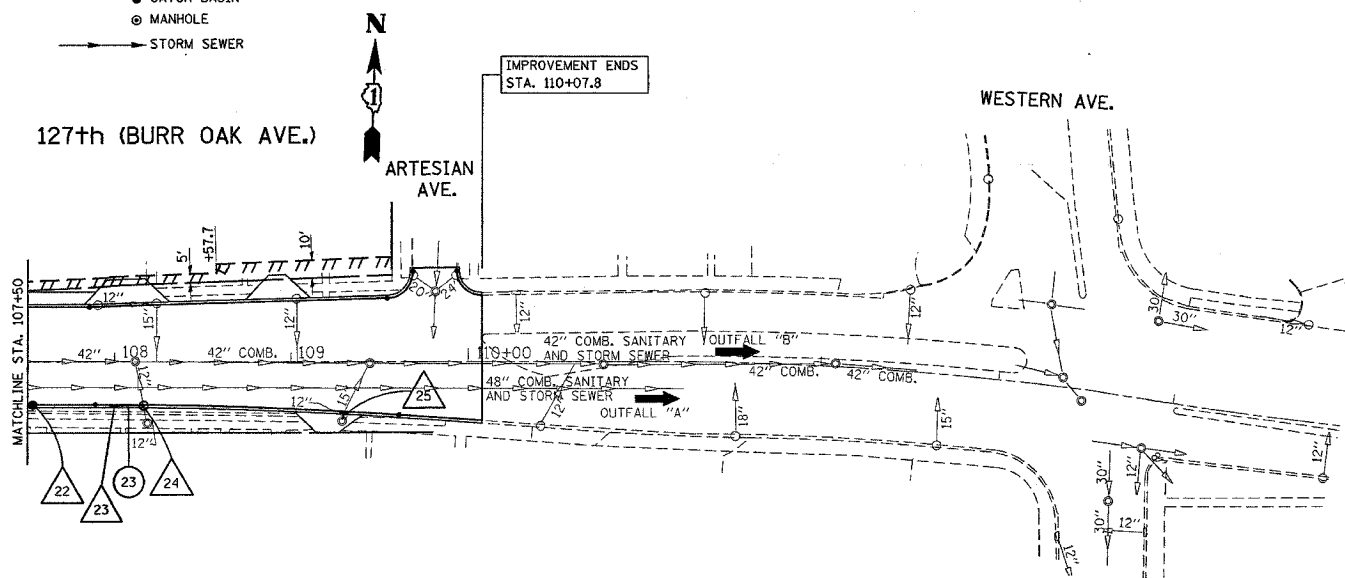

REVISIONS	
NAME	DATE

ILLINOIS DEPARTMENT OF TRANSPORTATION

**127TH STREET
EXISTING & PROPOSED
DRAINAGE AND UTILITY PLANS**

SCALE: VERT. 1"=50'
HORIZ. 1"=50'
DATE 1/3/2007

DRAWN BY
CHECKED BY

PLOT DATE = 1/3/2007
FILE NAME = c:\p\proj\10750\10750.dwg
PLOT SCALE = 1/8"=1'-0"
USER NAME = jrvkcsn