




F.A.P. RTE.	SECTION	COUNTY	TOTAL SHEETS	SHEET NO.
326	106-N-1	KANE	82	58
STA.		TO STA.		
FED. ROAD DIST. NO. 1 ILLINOIS FED. AID PROJECT				

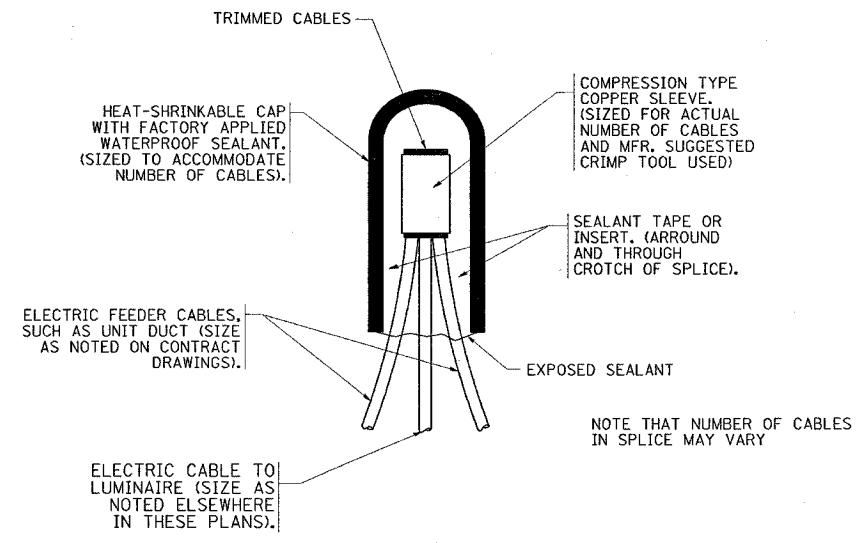

TYPICAL SPLICE DETAIL
N.T.S.

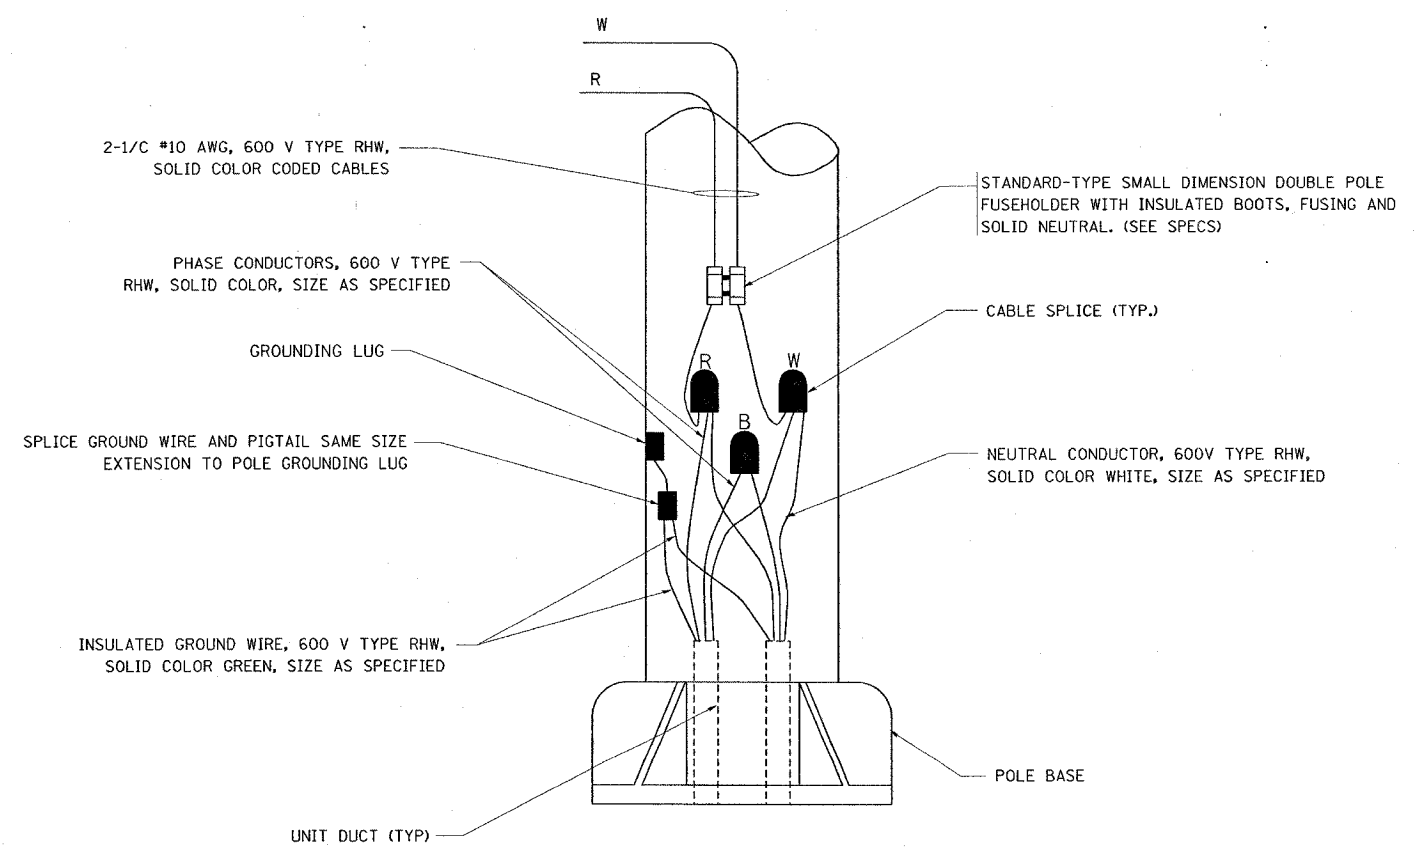

POLE WIRING DETAIL
N.T.S.

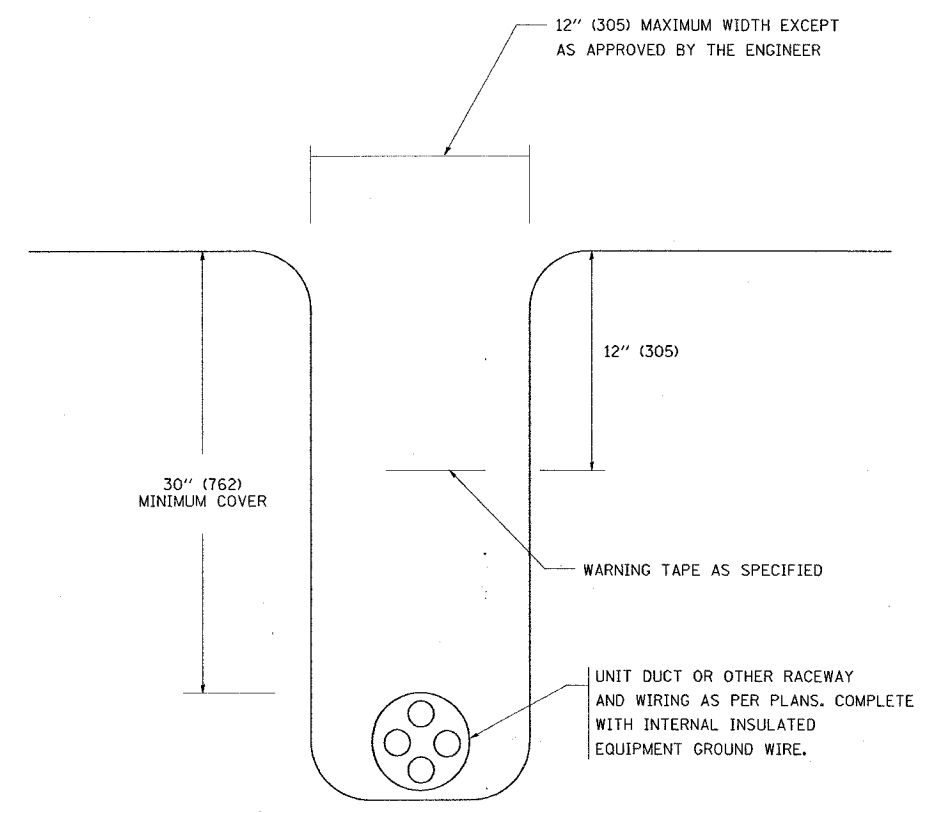

TYPICAL WIRING IN TRENCH DETAIL
N.T.S.

PLOT DATE = 2/14/2007
FILE NAME = s:\data\std\ba792.dgn
JOB NO. = 50000 / 3N
USER NAME = rlg\mrcp

REVISIONS	
NAME	DATE

ILLINOIS DEPARTMENT OF TRANSPORTATION

MISC. ELECTRICAL DETAILS
SHEET A

SCALE: VERT.
HORIZ.
DATE: 2/14/2007

DRAWN BY
CHECKED BY
BE-702
REVISION DATE: 01/01/07