




F.A. RTE.	SECTION	COUNTY	TOTAL SHEETS	SHEET NO.
55	99 (112) WRS	WILL	334	272
STA.	TO STA.			
FED. ROAD DIST. NO.	ILLINOIS FED. AID PROJECT			

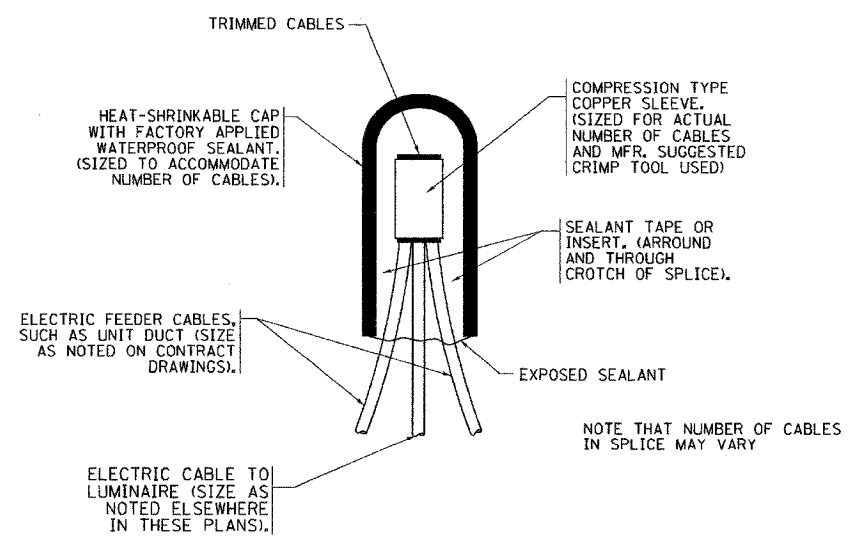

TYPICAL SPLICE DETAIL  
N.T.S.

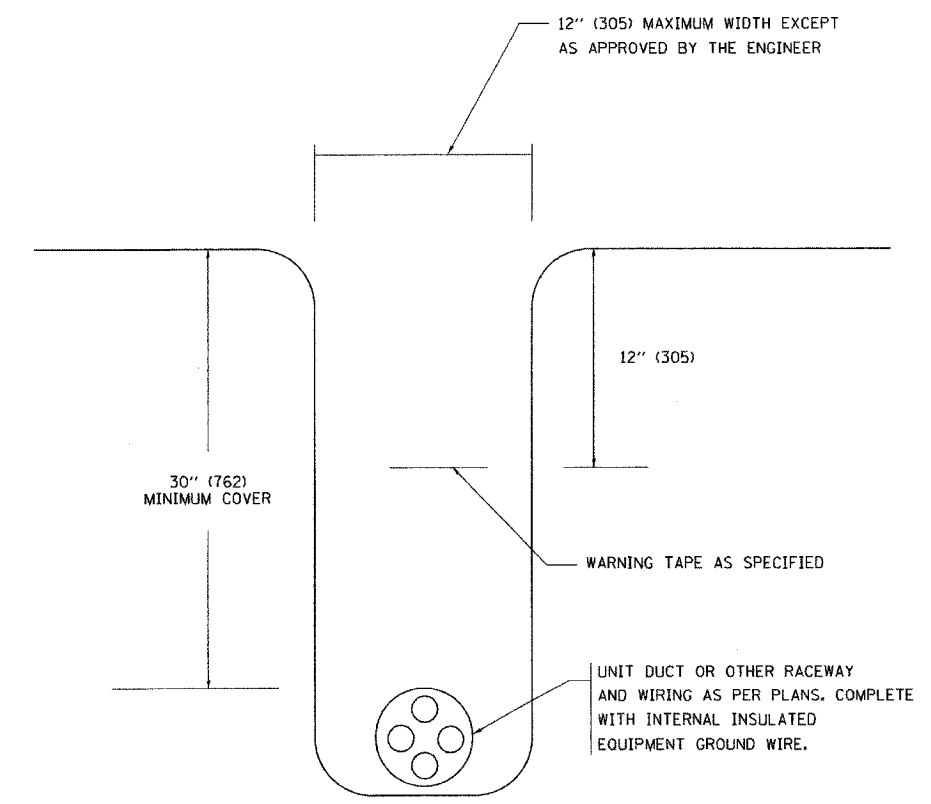

TYPICAL WIRING IN TRENCH DETAIL  
N.T.S.

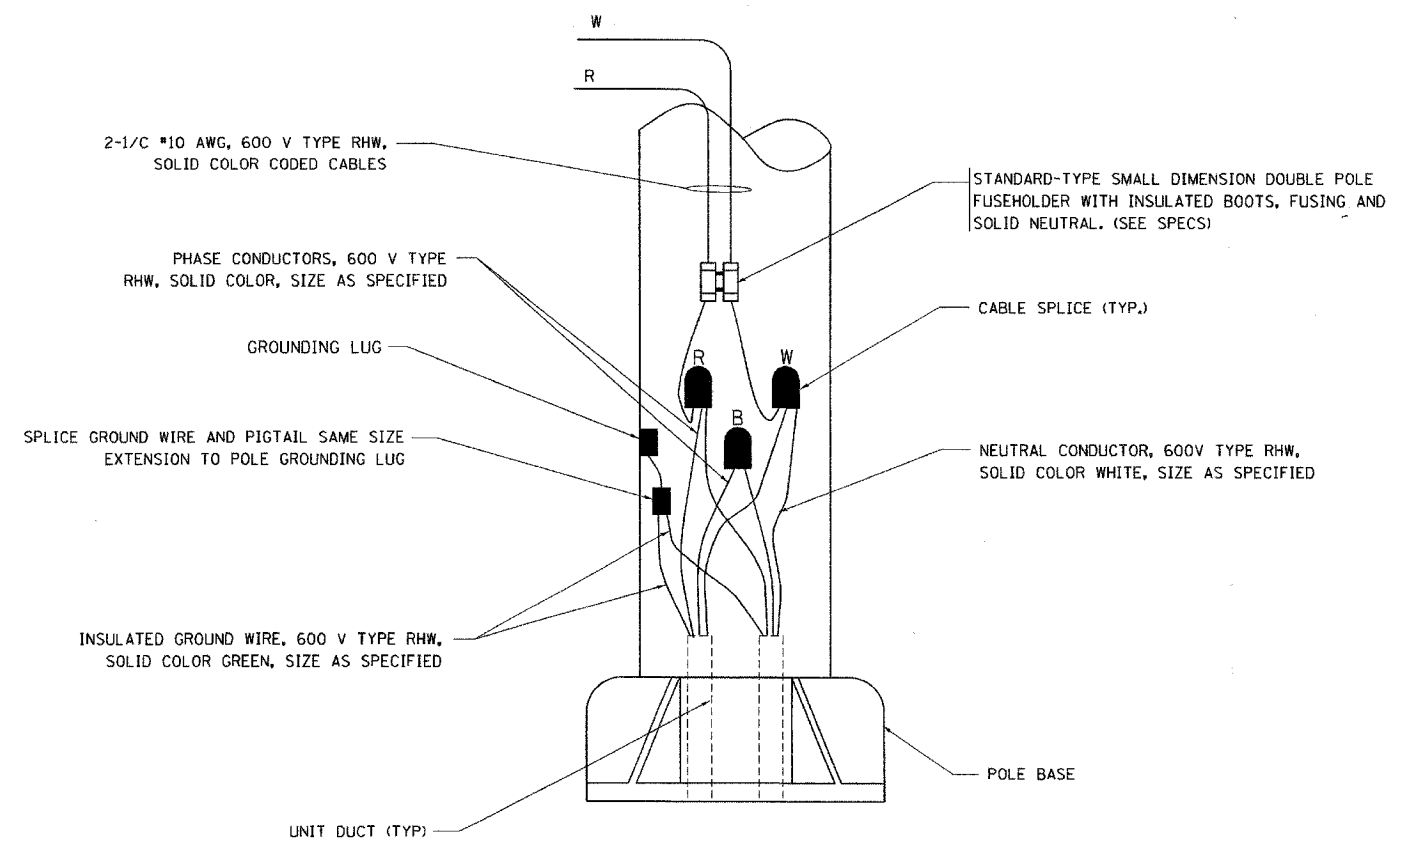

POLE WIRING DETAIL  
N.T.S.

PLOT DATE = 1/18/2007  
 FILE NAME = c:\p\o\meta\data\std\bu\702.dgn  
 PLOT SCALE = 80000 / 1  
 USER NAME = gsg10001

REVISIONS	
NAME	DATE

ILLINOIS DEPARTMENT OF TRANSPORTATION

MISC. ELECTRICAL DETAILS  
SHEET A

SCALE: VERT.  
HORIZ.  
DATE: 1/18/2007

DRAWN BY  
CHECKED BY  
BE-702  
REVISION DATE: 01/01/07