


CONTRACT NO. 62896			
F.A. RTE.	SECTION	COUNTY	TOTAL SHEET NO.
55	99 (I&2) WRS-1	WILL.	227 86
STA. 592+00		TO STA. 607+00	
FED. ROAD DIST. NO.		ILLINOIS FED. AID PROJECT	
DRU-01 OF 10			



CONTRACT NO. 60B86 BY OTHERS
 BEGIN PROJECT CONTRACT NO. 62896

DRAINAGE AND UTILITY LEGEND

EXISTING STORM SEWER	
EXISTING SANITARY SEWER	
EXISTING CULVERT	
EXISTING DITCH	
EXISTING CATCH BASIN	
EXISTING INLET	
EXISTING MANHOLE	
PROPOSED STORM SEWER	
PROPOSED CATCH BASIN	
PROPOSED MANHOLE / DRAINAGE STRUCTURE	
PROPOSED PRECAST FLARED END SECTION	
PROPOSED DITCH	
PROPOSED UNDERDRAIN	
PROPOSED RIPRAP	
ITEM TO BE ADJUSTED	ADJ
STRUCTURE ITEM TO BE CLEANED	C
PIPE ITEM TO BE CLEANED	CLN
ITEM TO BE REMOVED	R
PROPOSED STRUCTURE	
PROPOSED STORM PIPE	

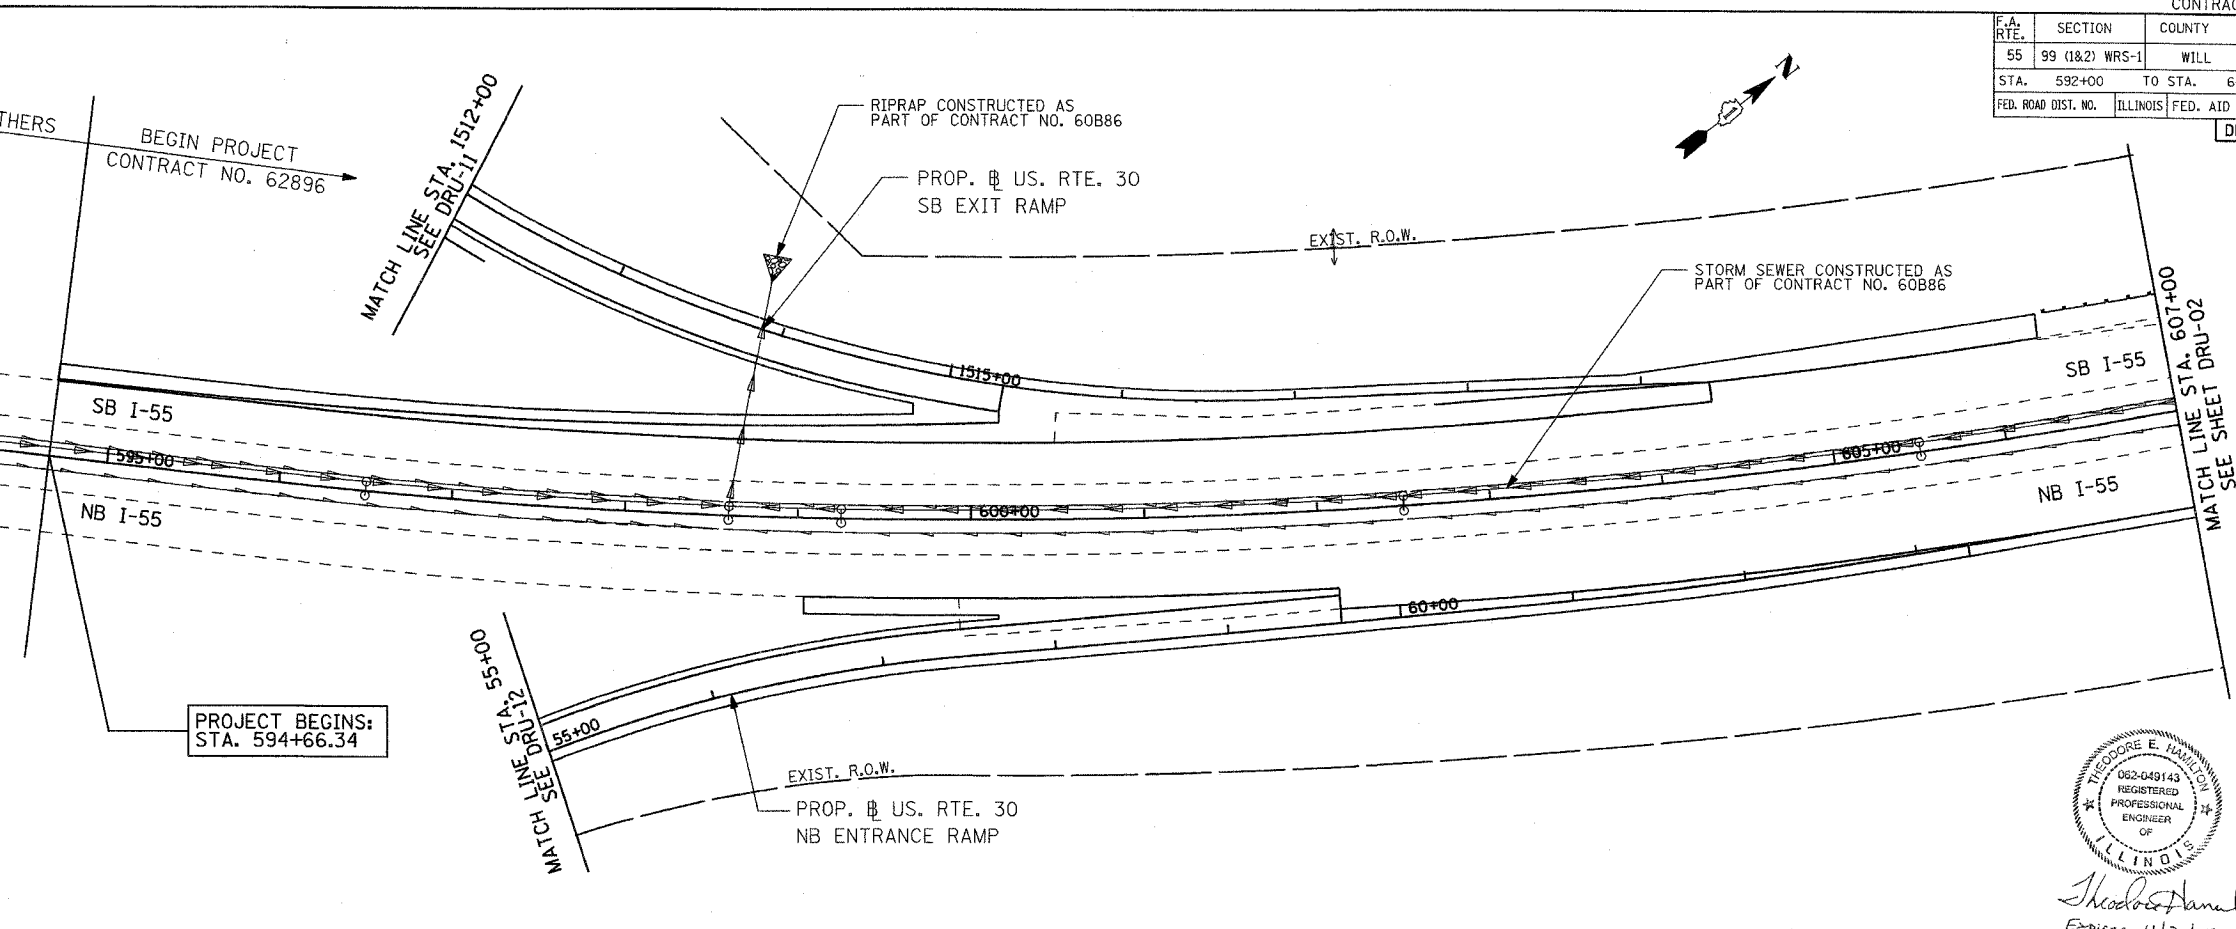

NEEDORE E. HAMILTON
 062-049143
 REGISTERED PROFESSIONAL ENGINEER OF ILLINOIS
Shodor Hamilton
 Expires 11/30/07

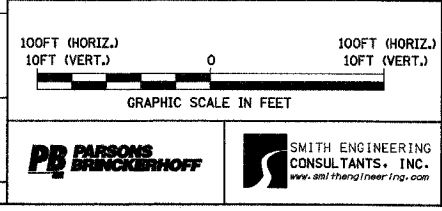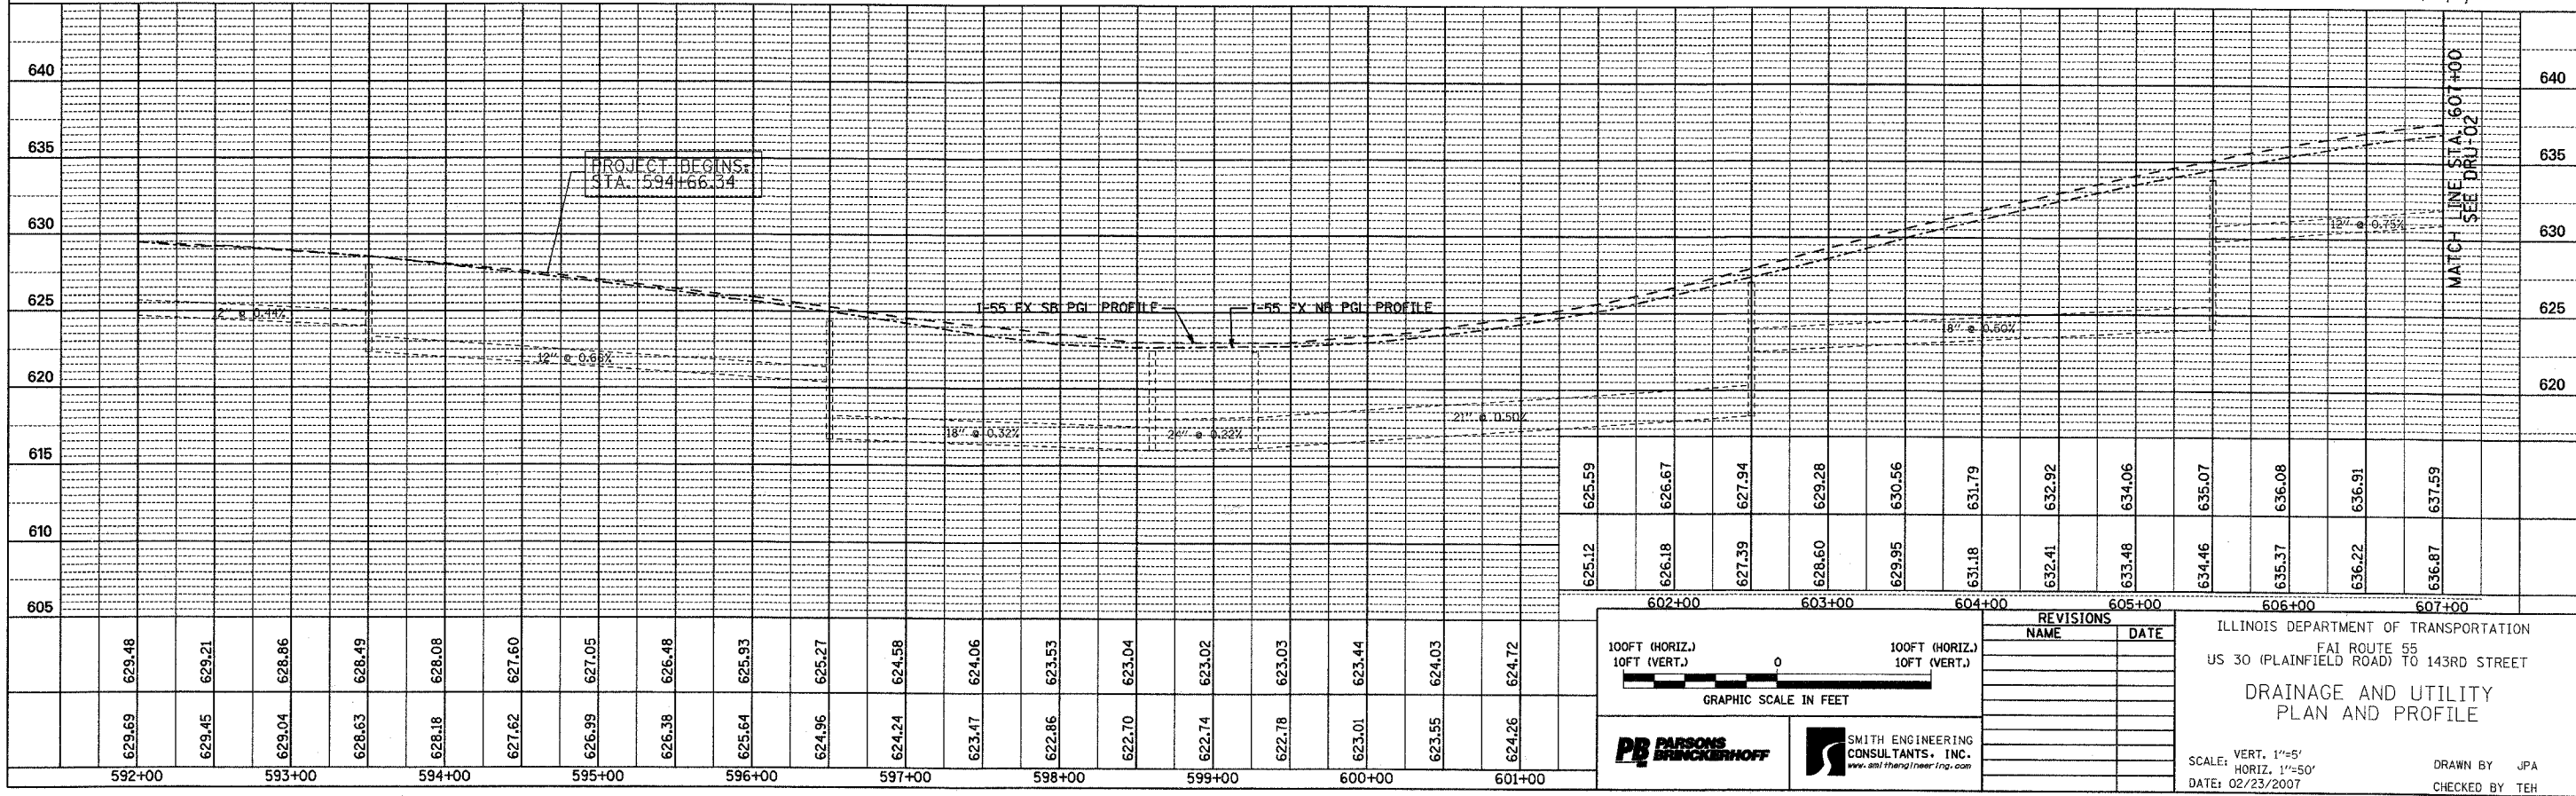

REVISIONS	
NAME	DATE

ILLINOIS DEPARTMENT OF TRANSPORTATION
 FAI ROUTE 55
 US 30 (PLAINFIELD ROAD) TO 143RD STREET

**DRAINAGE AND UTILITY
 PLAN AND PROFILE**

SCALE: VERT. 1"=5'
 HORIZ. 1"=50'
 DATE: 02/23/2007

DRAWN BY JPA
 CHECKED BY TEH

FINAL