


 
F.A.I. RTE.	SECTION	COUNTY	TOTAL SHEETS	SHEET NO.
55	99 (I&2) WRS-1	WILL	227	139
STA. 592+00		TO STA. 608+00		
FED. ROAD DIST. NO.1	ILLINOIS FED. AID PROJECT			
	L-2 OF 7			

**LEGEND**


- EXISTING LIGHTING UNIT TO BE REMOVED AND REINSTALLED
- EXISTING LIGHTING UNIT
- EXISTING DUCT
- SIGN STRUCTURE

**CIRCUIT DESIGNATION SCHEME**

- M CD 1
- POLE NO. ON GIVEN CKT (S)
- CIRCUIT OR CIRCUITS
- LIGHTING CONTROLLER DESIGNATION

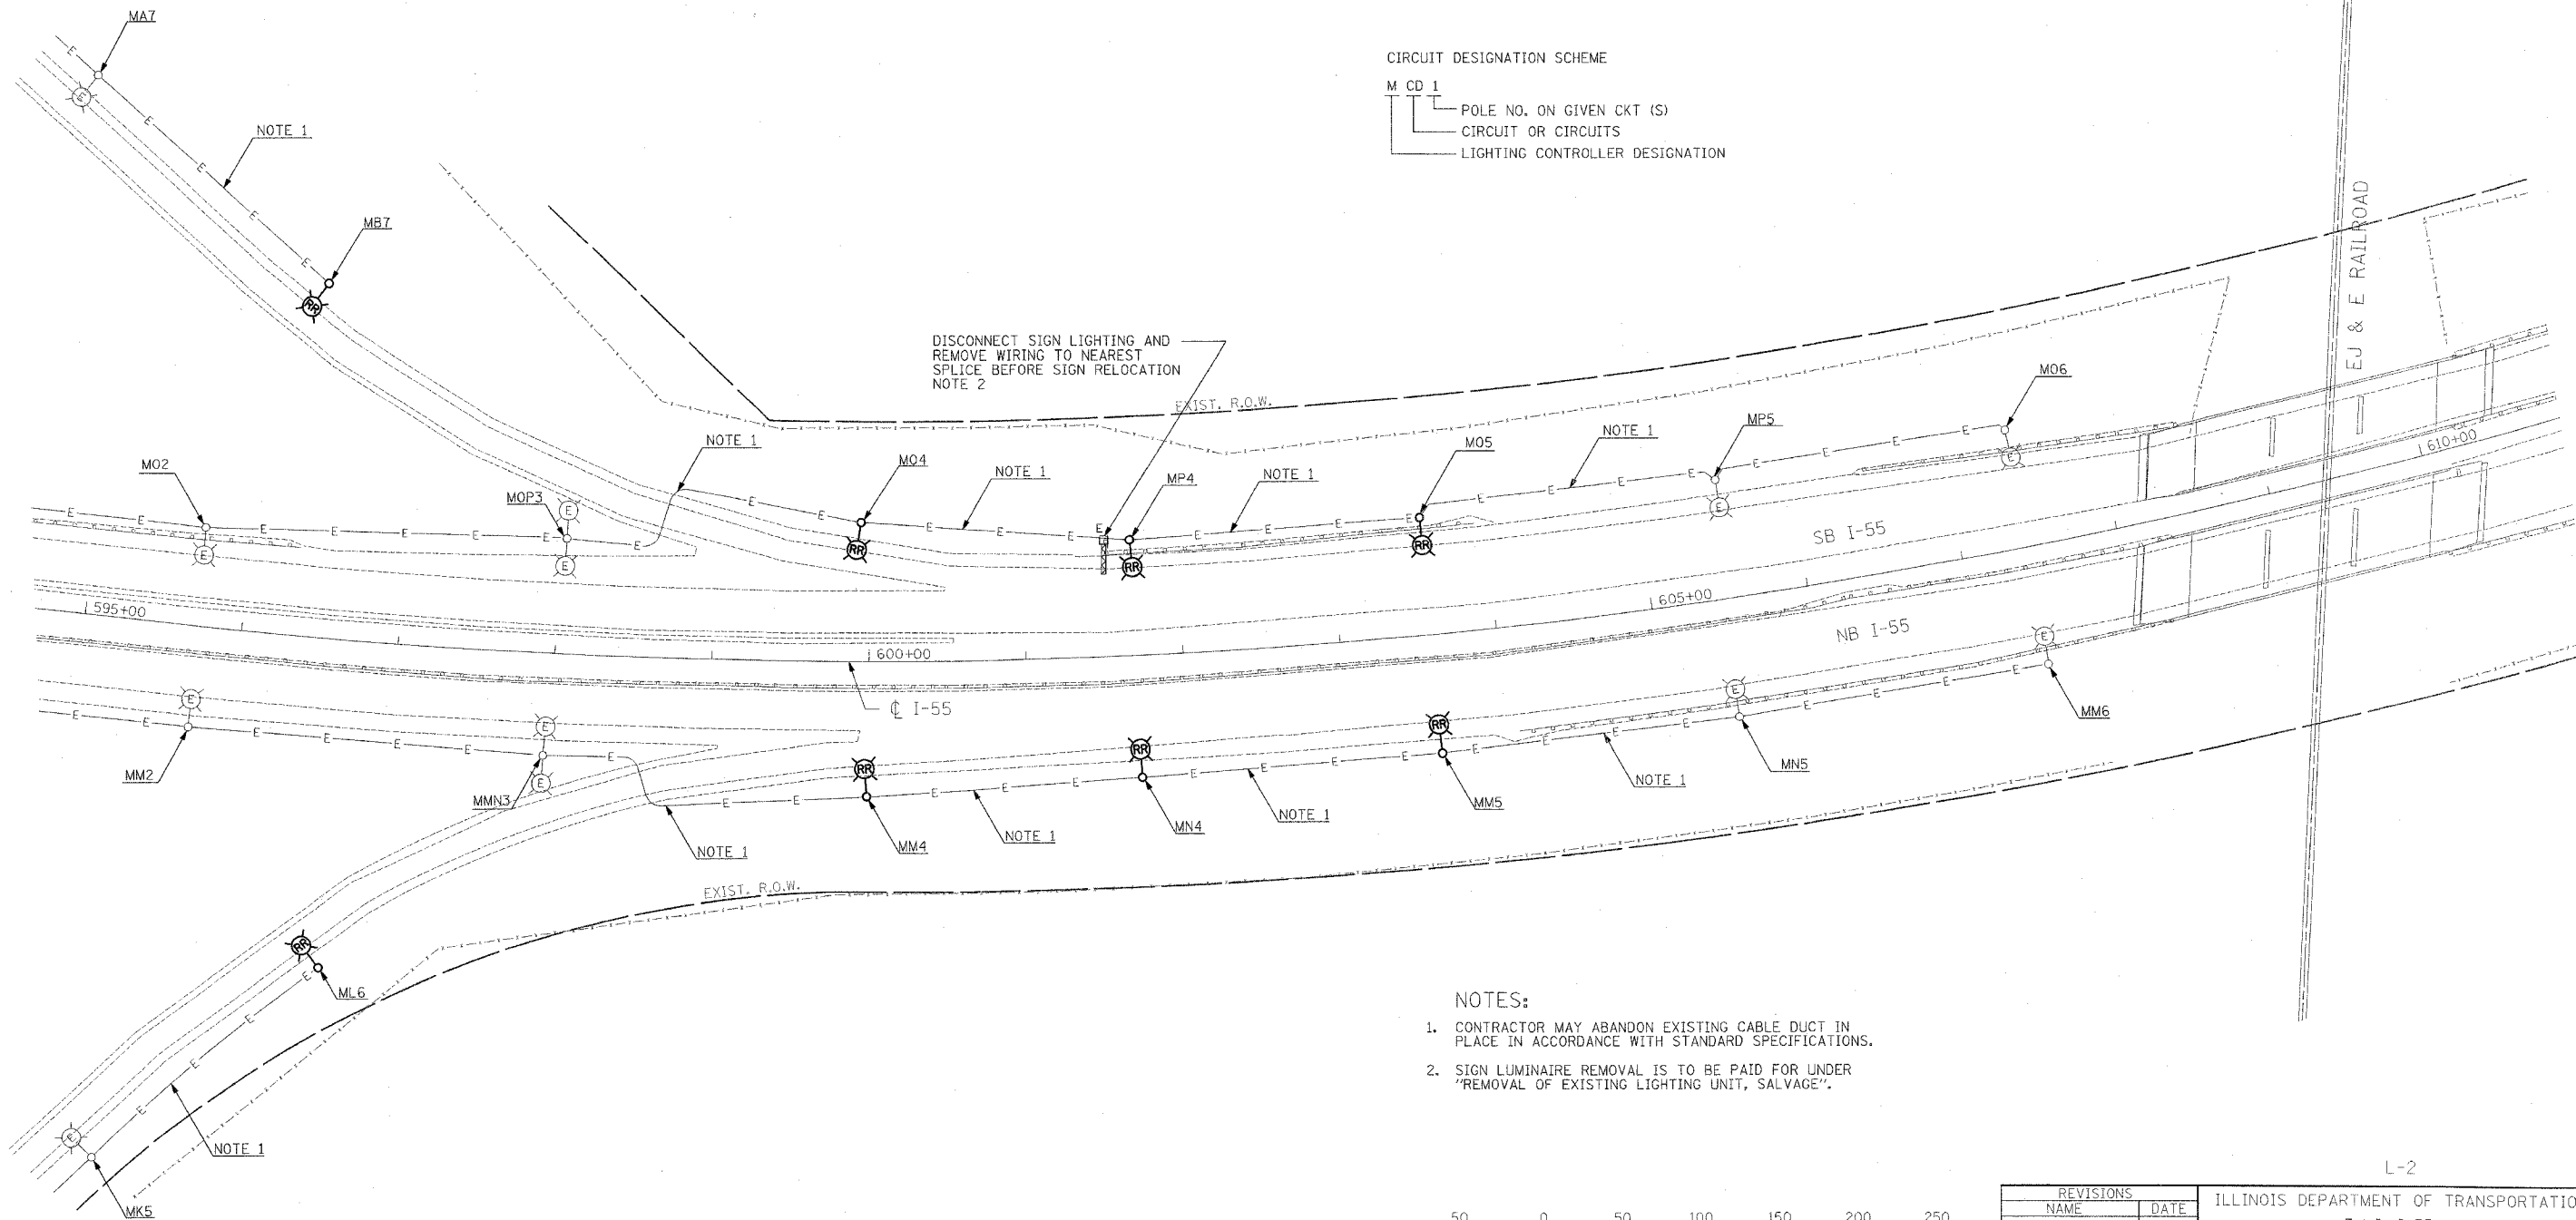

 - NOTES:**
- CONTRACTOR MAY ABANDON EXISTING CABLE DUCT IN PLACE IN ACCORDANCE WITH STANDARD SPECIFICATIONS.
  - SIGN LUMINAIRE REMOVAL IS TO BE PAID FOR UNDER "REMOVAL OF EXISTING LIGHTING UNIT, SALVAGE".



REVISIONS	
NAME	DATE

ILLINOIS DEPARTMENT OF TRANSPORTATION  
 F.A.I. I-55  
 US RTE. 30 TO 143rd STREET  
 EXISTING LIGHTING PLAN  
 SCALE: 1" = 50'  
 DATE: 02-23-07  
 DRAWN BY: VG  
 CHECKED BY: PV

**SINGH** 300 W. ADAMS ST. CHICAGO, IL 60606  
 SINGH & ASSOCIATES, INC. TEL: (312) 629-0240  
 CONSULTING ENGINEERS FAX: (312) 629-8448

**PB PARSONS BRINCKERHOFF**

L-2

**FINAL**