




CONTRACT NO.				
F.A. RYE.	SECTION	COUNTY	TOTAL SHEETS	SHEET NO.
55	99 (I&2) WRS-1	WILL	227	144
STA.		TO STA.		
FED. ROAD DIST. NO. 1		ILLINOIS FED. AID PROJECT		

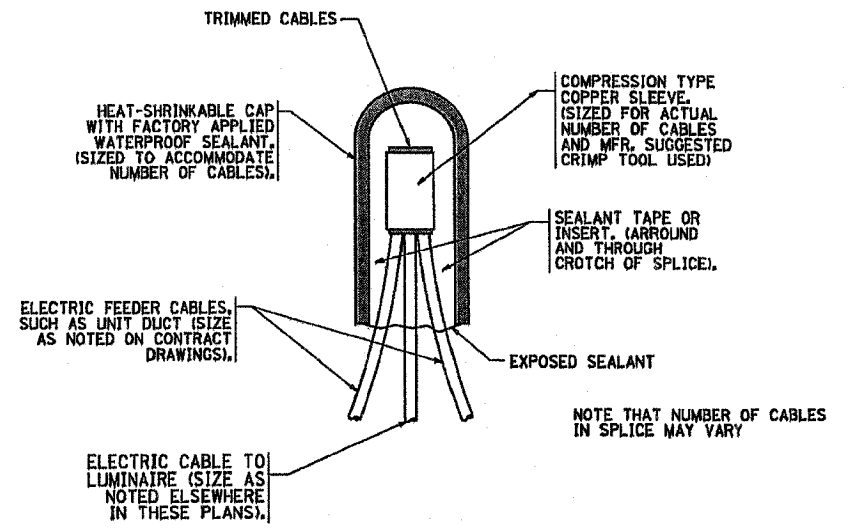


TYPICAL SPLICE DETAIL  
N.T.S.

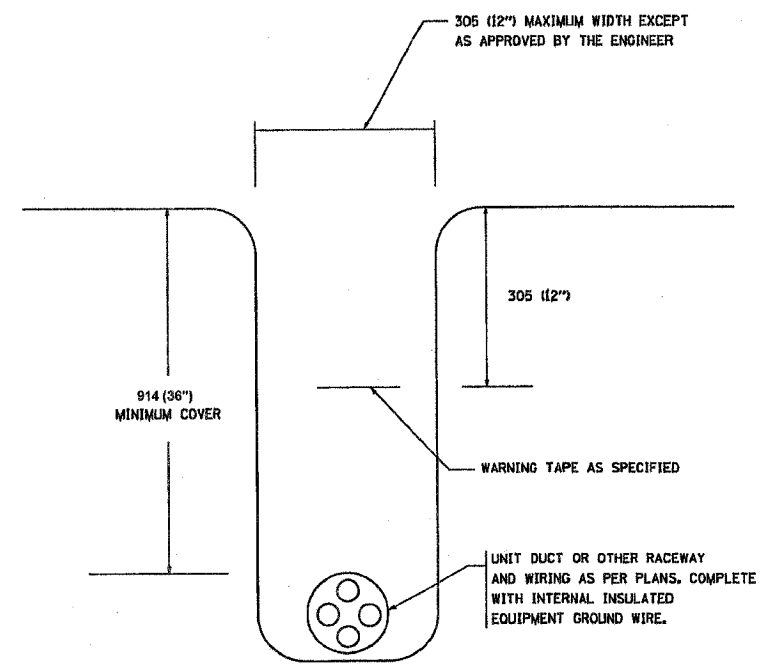

TYPICAL WIRING IN TRENCH DETAIL  
N.T.S.

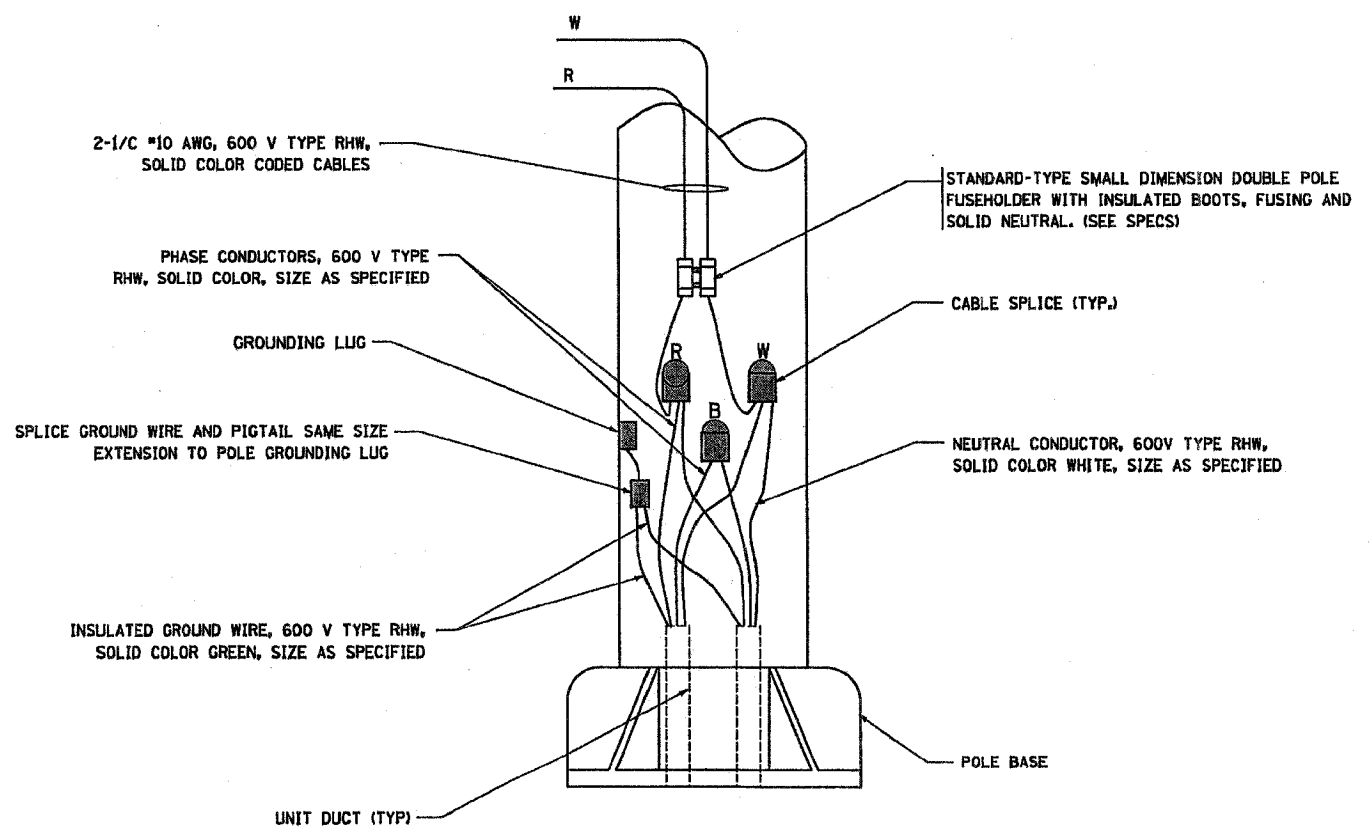

POLE WIRING DETAIL  
N.T.S.

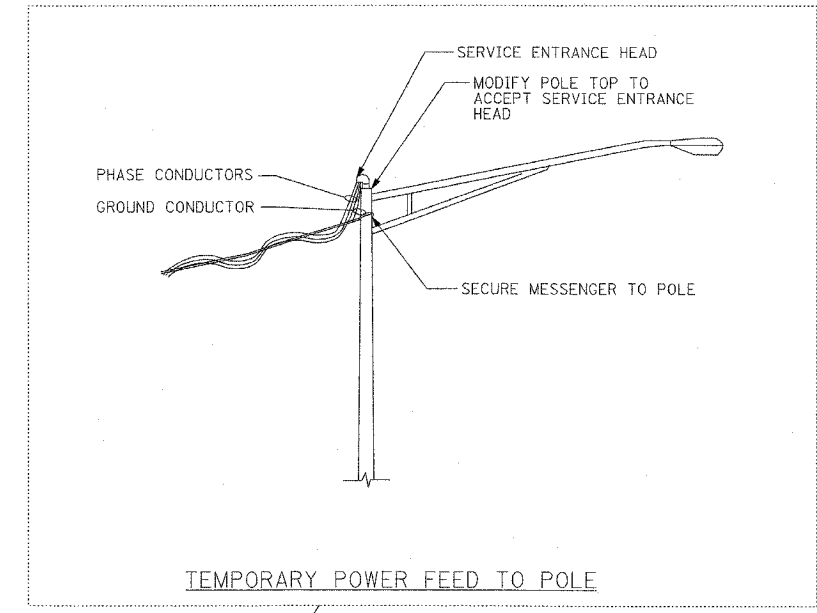

FOR INFORMATION ONLY

L-7

PLOT DATE: 2/15/2006  
 FILE NAME: W:\Projects\099\099-144.dwg  
 PLOT SCALE: 1/8"=1'-0"  
 USER: JAC

**SINGH**  
 SINGH & ASSOCIATES, INC.  
 CONSULTING ENGINEERS

300 W. ADAMS ST.  
 CHICAGO, IL 60606  
 TEL: (312) 629-9249  
 FAX: (312) 629-9449

REVISIONS	
NAME	DATE

ILLINOIS DEPARTMENT OF TRANSPORTATION

MISC. ELECTRICAL DETAILS

SCALE: VERT.  
 HORIZ.  
 DATE: 2/15/2006

DRAWN BY  
 CHECKED BY  
 BE-702  
 REVISION DATE: