



F.A.U. RTE.	SECTION	COUNTY	TOTAL SHEETS	SHEET NO.
9306	04-00042-00-PV	MONROE	22	11
STA. TO STA.				
RIGHT OF WAY				
CONTRACT NO. 97304				
FEDERAL AID PROJECT				

PLAN	BY	DATE
REVISIONS		
NO.		
DATE		
BY		
DATE		
BY		
DATE		

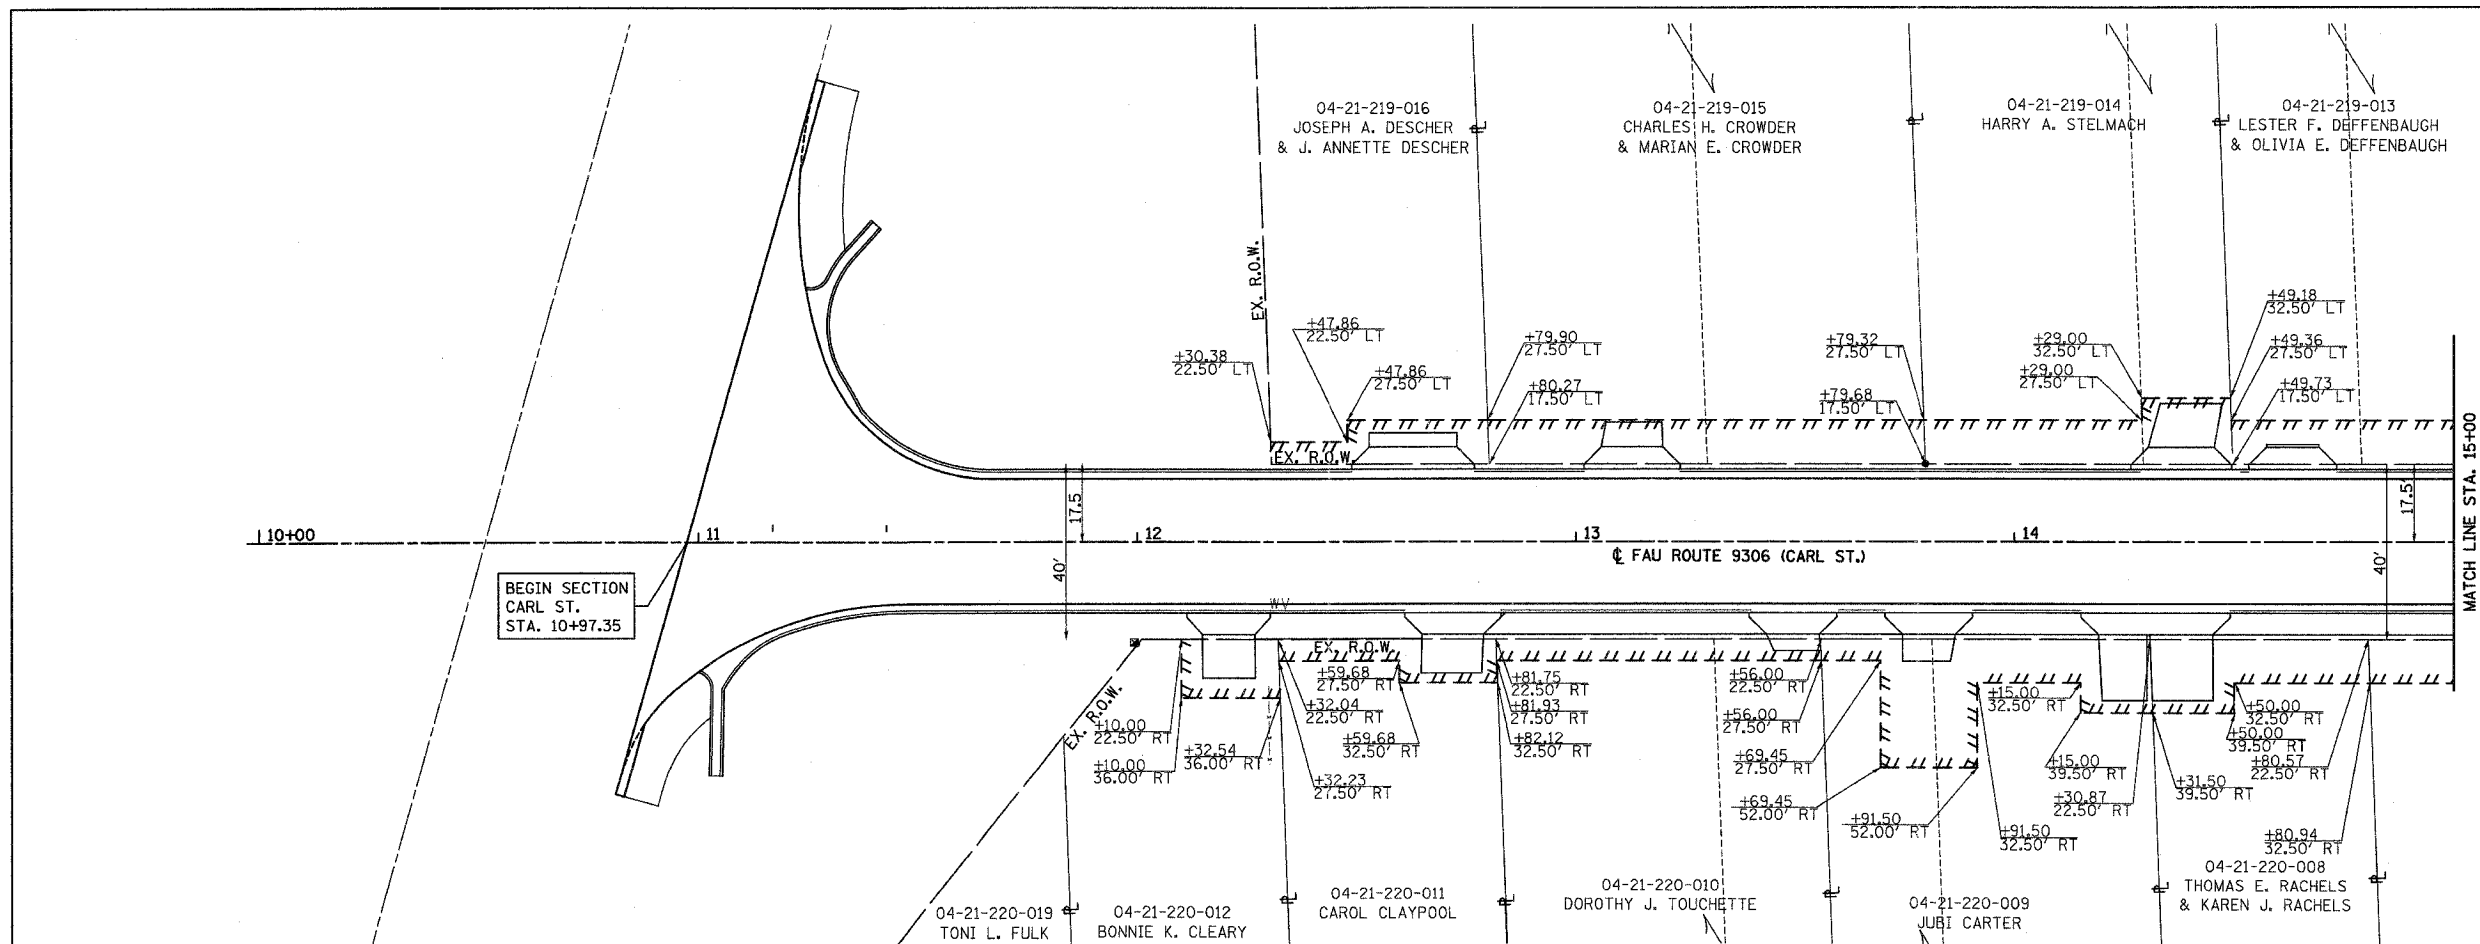


PROFILE	BY	DATE
REVISIONS		
NO.		
DATE		
BY		
DATE		
BY		
DATE		

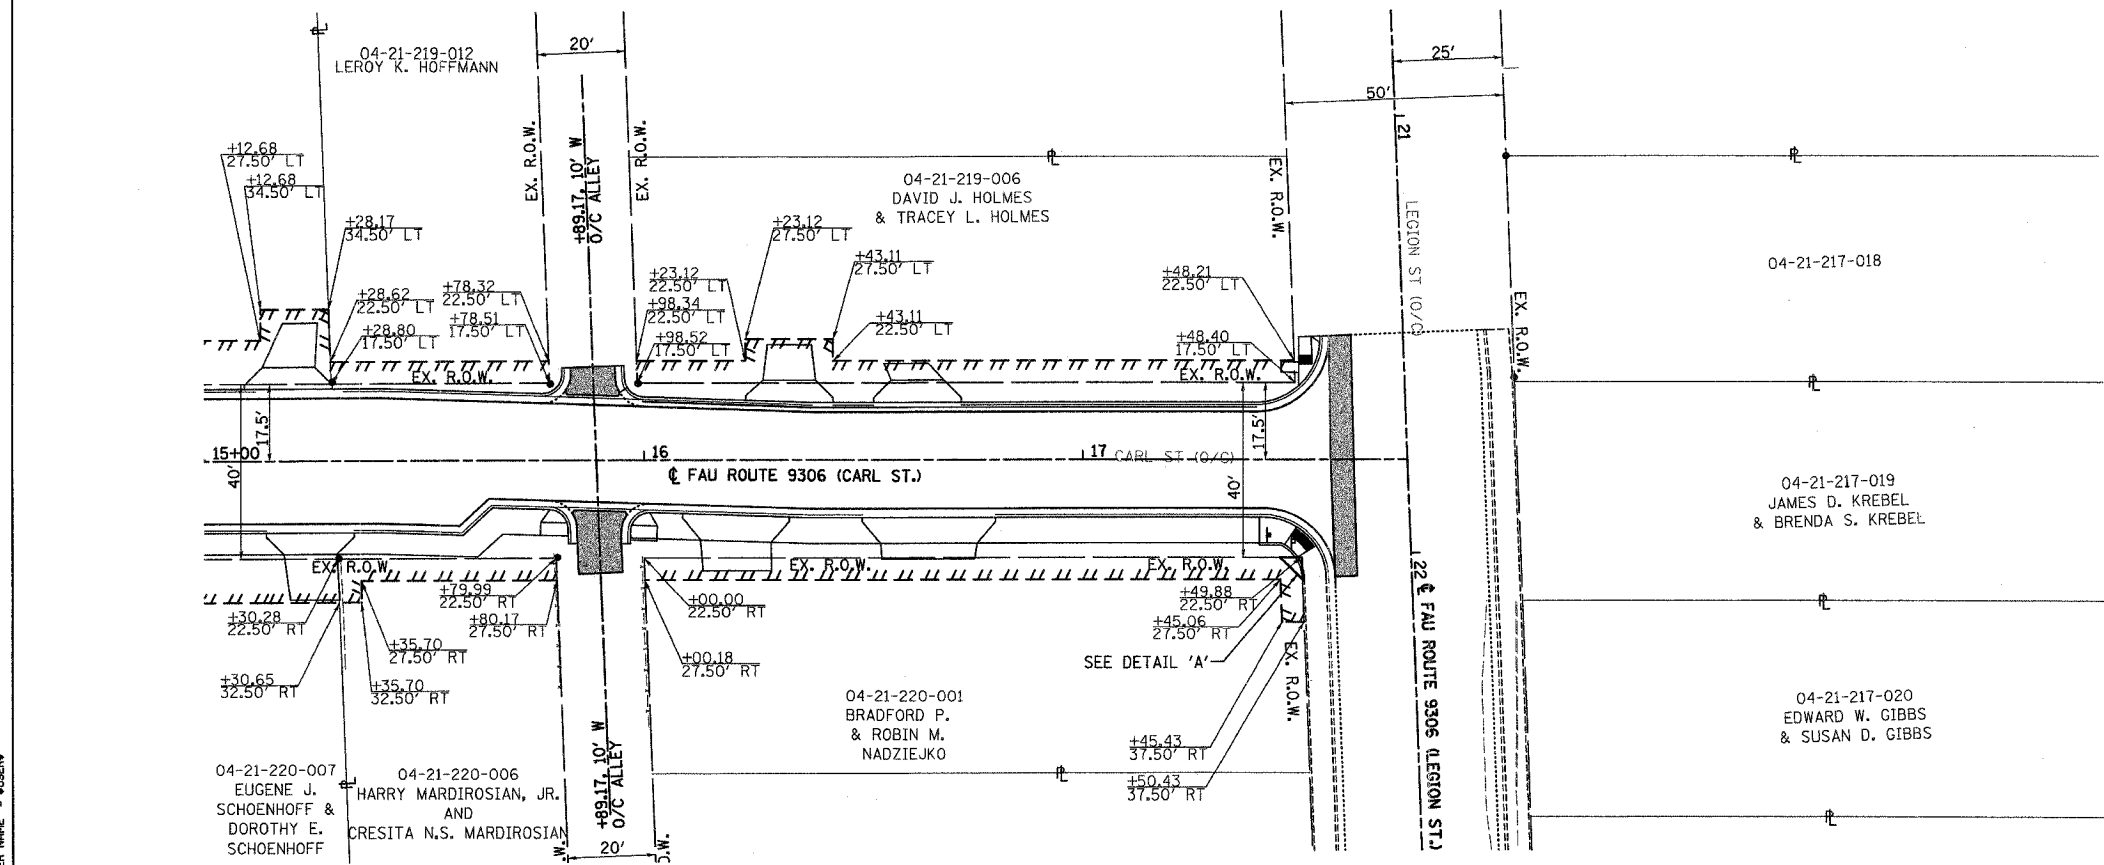

SURVEY TIE POINT SCHEDULE

CONTROL POINT NO.	STATION	DISTANCE, OFFSET	DESCRIPTION	NORTHING	EASTING	ELEVATION
CARL STREET						
CP-11	11+33.81	35.97, LT	IRON BAR	645,269.0420	2,285,905.5830	455.82
CP-12	17+37.55	26.09, RT	IRON BAR	645,870.4573	2,285,987.1114	499.70
CP-28	15+11.43	17.89, LT	NAIL	645,645.8753	2,285,935.8494	487.36

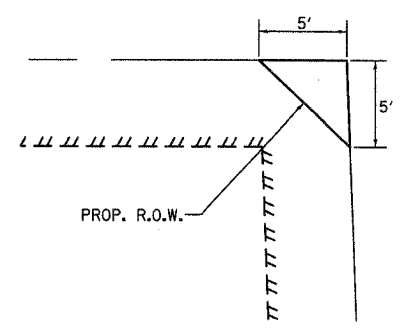

RIGHT OF WAY - CARL ST.

PLOT DATE = 04/04/2007
 PLOT SCALE = 20/800 // IN.
 USER NAME = EUSERN