
 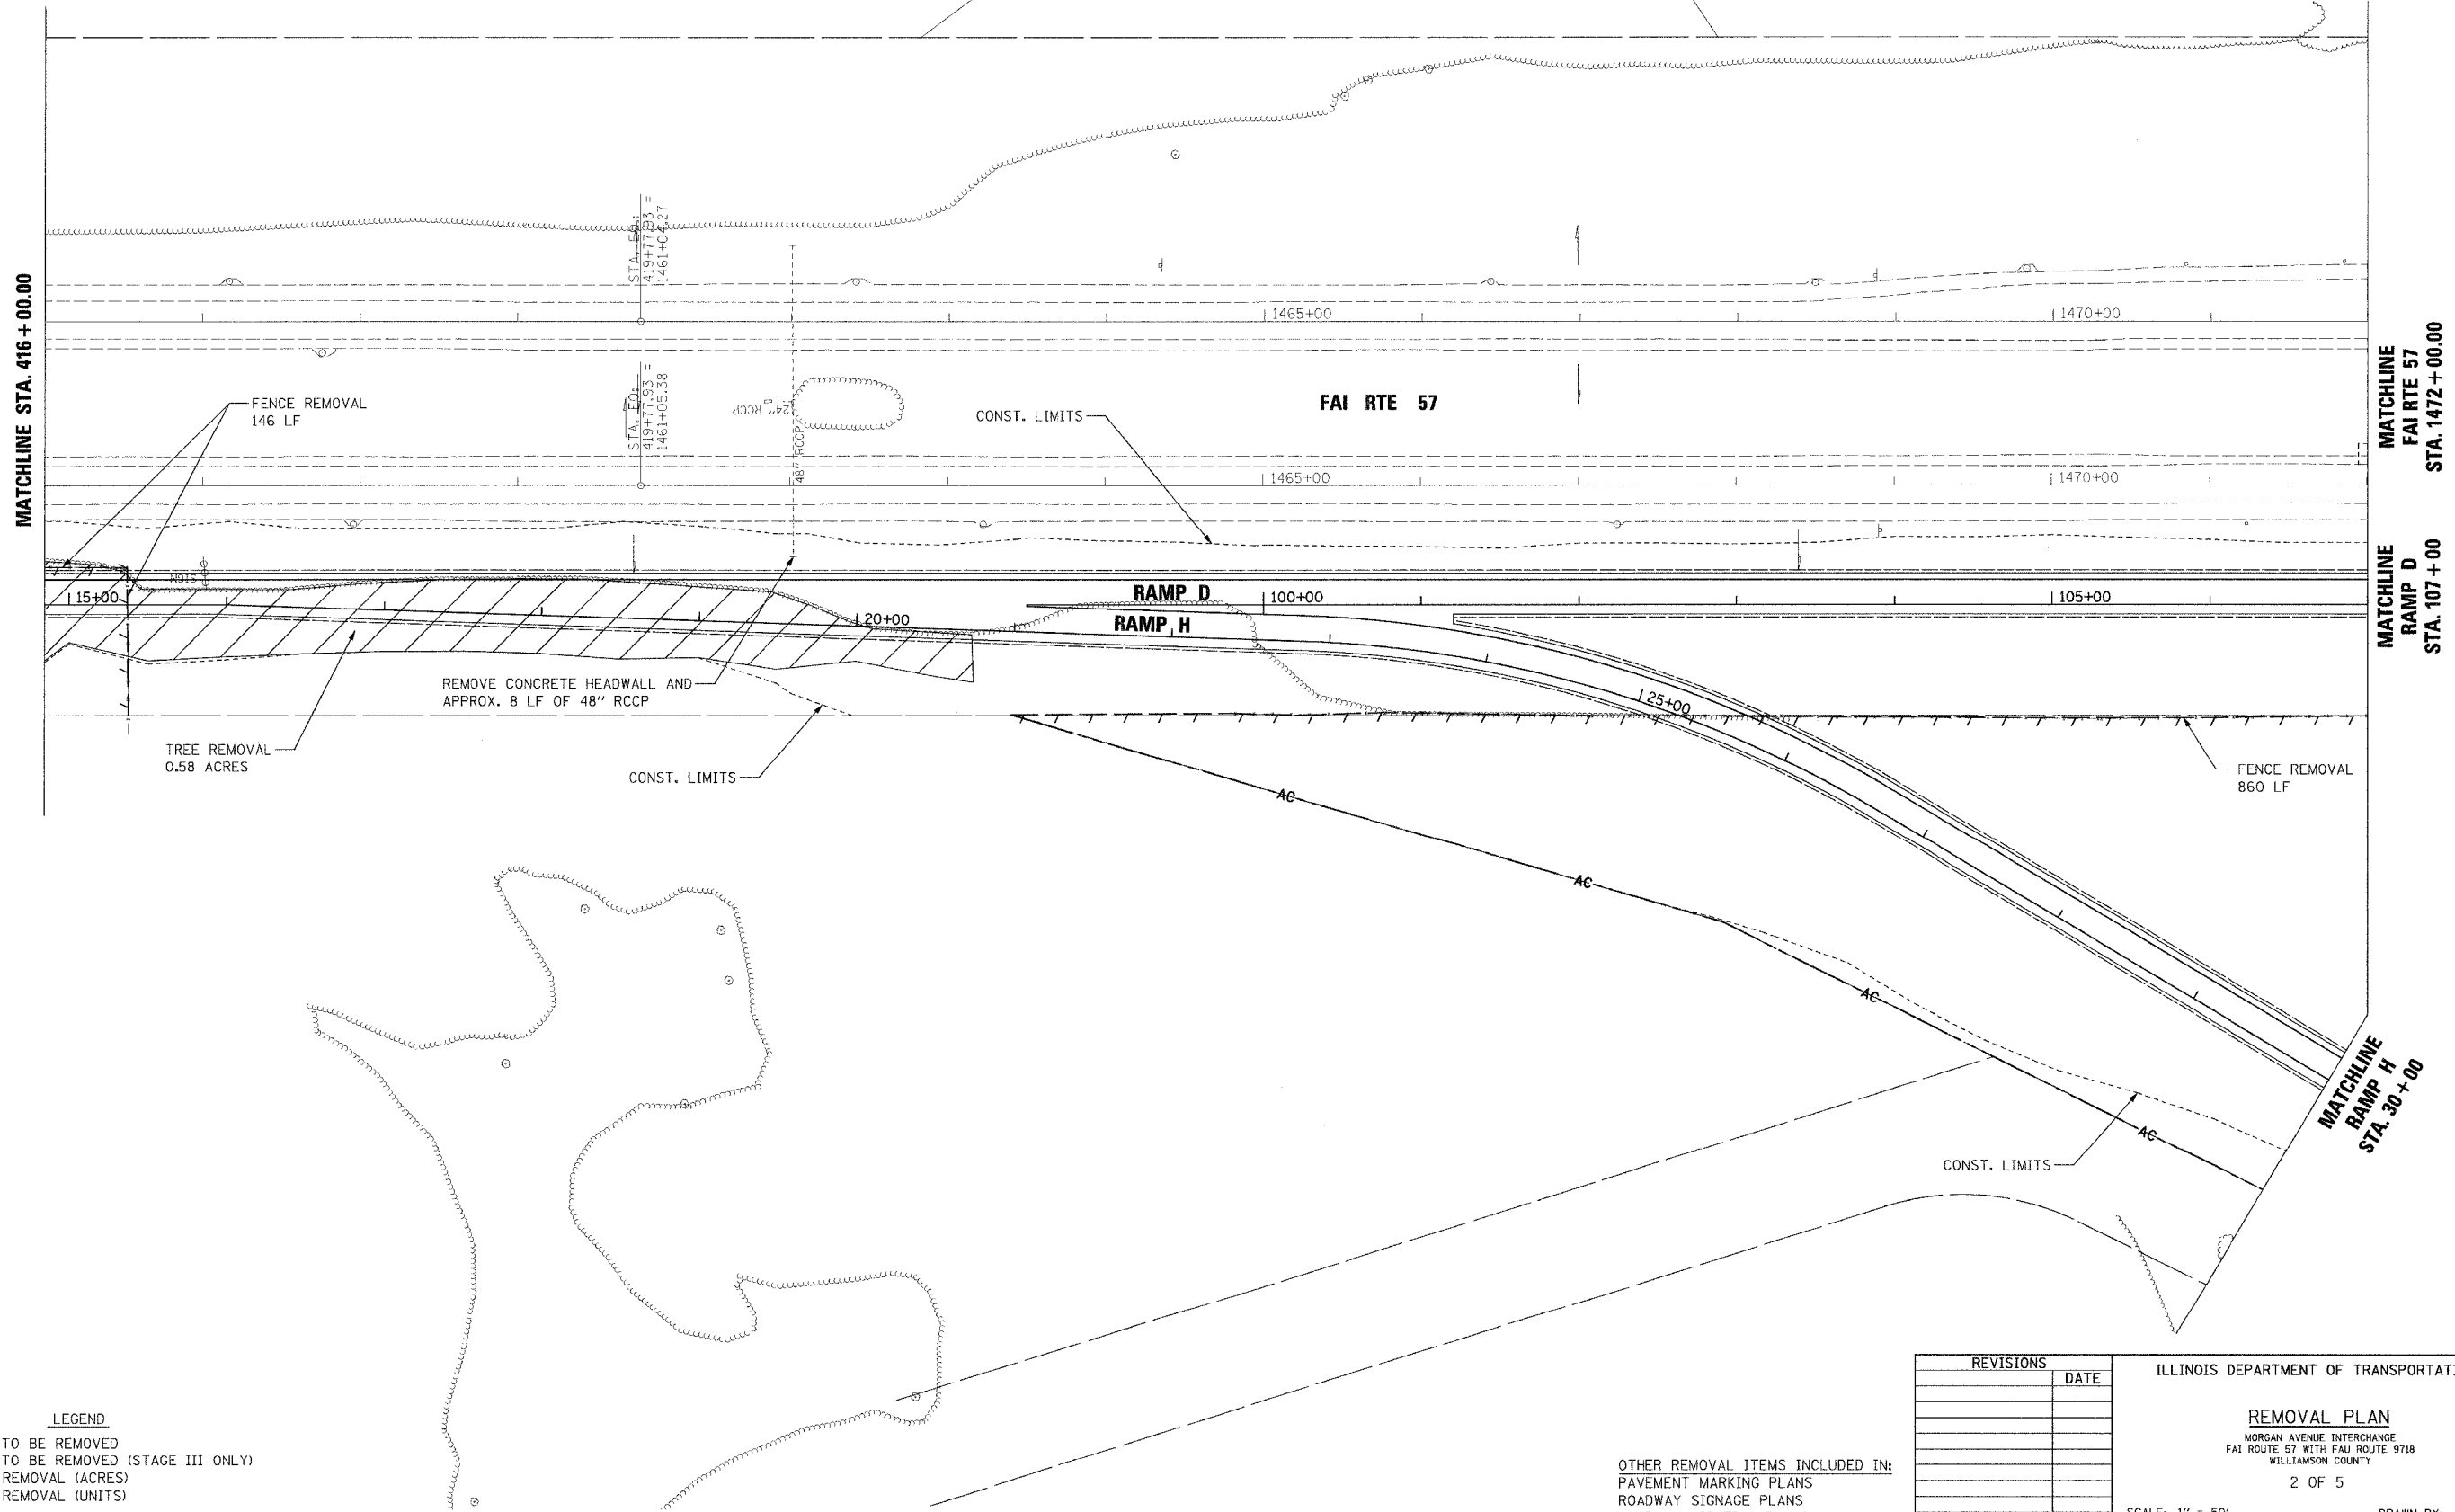


F.A.I. RTE.	SECTION	COUNTY	TOTAL SHEETS	SHEET NO.
57	0X1-6-2H8K	WILLIAMSON	272	44
STA. 416+00		TO STA. 1472+00		
FED. ROAD DIST. NO. 9		ILLINOIS FED. AID PROJECT		



PLOT DATE = 3/19/2007
 FILE NAME = F:\046608\046608.dgn
 PLOT SCALE = 1/8" = 1' / IN.
 USER NAME = chester

- LEGEND**
- ☒ ITEM TO BE REMOVED
 - ☒ ITEM TO BE REMOVED (STAGE III ONLY)
 - ☒ TREE REMOVAL (ACRES)
 - ☒ TREE REMOVAL (UNITS)

OTHER REMOVAL ITEMS INCLUDED IN:
 PAVEMENT MARKING PLANS
 ROADWAY SIGNAGE PLANS
 ROADWAY LIGHTING PLANS

REVISIONS	DATE

ILLINOIS DEPARTMENT OF TRANSPORTATION

REMOVAL PLAN
 MORGAN AVENUE INTERCHANGE
 FAI ROUTE 57 WITH FAU ROUTE 9718
 WILLIAMSON COUNTY

2 OF 5

SCALE: 1" = 50'
 DATE: 3-19-2007

DRAWN BY: MJ
 CHECKED BY: RD