



**1** GROUND FLOOR PLAN - EL: 701.50  
SCALE: 1/4" = 1'-0"

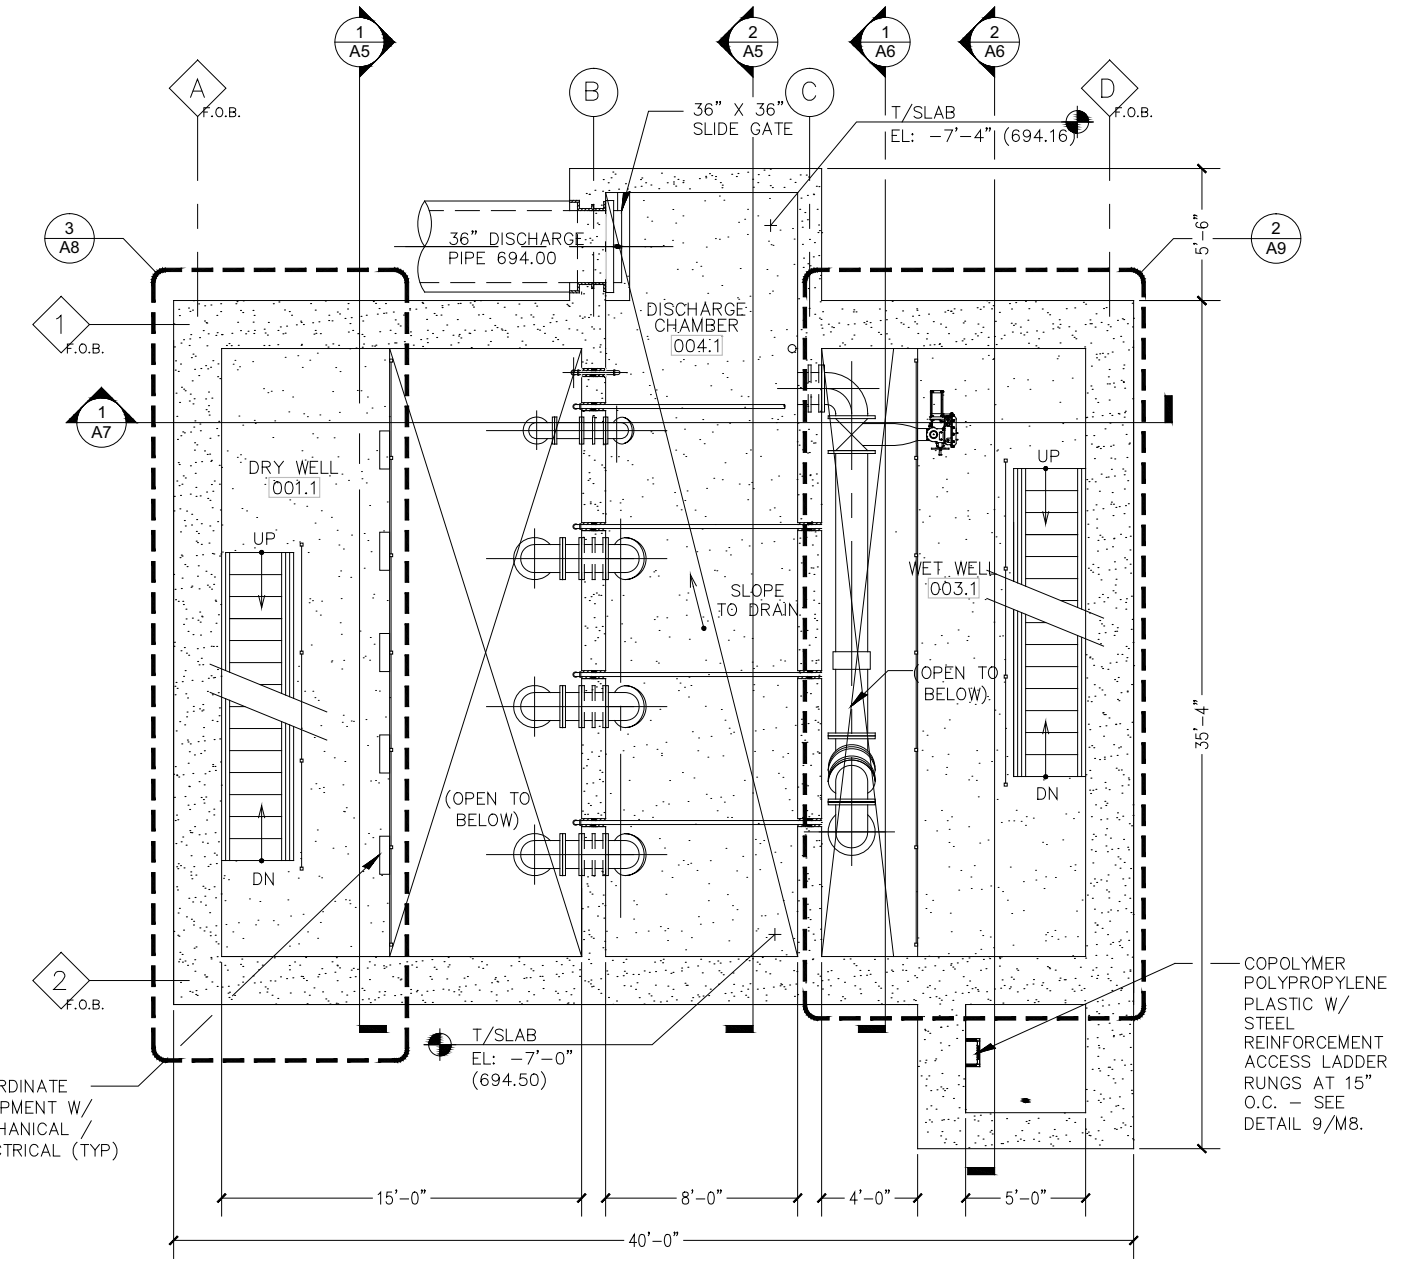


**2** INTERMEDIATE FLOOR PLAN (-1) - EL: 692.75  
- DISCHARGE EL: 694.00 HP  
SCALE: 1/4" = 1'-0"

**NOTES:**

1. SEE SHEET A3 FOR CLERESTORY WINDOW AND LOUVER LOCATIONS AND DIMENSIONS.
2. SEE SHEET E5 FOR REFLECTED CEILING PLANS & LIGHT FIXTURE LOCATIONS & TYPES.

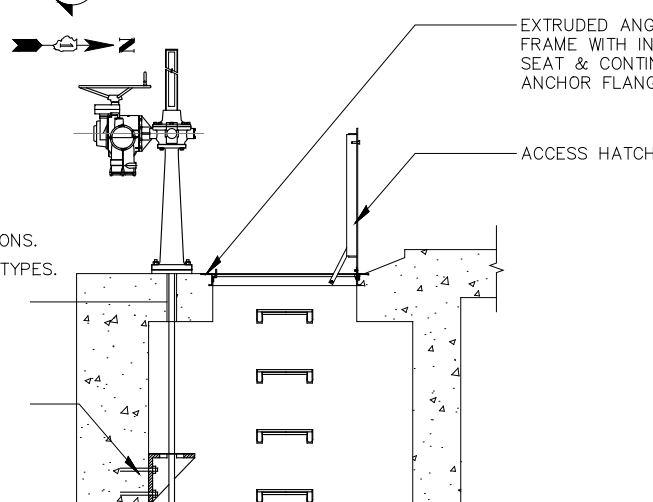

 **3** ACCESS HATCH DETAIL  
SCALE: 1/2" = 1'-0"



A1

<b>KNIGHT</b> Engineers & Architects	DESIGNED RMK	REVISED -	<b>STATE OF ILLINOIS</b> <b>DEPARTMENT OF TRANSPORTATION</b>	<b>GROUND &amp; INTERMEDIATE FLOOR PLANS</b> <b>PUMP STATION 47</b>		F.A.P. RTE.	SECTION	COUNTY	TOTAL SHEETS	SHEET NO.
	CHECKED RMK	REVISED -		338/IL 59	2011-035-1	DUPAGE	181	64		
SCALE -	DRAWN NMP	REVISED -	SHEET NO. A1 OF 12 SHEETS		CONTRACT NO. 60P41		ILLINOIS FED. AID PROJECT			
DATE 03-22-2012	CHECKED RMK	REVISED -								