


1 GROUND FLOOR PLAN - EL: 701.50
SCALE: 1/4" = 1'-0"

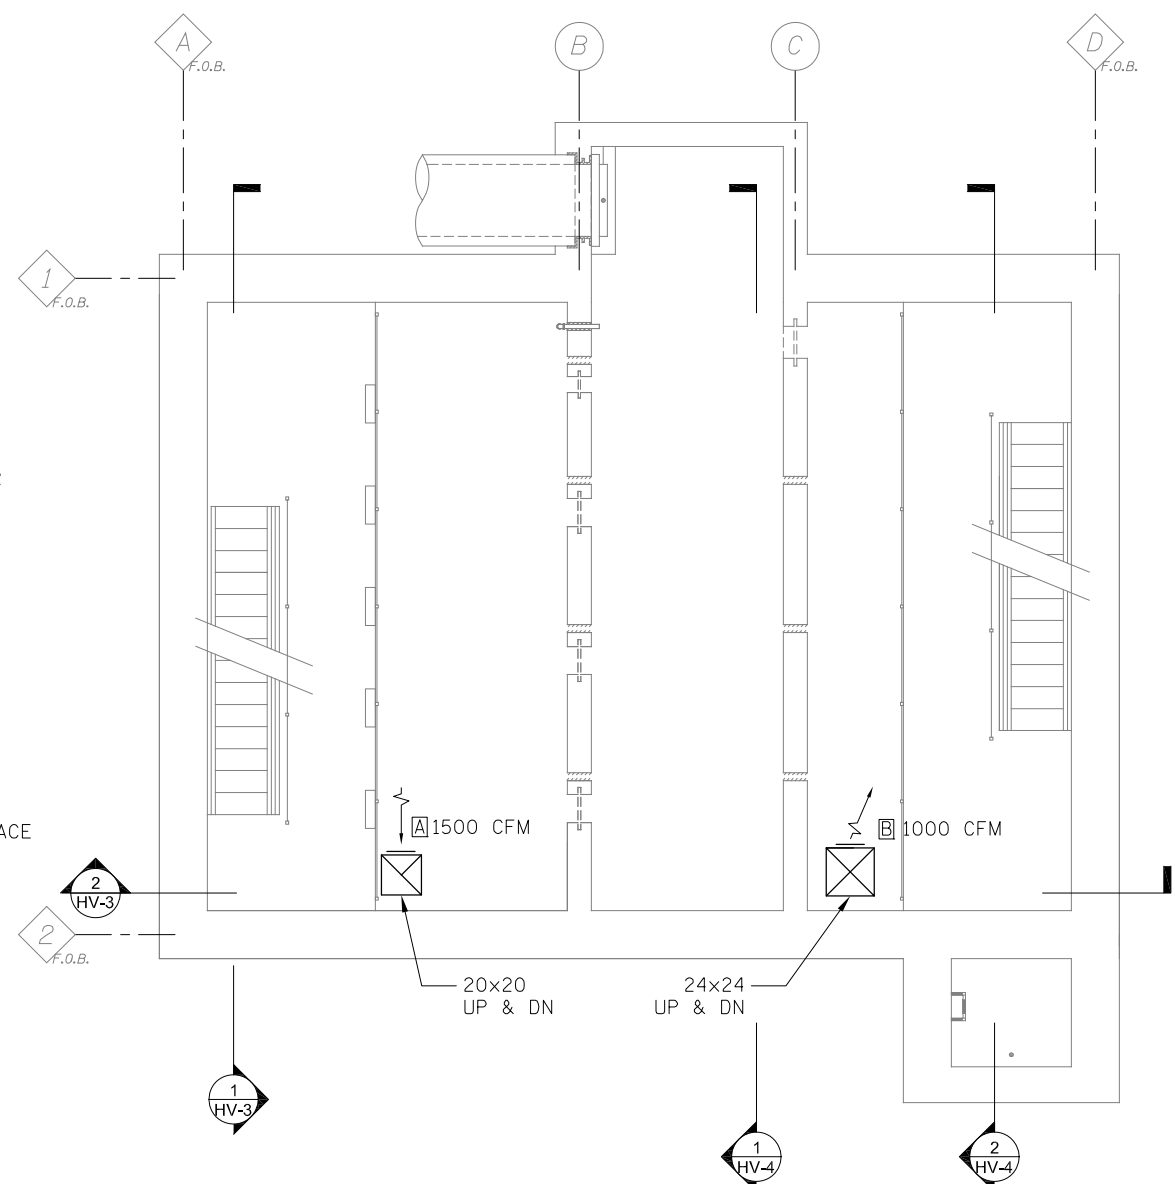

2 INTERMEDIATE FLOOR PLAN (-1) - EL: 692.75
SCALE: 1/4" = 1'-0"
- DISCHARGE EL: 694.00 HP

- NOTES:**
1. ALL DUCTWORK, HANGERS AND SUPPORTS LOCATED THROUGHOUT THE WET WELL SHALL BE STAINLESS STEEL.
 2. THE DRY WELL AND THE WET WELL ARE CLASS I, DIVISION 2 HAZARDOUS LOCATIONS. ALL HEATERS, FANS, ACTUATORS, CONTROLS AND ASSOCIATED APPURTENANCES SERVING THESE SPACES SHALL BE SUITABLE FOR THIS CLASSIFICATION.



McDonough Associates Inc.
Engineers/Architects
130 East Randolph Street, Suite 1000
Chicago, Illinois 60601 Phone (312) 546-8500

DESIGNED	WMC	REVISED	-
CHECKED	RS	REVISED	-
SCALE		REVISED	-
DATE	03/22/2012	REVISED	-

STATE OF ILLINOIS
DEPARTMENT OF TRANSPORTATION

HEATING AND VENTILATION PLANS
PUMP STATION 47

SHEET NO. HV1 OF 5 SHEETS

F.A.P. RTE.	SECTION	COUNTY	TOTAL SHEETS	SHEET NO.
338/IL 59	2011-035-I	DUPAGE	181	119
CONTRACT NO. 60P41			ILLINOIS FED. AID PROJECT	

HV1