


- NOTES:**
- SEE SHEETS GI-1 AND GI-2 FOR INSTRUMENTATION SYMBOL LISTS, ABBREVIATIONS, AND GENERAL NOTES.
 - REFER TO SPECIFICATION SECTION 40 94 23 FOR SCADA PANEL REQUIREMENTS.

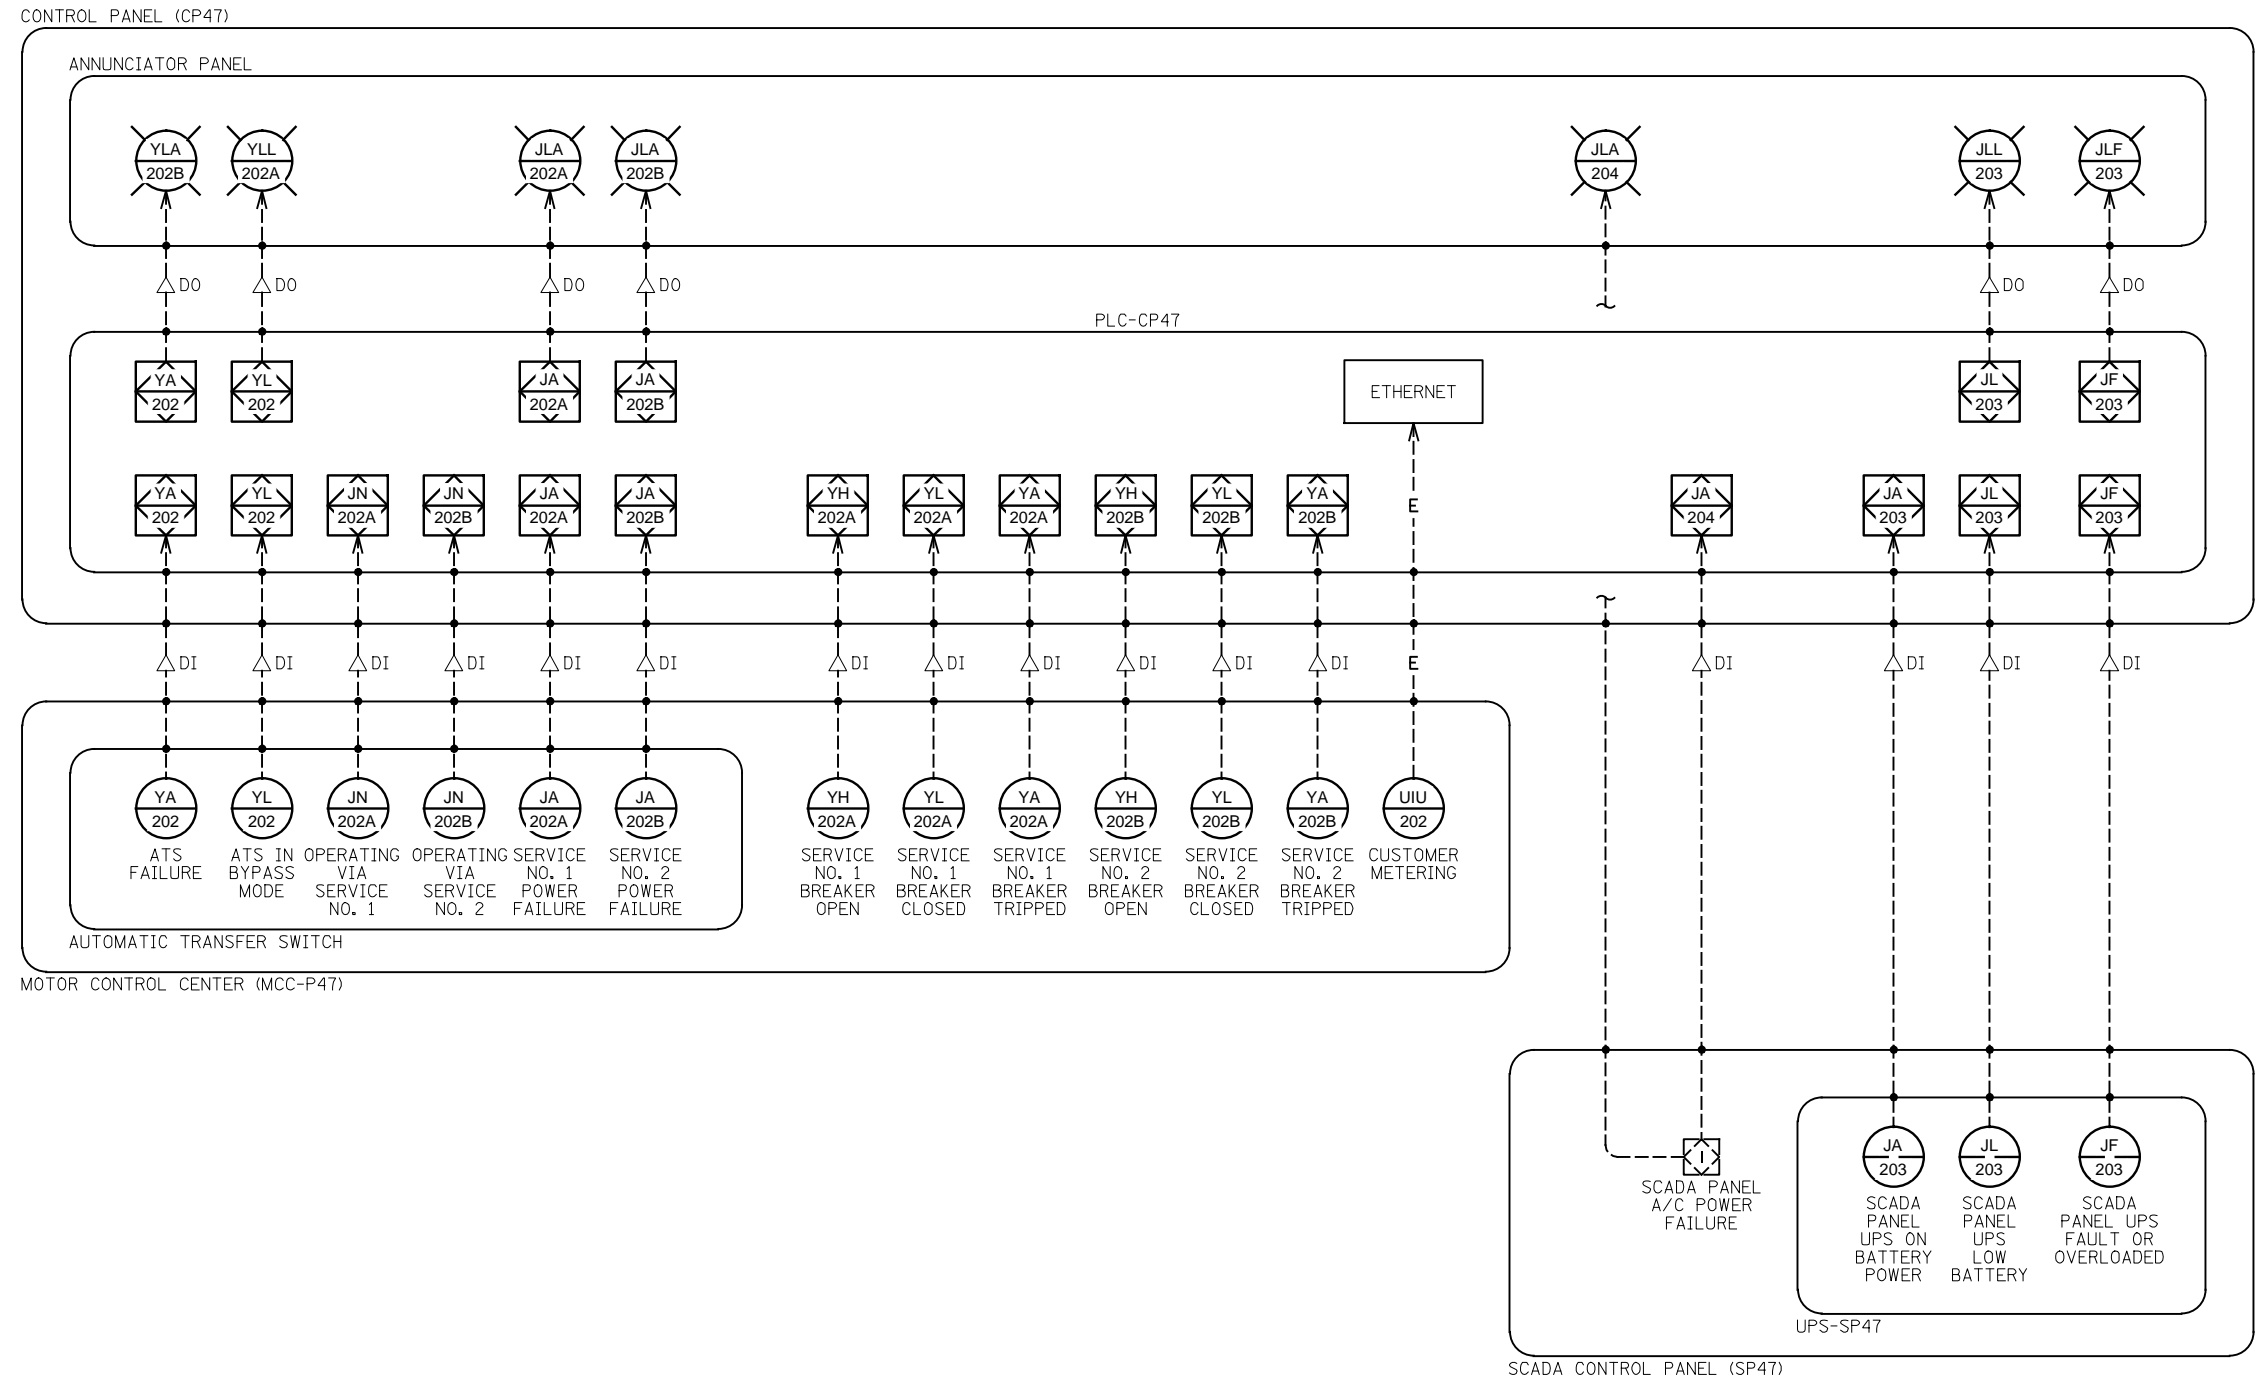

1 POWER TRANSFER P&ID DRAWING

DESIGNED	DKC	REVISED	- 4-19-2012
CHECKED	KMY	REVISED	-
SCALE	DRAWN CJM	REVISED	-
DATE	03/22/2012	CHECKED	KMY
		REVISED	-

F.A.P. RTE.	SECTION	COUNTY	TOTAL SHEETS	SHEET NO.
338/IL 59	2011-035-I	DUPAGE	181	138
CONTRACT NO. 60P41				
ILLINOIS FED. AID PROJECT				