


NOTE:
 1. THE GENERAL CONTRACTOR IS REQUIRED TO HIRE AN ENVIRONMENTAL FIRM WITH AT LEAST FIVE (5) DOCUMENTED LEAKING UNDERGROUND STORAGE TANK CLEANUPS OR THAT IS PRE-QUALIFIED IN HAZARDOUS WASTE BY THE DEPARTMENT TO REMEDIATE THE SOIL CONTAMINATION AND MONITOR FOR WORKER PROTECTION.

SCALE:
 HORIZONTAL 1" = 20'
 VERTICAL 1" = 5'

CROSS STREET

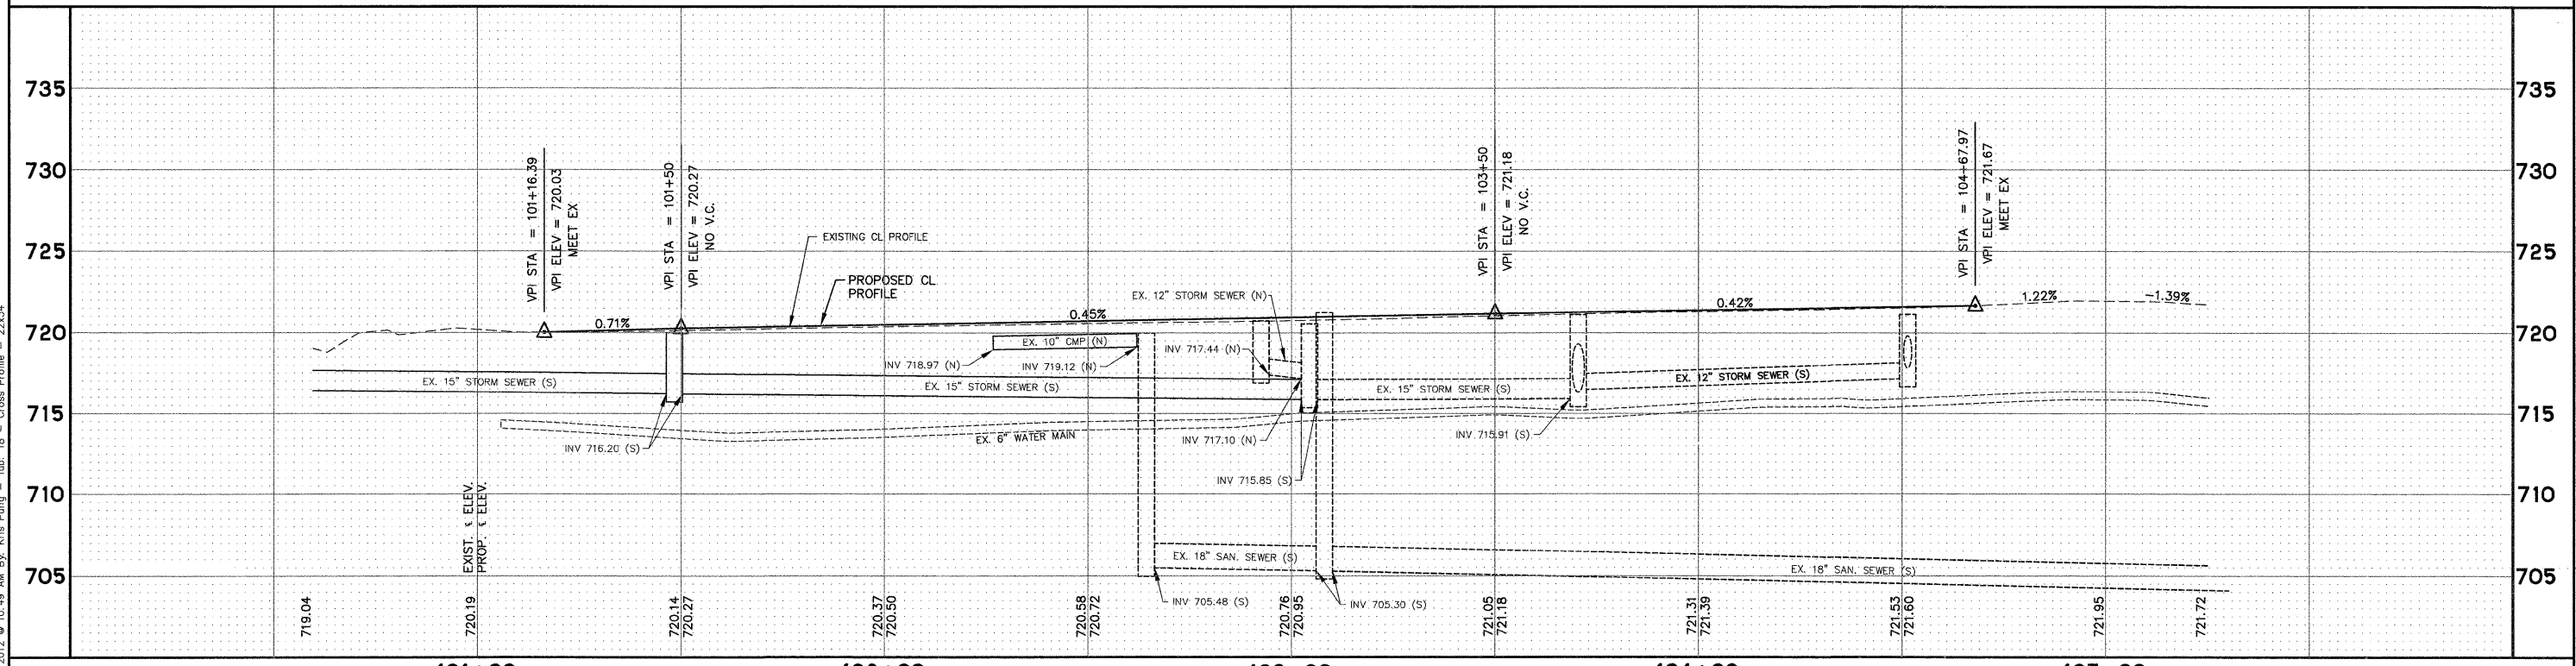

COPYRIGHT © 2012 ENGINEERING ENTERPRISES, INC.

Engineering Enterprises, Inc.
 CONSULTING ENGINEERS
 52 Wheeler Road
 Sugar Grove, Illinois 60554
 630.466.6700 / www.eeiweb.com

USER NAME =	DESIGNED -	REVISED -
PLOT SCALE =	DRAWN -	REVISED -
PLOT DATE =	CHECKED -	REVISED -
	DATE -	REVISED -

**STATE OF ILLINOIS
 DEPARTMENT OF TRANSPORTATION**

CROSS STREET - PLAN AND PROFILE

SCALE: 1"=20' SHEET NO. 4 OF 7 SHEETS STA. 100+50 TO STA. 105+25

F.A.P. RTE.	SECTION	COUNTY	TOTAL SHEETS	SHEET NO.
326	10-00023-00-ES	KANE	70	18
CONTRACT NO. 63700				
FED. ROAD DIST. NO. 1 (ILLINOIS) FED. AID PROJECT NO. M-9003(717)				

Plotted: February 20, 2012 @ 10:49 AM By: Kris Pung - Tab: 18 - Cross Profile - 22x34

Path: \\S:\S\PROJ\1001002\DWG\DWG_FINAL_ENG\SG1002-PP-ROADWAY