

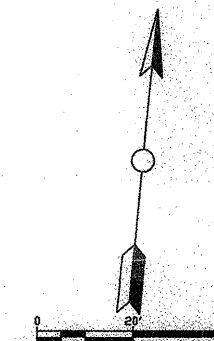


STREET LIGHTING LEGEND	
GENERAL SITE	
●-■	STREET LIGHT AND POLE
①	LIGHT FIXTURE
A-CIE	CONTROL PANEL AND CIRCUIT NUMBER
□	PULL BOX
②, ③	CONDUIT
*-10AWG	* NUMBER OF WIRES - WIRE SIZE AMERICAN WIRE GAUGE

Calculation Summary							
Label	CalcType	Units	Avg	Max	Min	Avg/Min	Max/Min
Road_Luminance	Luminance	Cd/Sq.m	1.06	2.0	0.3	3.53	6.67

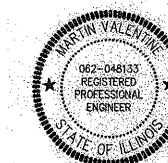

FUTURE DEVELOPMENT

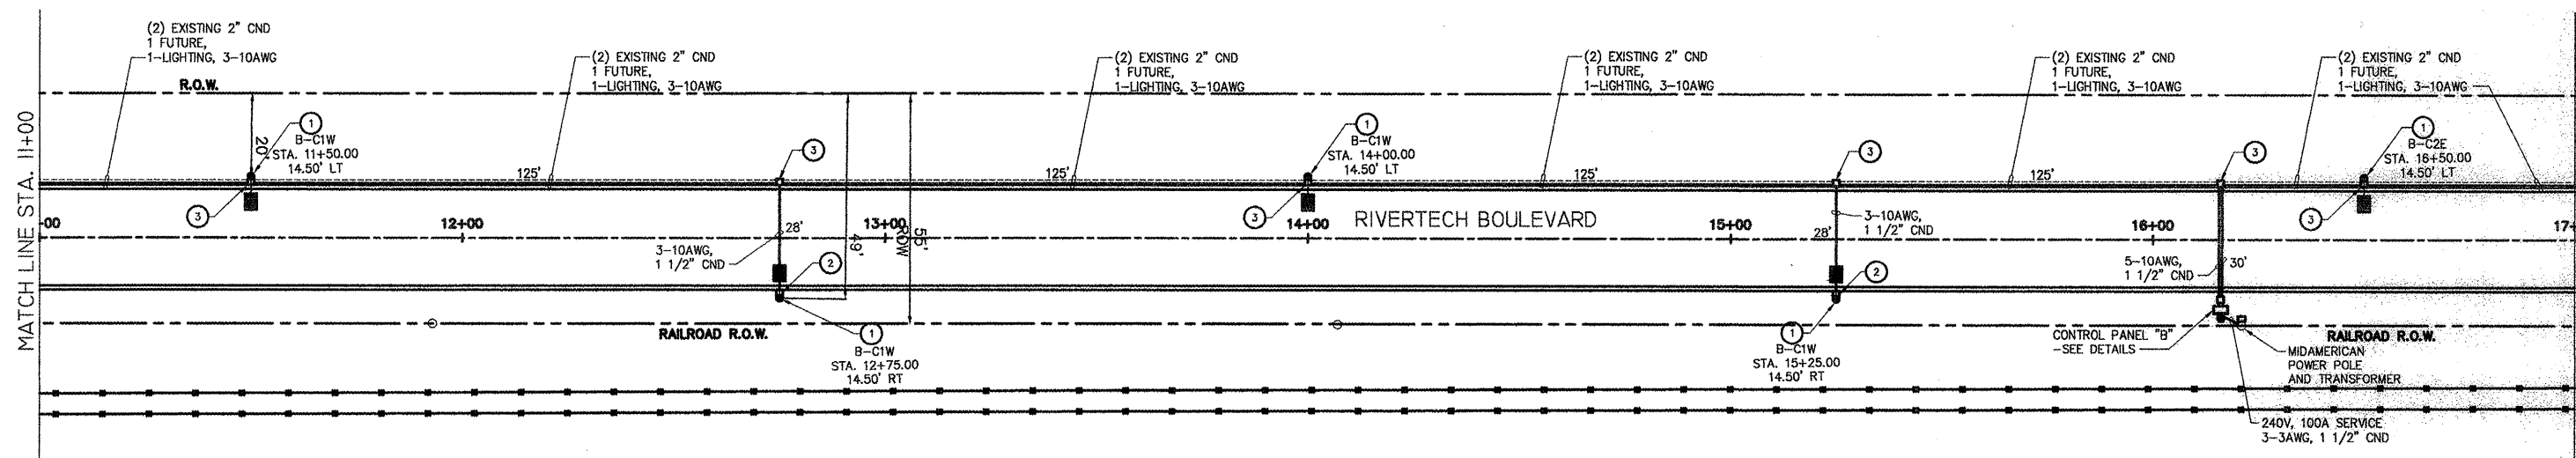

Signature *Martin Valentine*  
Date 3/20/12  
Exp. Date 11/30/13

**CITY OF MOLINE**  
DEPARTMENT OF PUBLIC WORKS - ENGINEERING DIVISION  
3635 4TH AVENUE, MOLINE, IL 61265  
(309) 524-2350  
CITY ENGINEER - SCOTT HINTON, P.E.

**RIVERTECH BOULEVARD**  
STREET LIGHTING PLAN  
STA. 11+00 TO 17+00

Date	Revision

Date <u>2-13-12</u>	Sheet <u>18</u>
Scale <u>1"=20'</u>	of <u>34</u>
Design Engineer <b>SHIVE-HATTERY</b>	Project <b>HFT 239</b>