

CONTRACT NO. 87315

FED. ROAD DIST. NO. ILLINOIS FED. AID PROJECT

* BURNS ROAD WEST - FAU 6212
** 03-00058-01-FP

TYSON ENGINEERING, INC.
CONSULTING CIVIL ENGINEERS
LAND SURVEYORS
DESIGN FIRM LICENSE #184-001136


367 SOUTH SCHUYLER AVENUE
KANKAKEE, ILLINOIS 60901
PHONE (815) 932-7406

This document and the ideas and designs incorporated herein, as an instrument of professional service, is the property of Tyson Engineering Inc. and is not to be used in whole or in part, for any other project without written authorization of Tyson Engineering Inc.

Do not scale drawings. Use dimensions only. Contractor shall be responsible for verifying all dimensions. Information hereon and herein is confidential.

NO.	DATE	BY	DESCRIPTION

CAREER CENTER ROAD
PLAN AND PROFILE
STA. 93+00 TO STA. 104+00

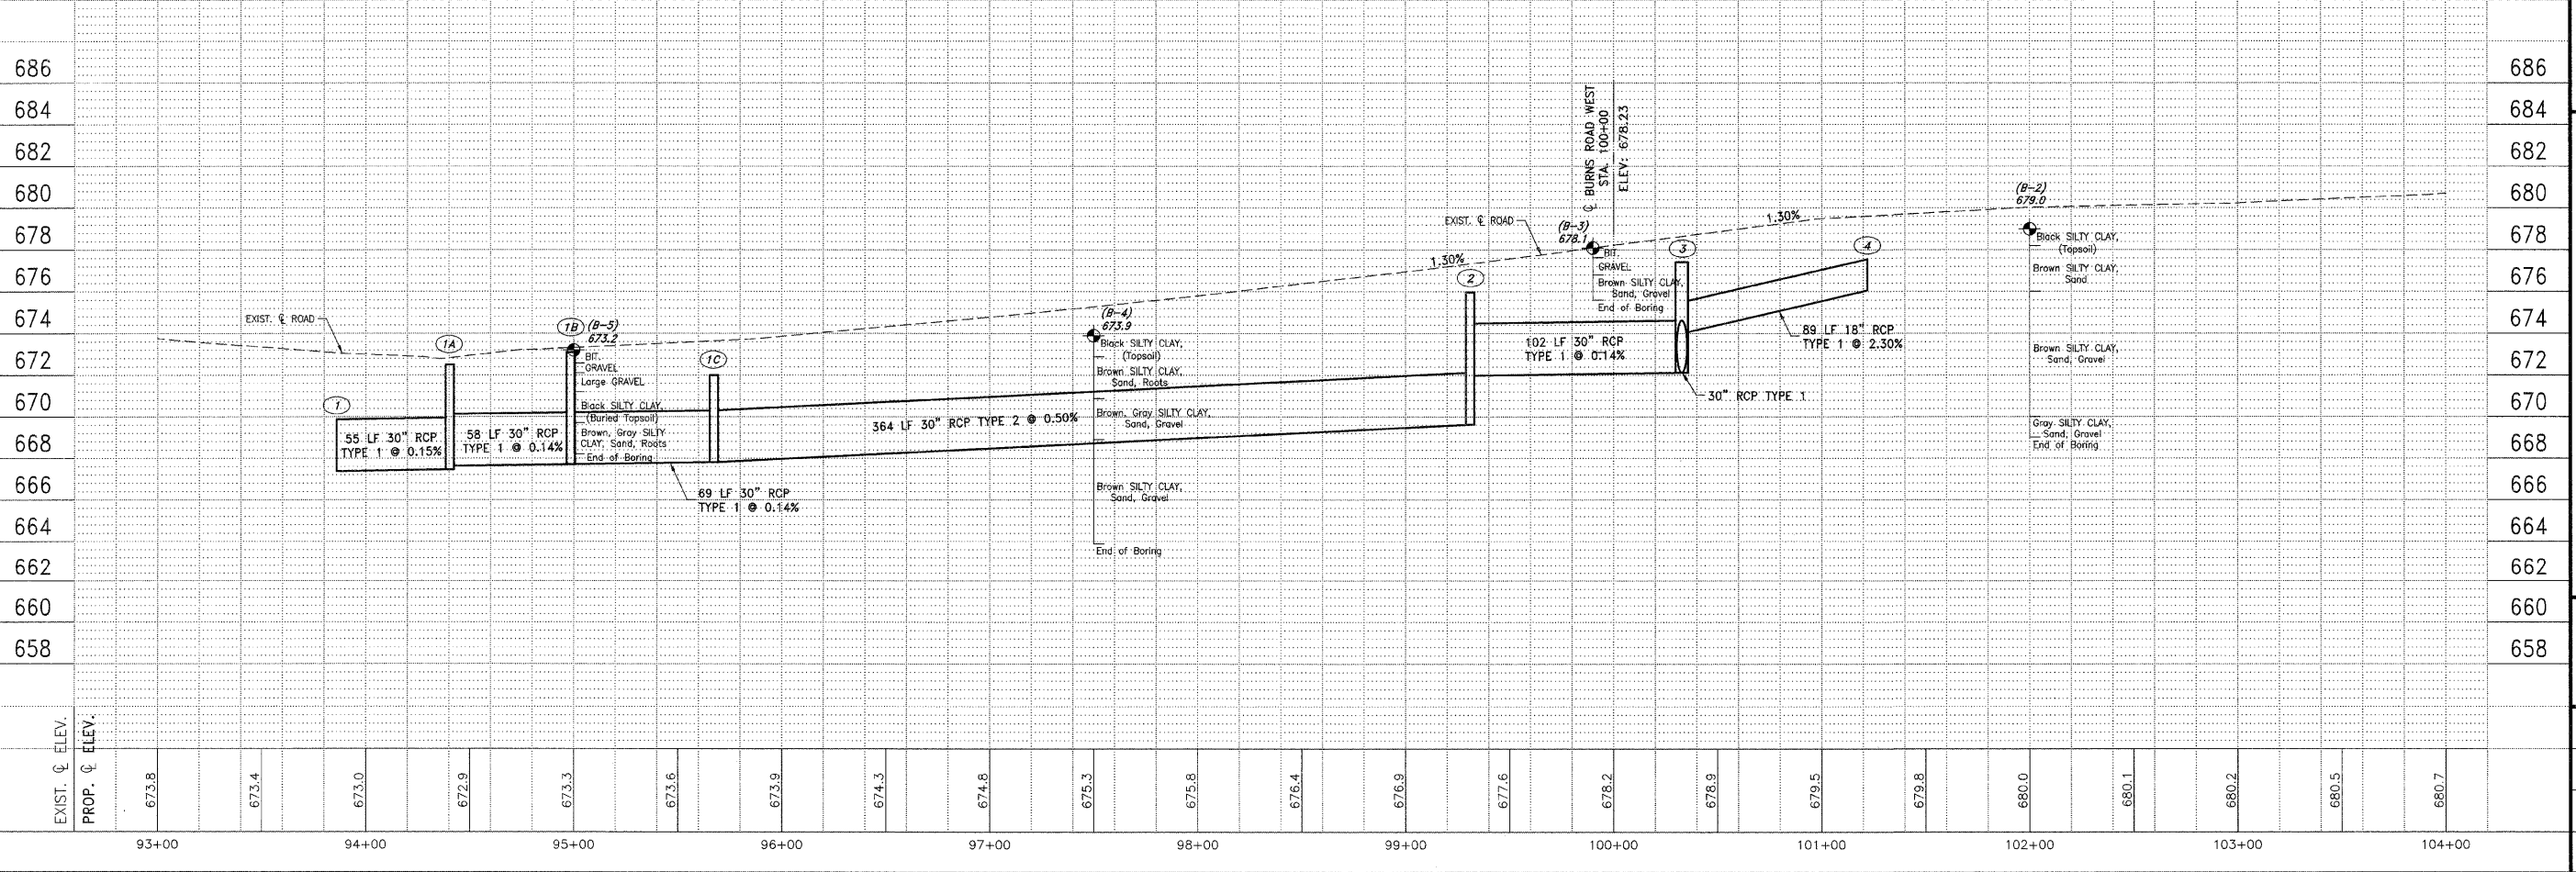

PROPOSED IMPROVEMENTS FOR
BURNS ROAD WEST
FROM CAREER CENTER ROAD
TO BURNING BUSH DRIVE

SECTION
03-00058-01-FP

DATE: 3/23/12	JOB NO. E05055
SCALE: HORIZ.: 1"=40' VERT.: 1"=4'	FILE NO.
DRAWN BY: MRG	SHEET 11
CHECKED BY: SRM	36

3/23/12 10:55:59 AM I:\2010\03-00058-01-FP\03-00058-01-FP.dwg, 11:00 AM, 4/8/2012, 3:51:59 PM