 


UN051

REVISIONS		
NUMBER	BY	DATE




**WILLARD AIRPORT
 UNIVERSITY OF ILLINOIS
 NEW AIRFIELD LIGHTING VAULT
 FOUNDATION PLAN**

© Copyright CMT, Inc.

CMT
 CRAWFORD, MURPHY & TILLY, INC.
 CONSULTING ENGINEERS
 License No. 184-000613

DESIGN BY:	JEL
DRAWN BY:	CMT
CHECKED BY:	JJF
APPROVED BY:	JJF
DATE:	APRIL 20, 2012
JOB No:	11059-03
IL PROJ. NO.	CMI-4100
AIP PROJ. NO.	3-17-0016-XX
SHEET	40 OF 60 SHEETS

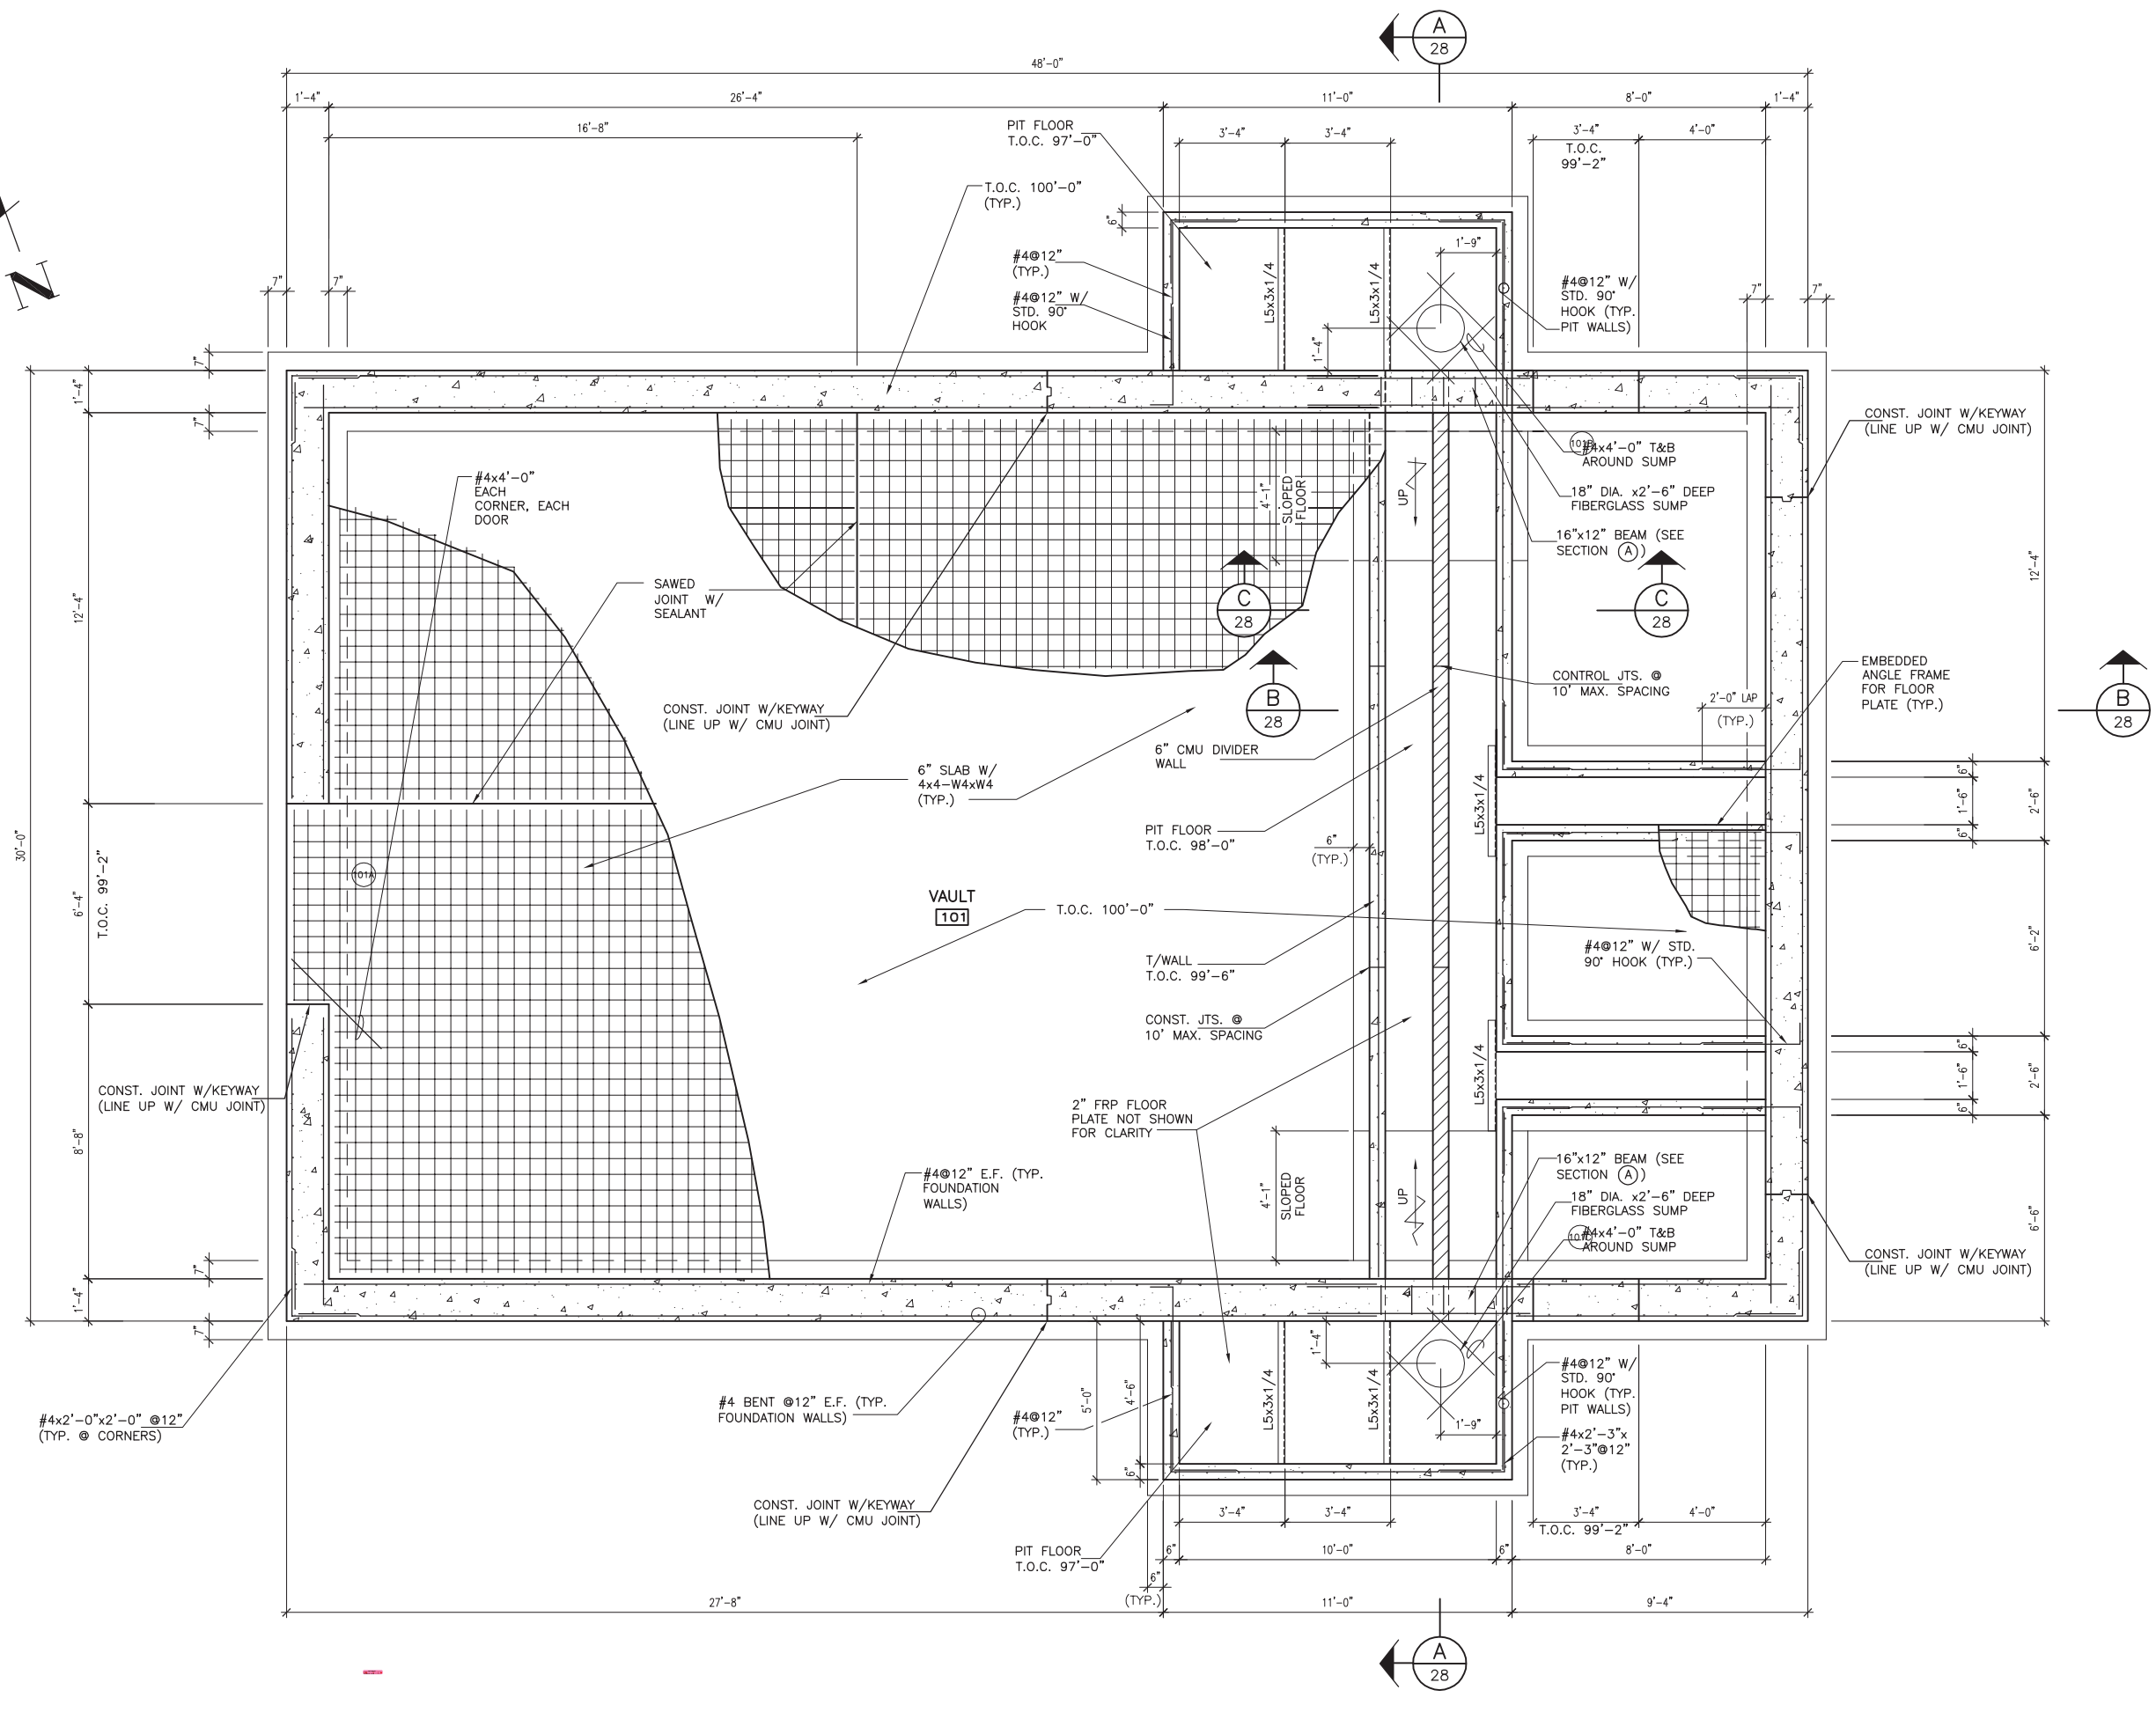

A
28

C
28

B
28

B
28

A
28