


UN051

REVISIONS		
NUMBER	BY	DATE

0 1 2
 THIS BAR IS EQUAL TO 2"
 AT FULL SCALE (34X22).

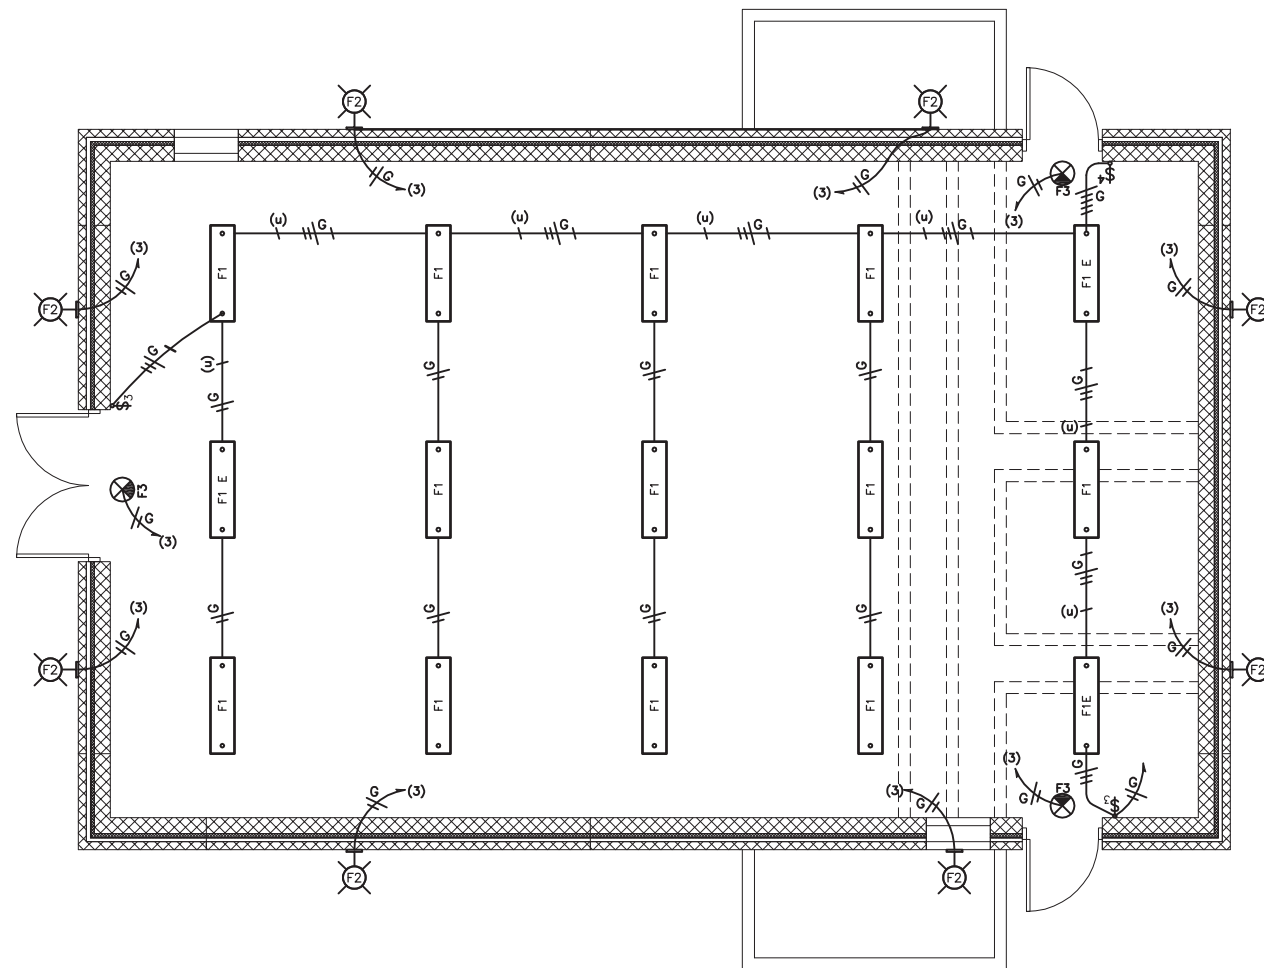

(u) = UNSWITCHED LEG

NEW VAULT LIGHTING PLAN
 SCALE: N.T.S.

LIGHT FIXTURE SCHEDULE				
FIXTURE NO.	MANUFACTURER OR EQUAL	MAKE OR MODEL #	LAMP	LOCATION & MOUNTING
F1	METALUX	4VT2-254DR-120-GL-EBT2-RIF1 WITH CHAIN SUSPENSION KIT	2-54W-T5 FLUOR.	SUSPENDE FROM CEILING TO 12' AFF
F1E	METALUX	4VT2-254DR-120-EM-EBT2-RIF1 WITH EMERGENCY BALLAST AND CHAIN SUSPENSION KIT	2-54W-T5 FLUOR.	SUSPENDE FROM CEILING TO 12' AFF
F2	LUMARK	MPVR-PC-70-120V-LL-PC-UB-U	70W P.S. METAL HALIDE	BUILDING EXTERIOR WALL 10' ABOVE GRADE
F3	SURE-LITES	CX7-70-R-W	LED	EXIT SIGN WALL MOUNT

**WILLARD AIRPORT
 UNIVERSITY OF ILLINOIS**

**NEW AIRFIELD LIGHTING VAULT
 NEW VAULT LIGHTING PLAN**

© Copyright CMT, Inc.
CMT
 CRAWFORD, MURPHY & TILLY, INC.
 CONSULTING ENGINEERS
 License No. 184-000613

DESIGN BY:	CBG
DRAWN BY:	CMT
CHECKED BY:	JEH
APPROVED BY:	JEH
DATE:	APRIL 20, 2012
JOB No:	11059-03
IL. PROJ. NO. CMI-4100 AIP PROJ. NO. 3-17-0016-XX	
SHEET 48 OF 60 SHEETS	