
 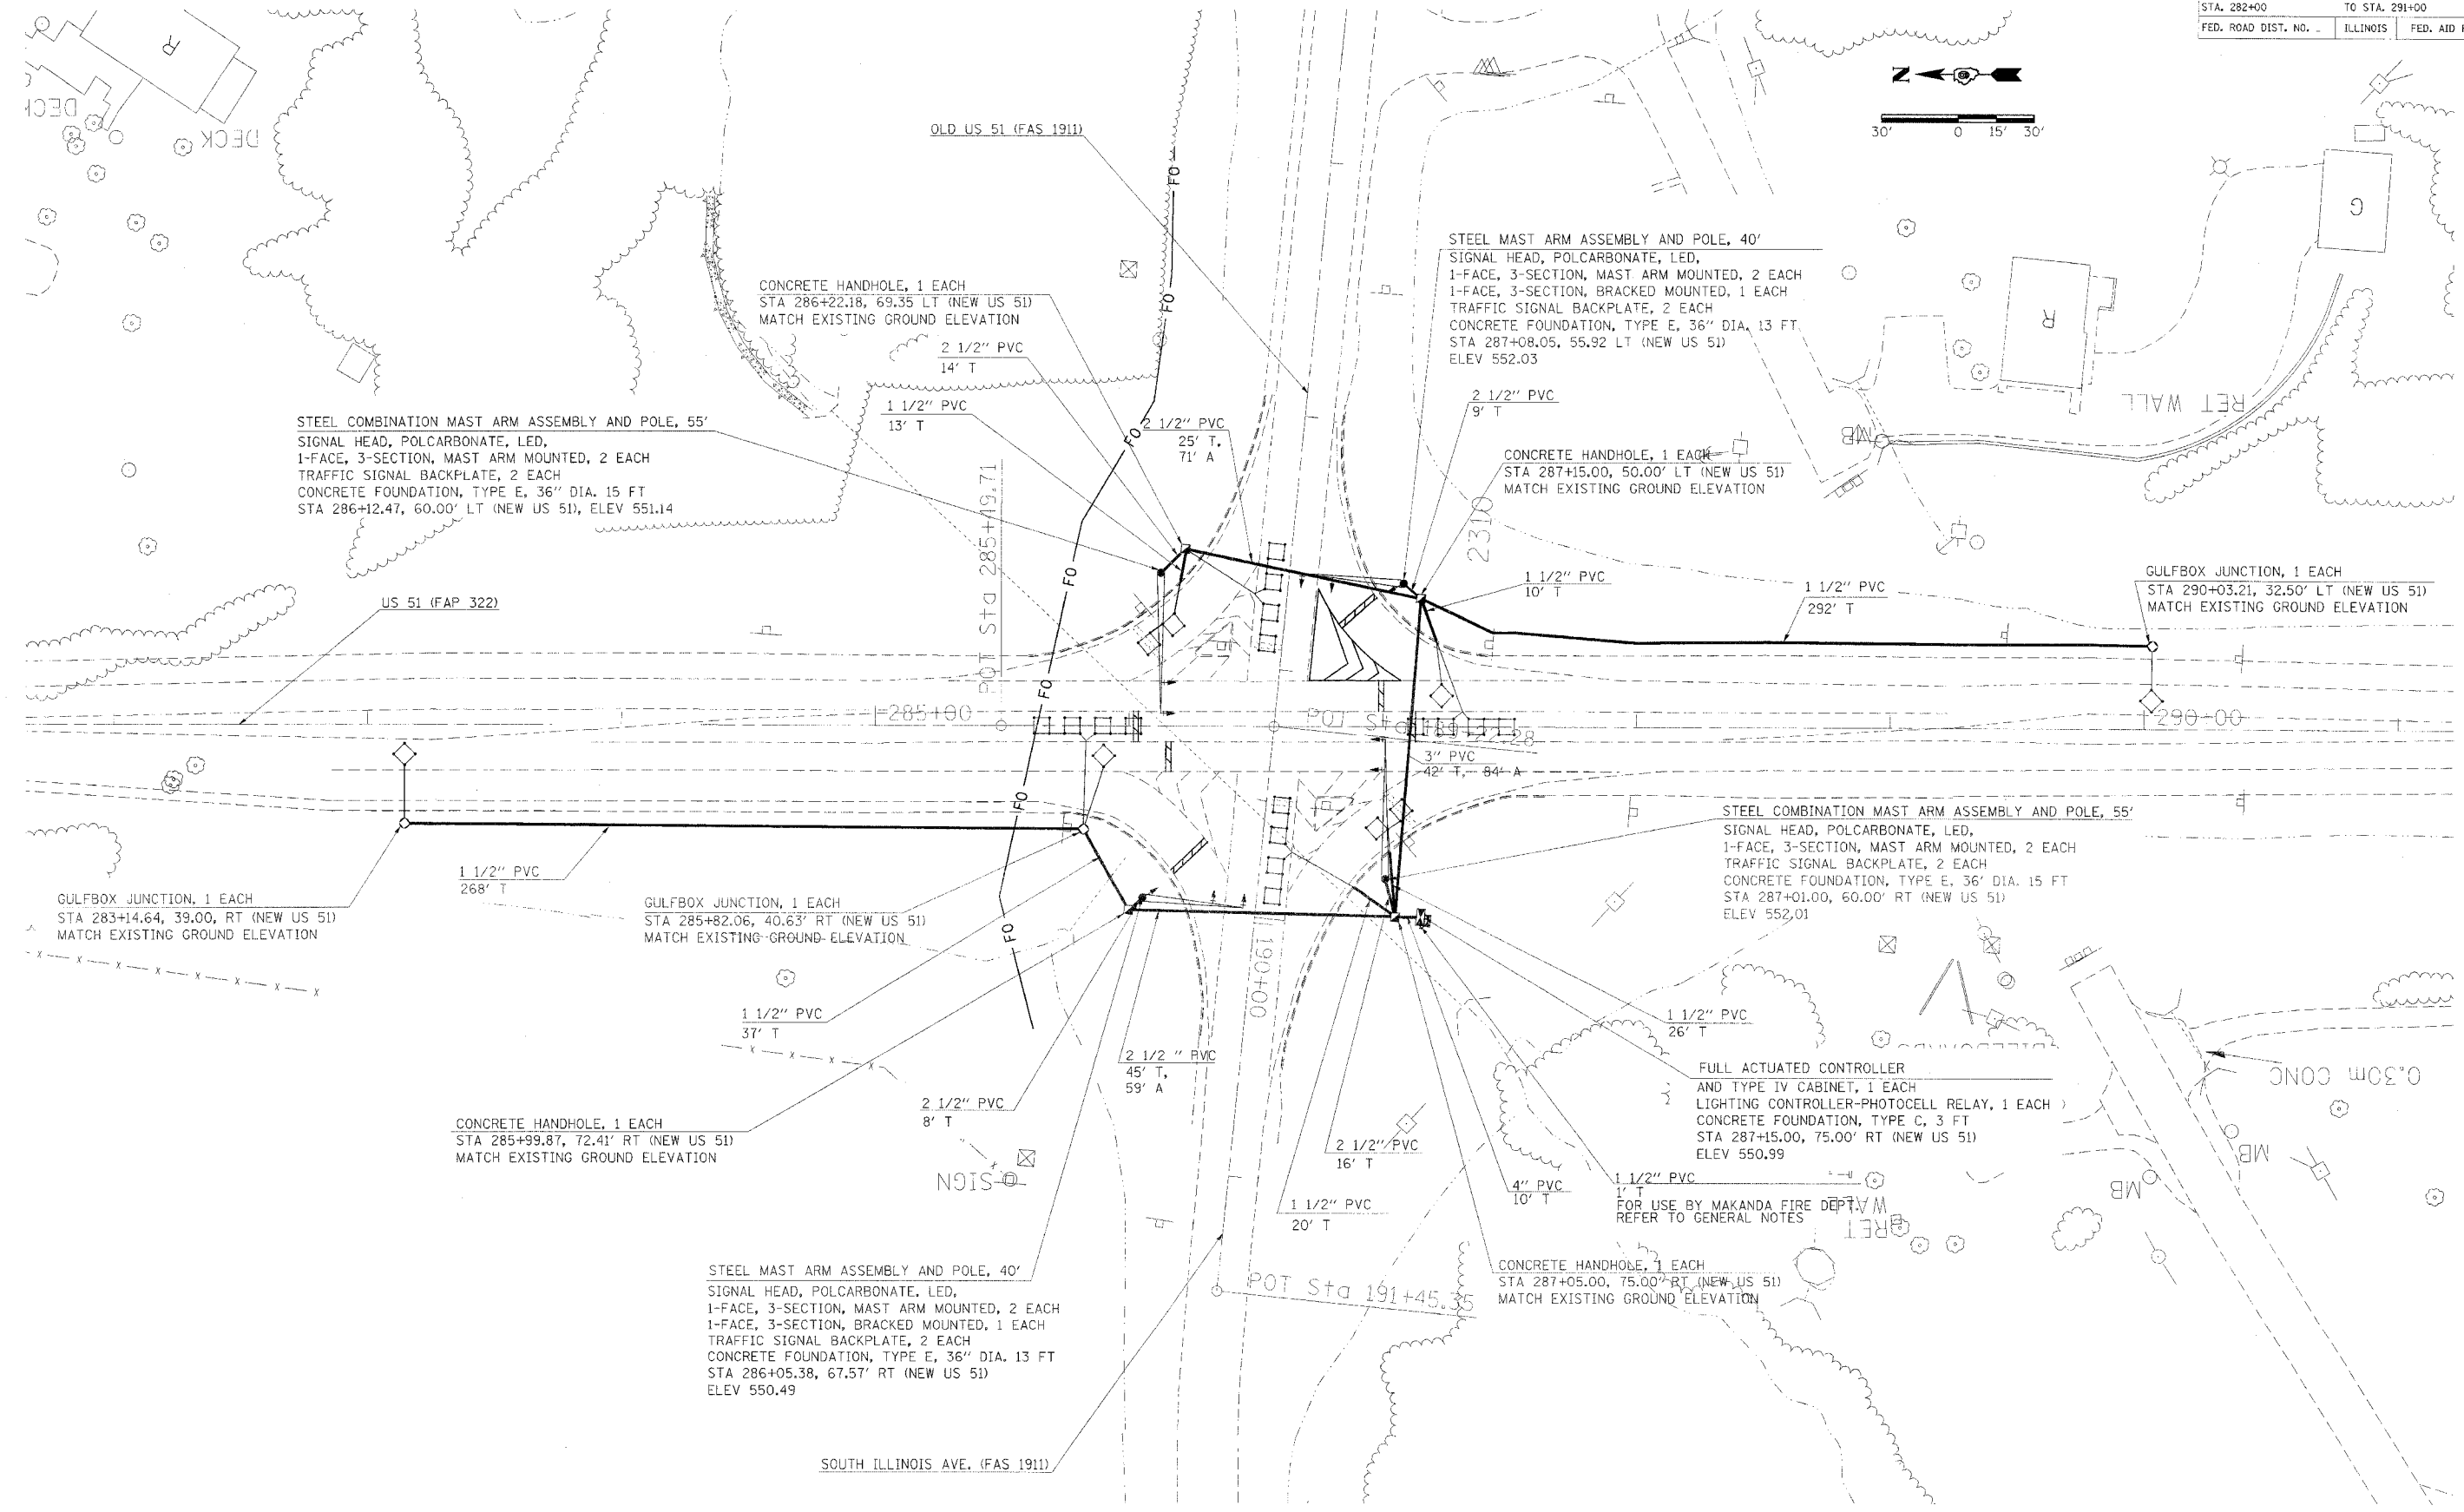


F.A.P. RTE.	SECTION	COUNTY	TOTAL SHEETS	SHEET NO.
322	10 TS	JACKSON	8	5
STA. 282+00		TO STA. 291+00		
FED. ROAD DIST. NO. .		ILLINOIS	FED. AID PROJECT	



3/31/2005
 30,0000 / JN
 willab

TRAFFIC SIGNAL & LIGHTING PLAN