
 


F.A.U. RTE.	SECTION	COUNTY	TOTAL SHEETS	SHEET NO.
3537	5Y-R-4	DUPAGE	248	265
STA.	TO STA.			
FED. ROAD DIST. NO.	ILLINOIS	FED. AID PROJECT		
CONTRACT NO. 62295				

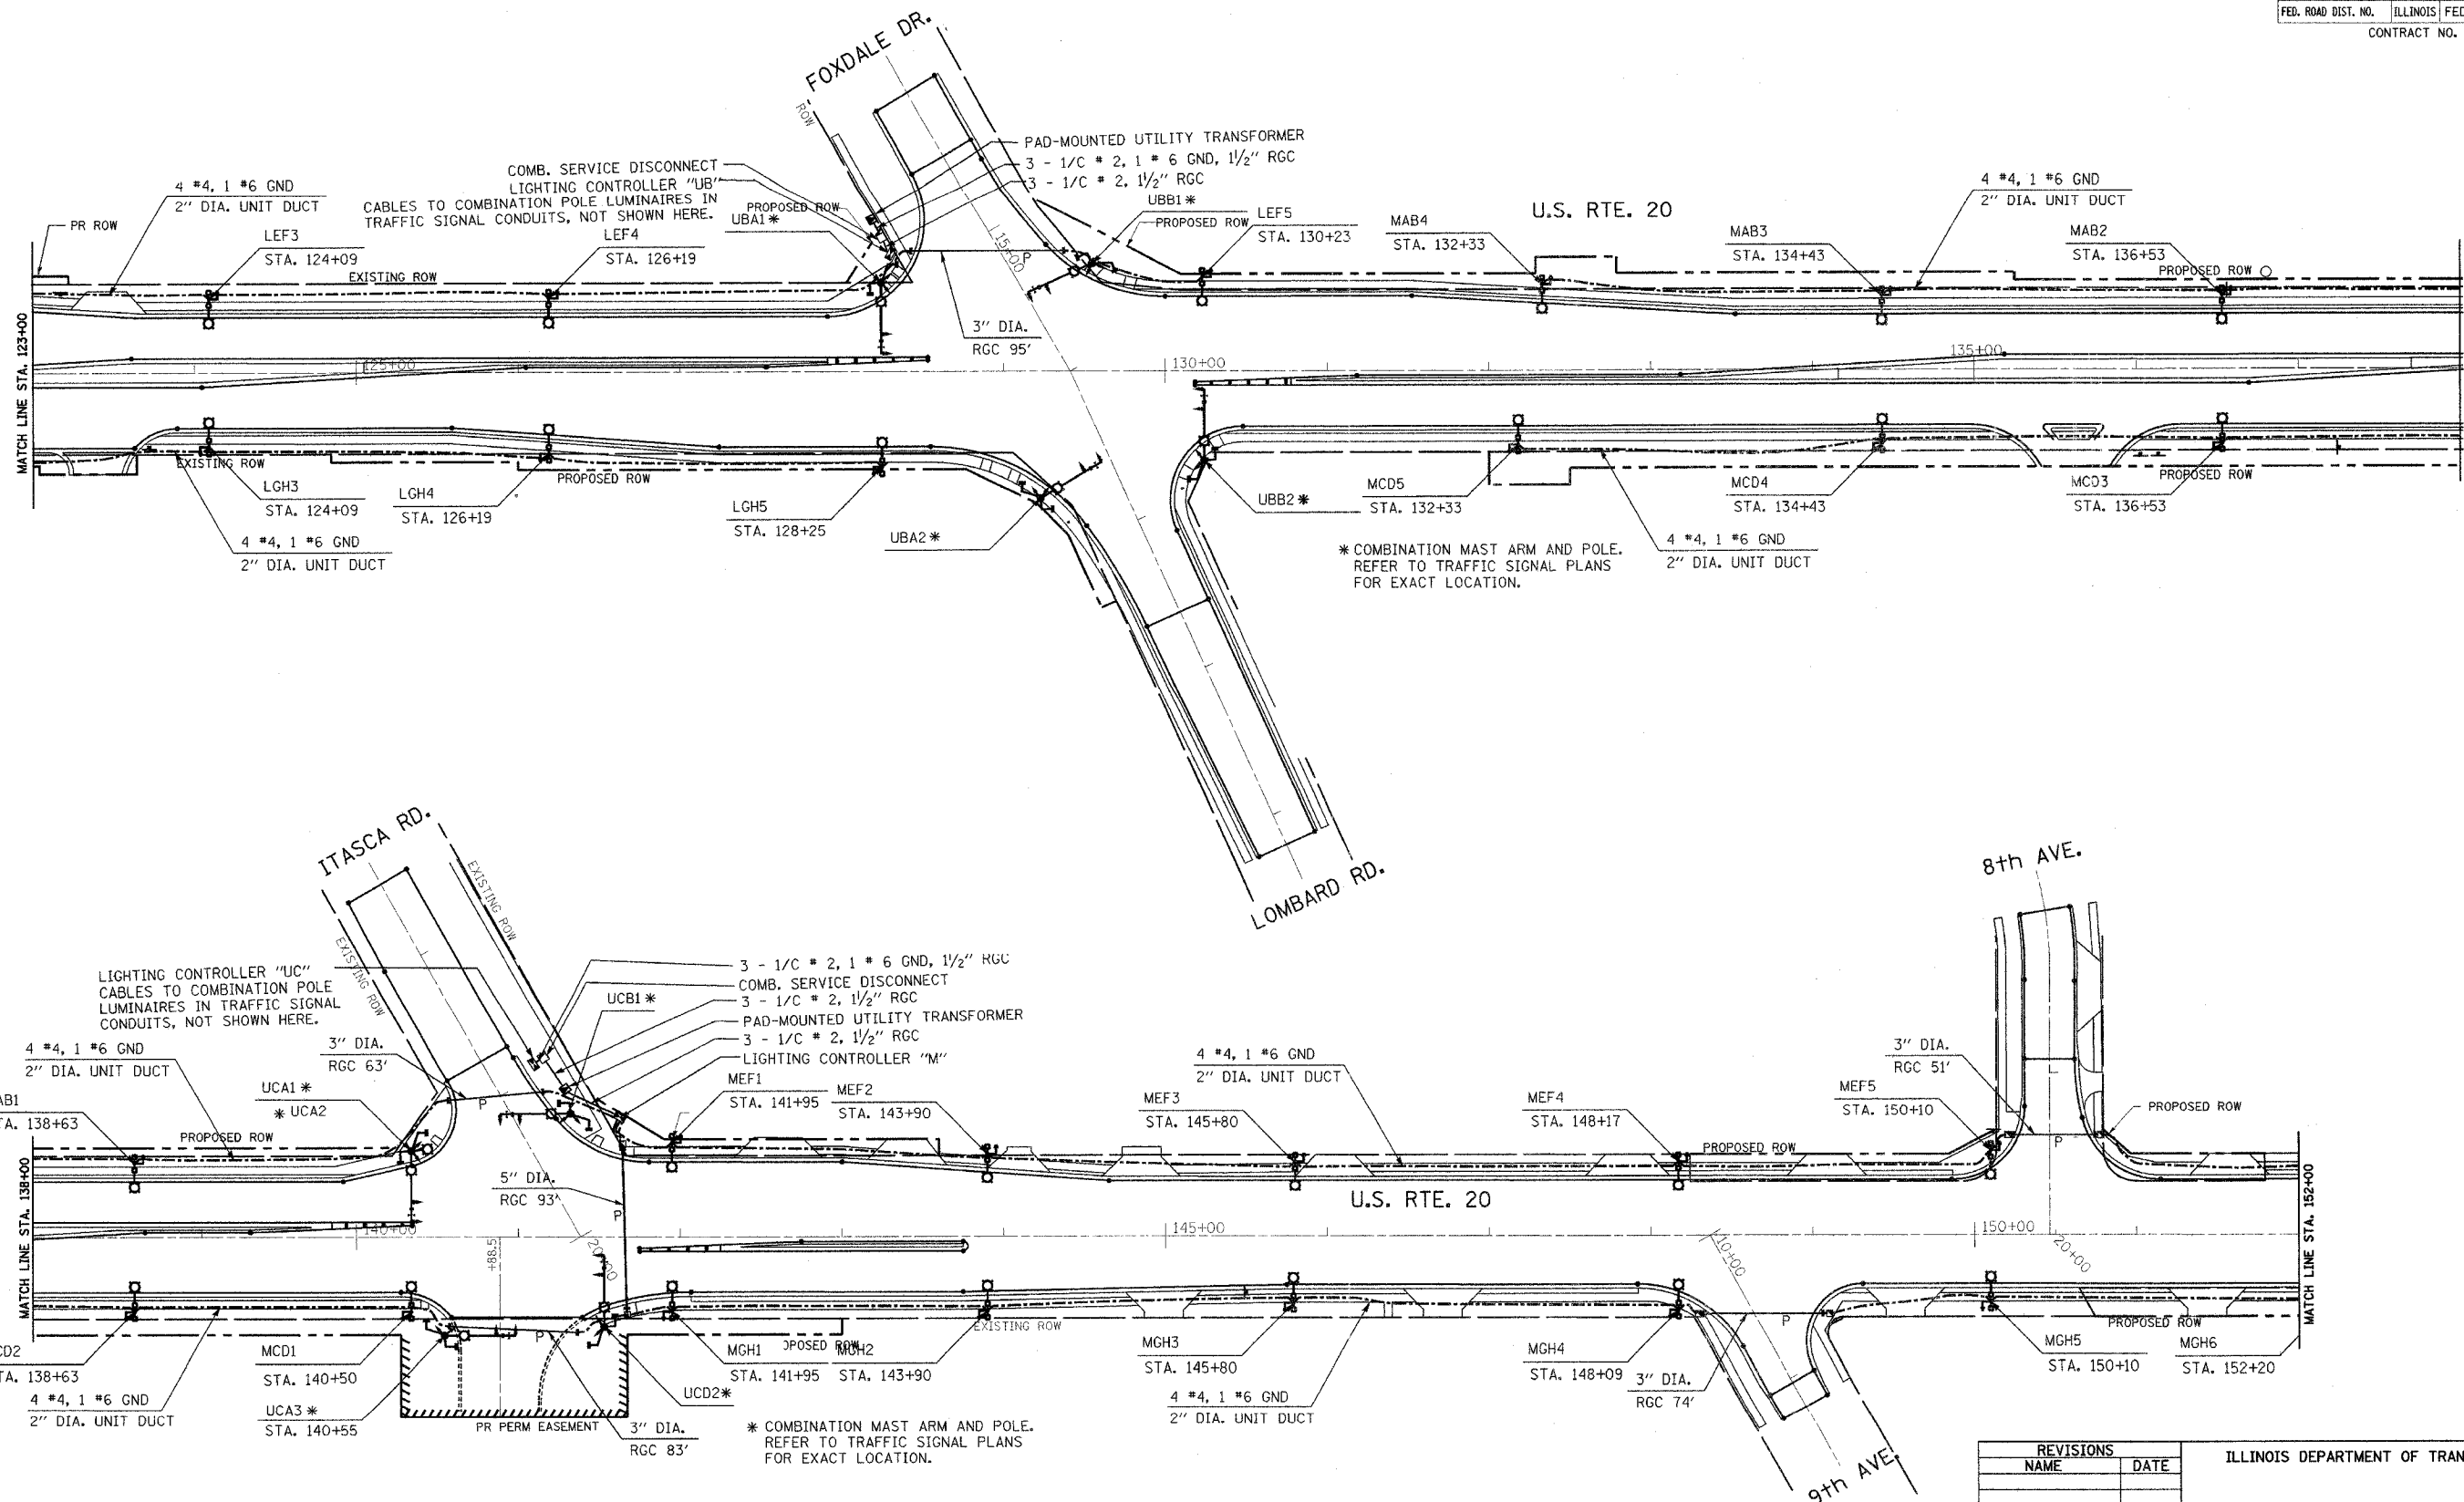

SHEET L-2



REVISIONS	
NAME	DATE

ILLINOIS DEPARTMENT OF TRANSPORTATION

LIGHTING PLAN 2 OF 5
U.S. ROUTE 20 (LAKE ST)

SCALE: 1" = 50'

DATE DATE

DRAWN BY CMW
DESIGNED BY CMW
CHECKED BY DEM

2/10/2005 9:35:32 AM
 I:\projects\1110101010\1110101010.dwg