


| | | | | |
|---------------------|---------------------------|--------|--------------|-----------|
| F.A.U. RTE. | SECTION | COUNTY | TOTAL SHEETS | SHEET NO. |
| 3537 | 5Y-R-4 | DUPAGE | 99 | 26 |
| STA. | TO STA. | | | |
| FED. ROAD DIST. NO. | ILLINOIS FED. AID PROJECT | | | |
| CONTRACT NO. 62295 | | | | |

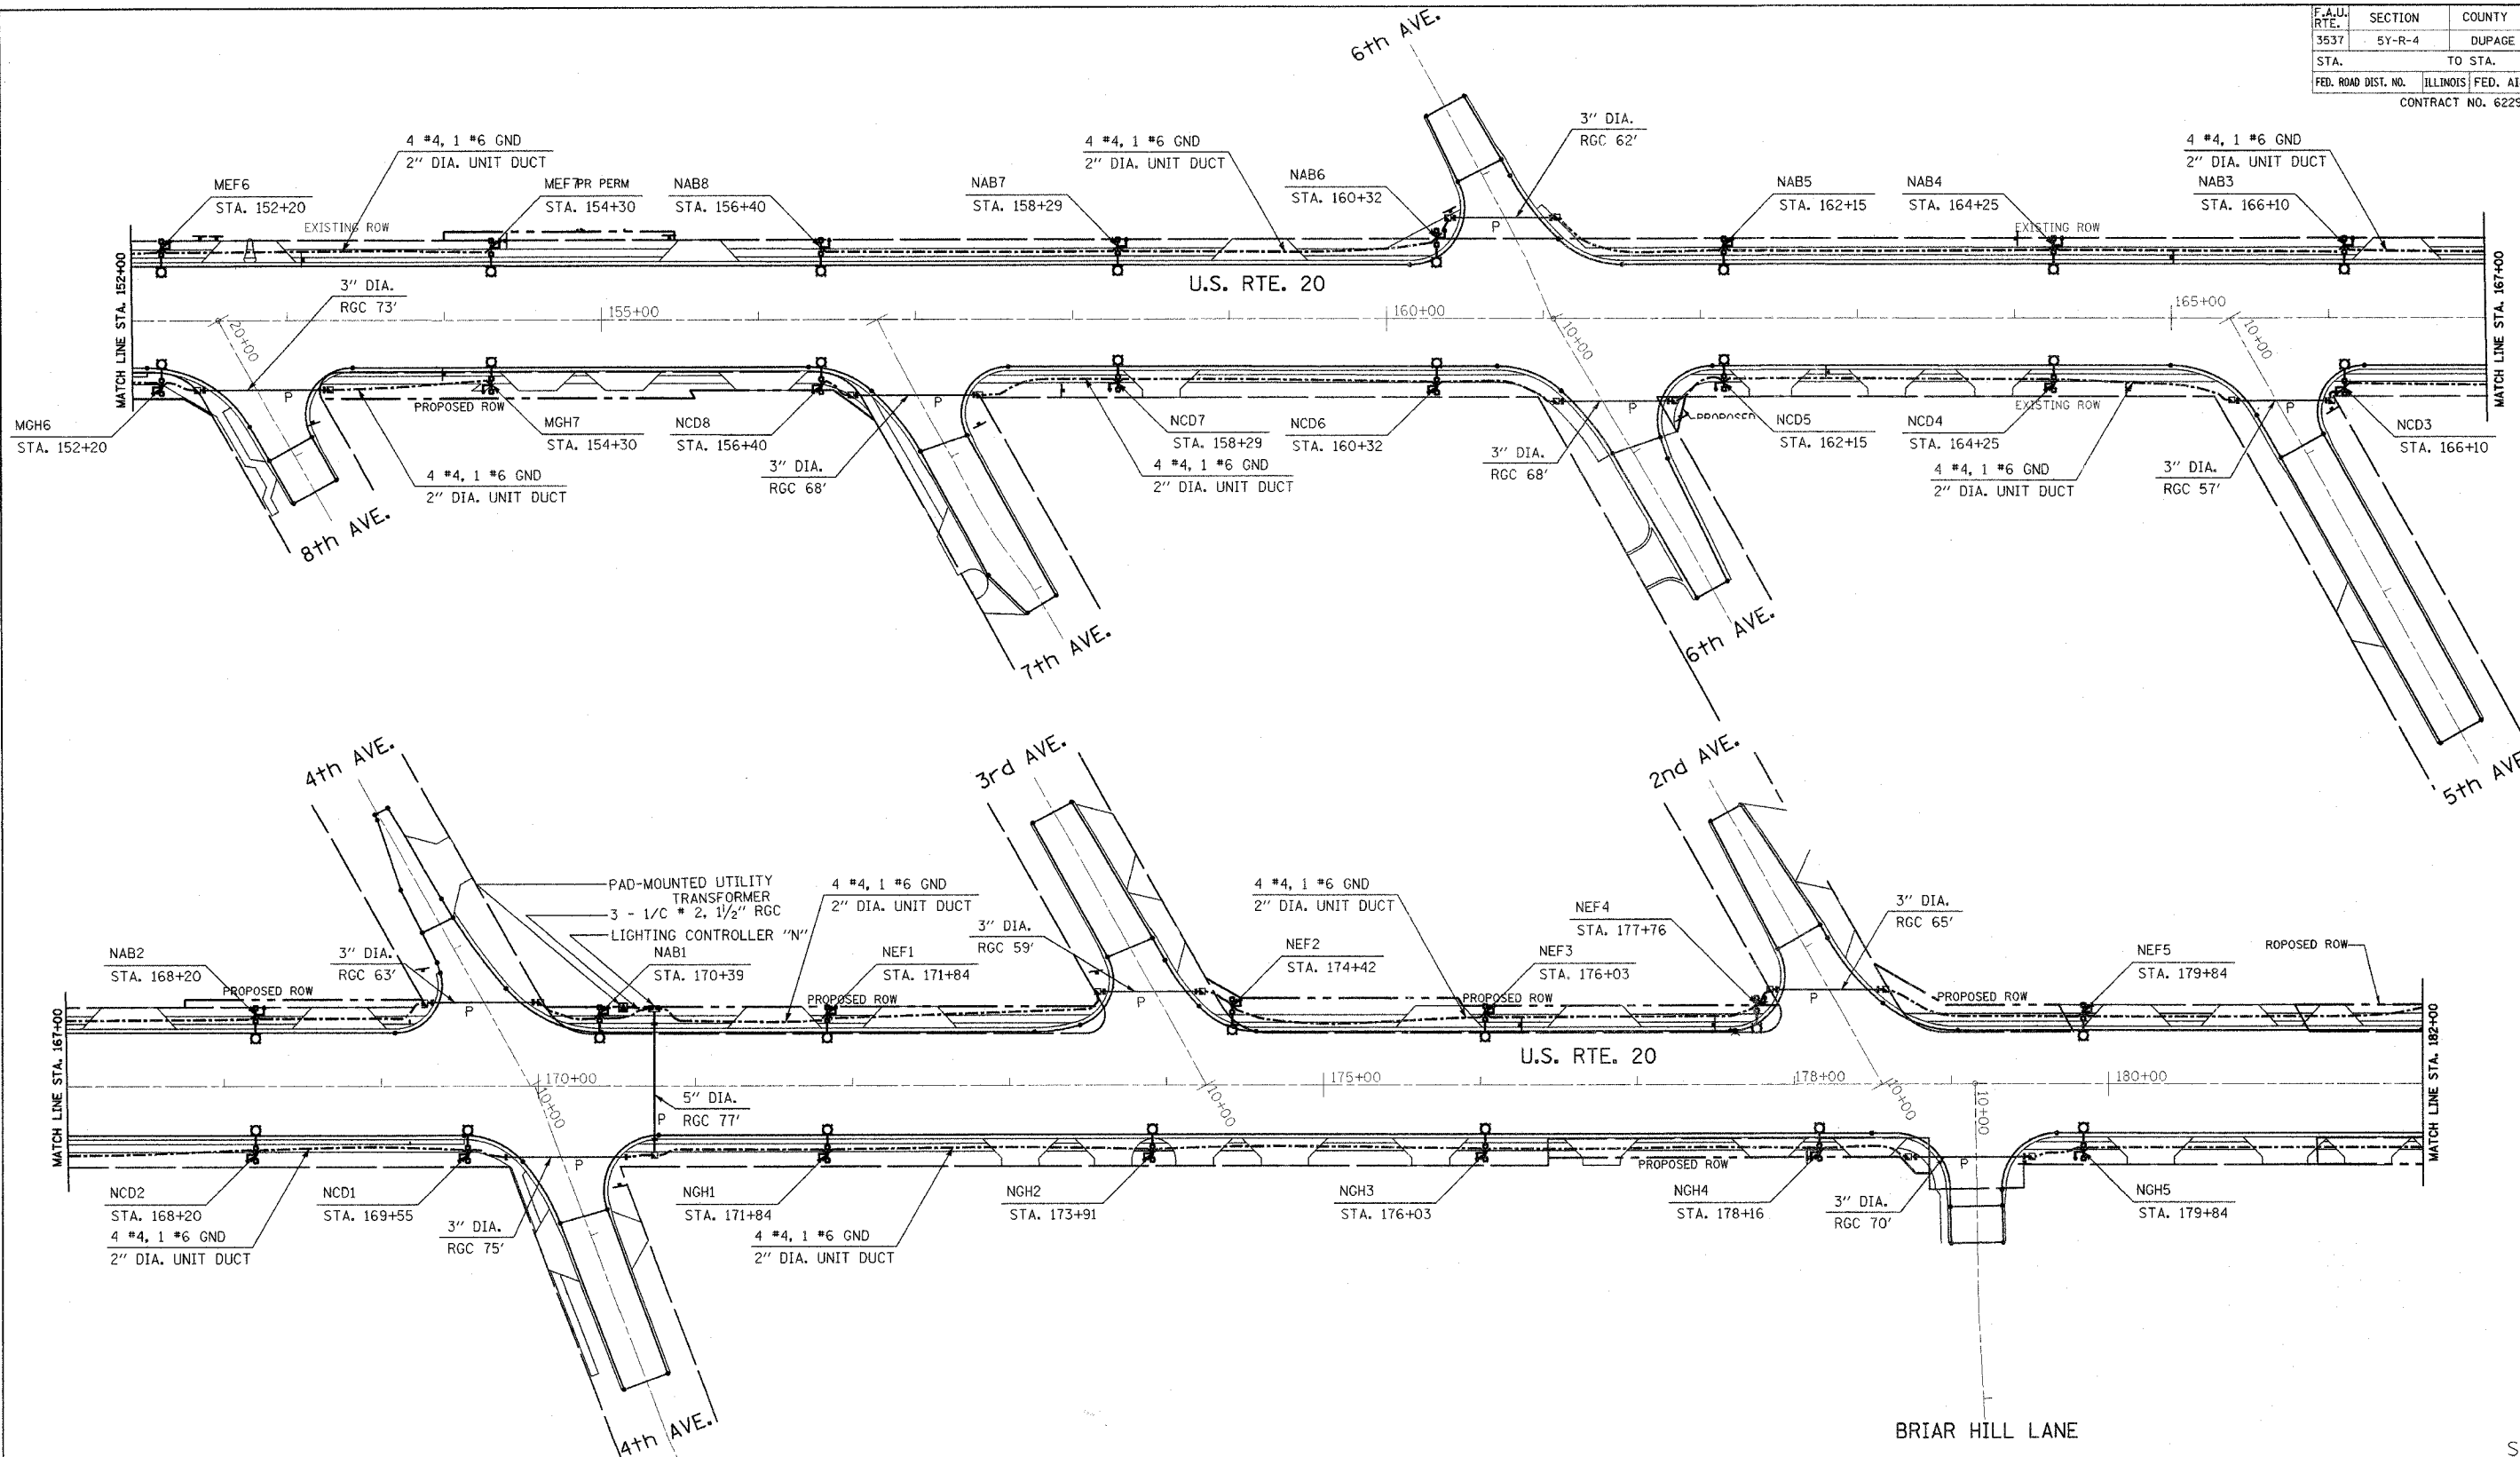

| REVISIONS | |
|-----------|------|
| NAME | DATE |
| | |
| | |
 
ILLINOIS DEPARTMENT OF TRANSPORTATION

LIGHTING PLAN 3 OF 5
U.S. ROUTE 20 (LAKE ST)

SCALE: 1" = 50'

DATE DATE

DRAWN BY CMW
DESIGNED BY CMW
CHECKED BY DEM



SHEET L-3

Copyright © 2008 by CMW, Inc. All rights reserved.