
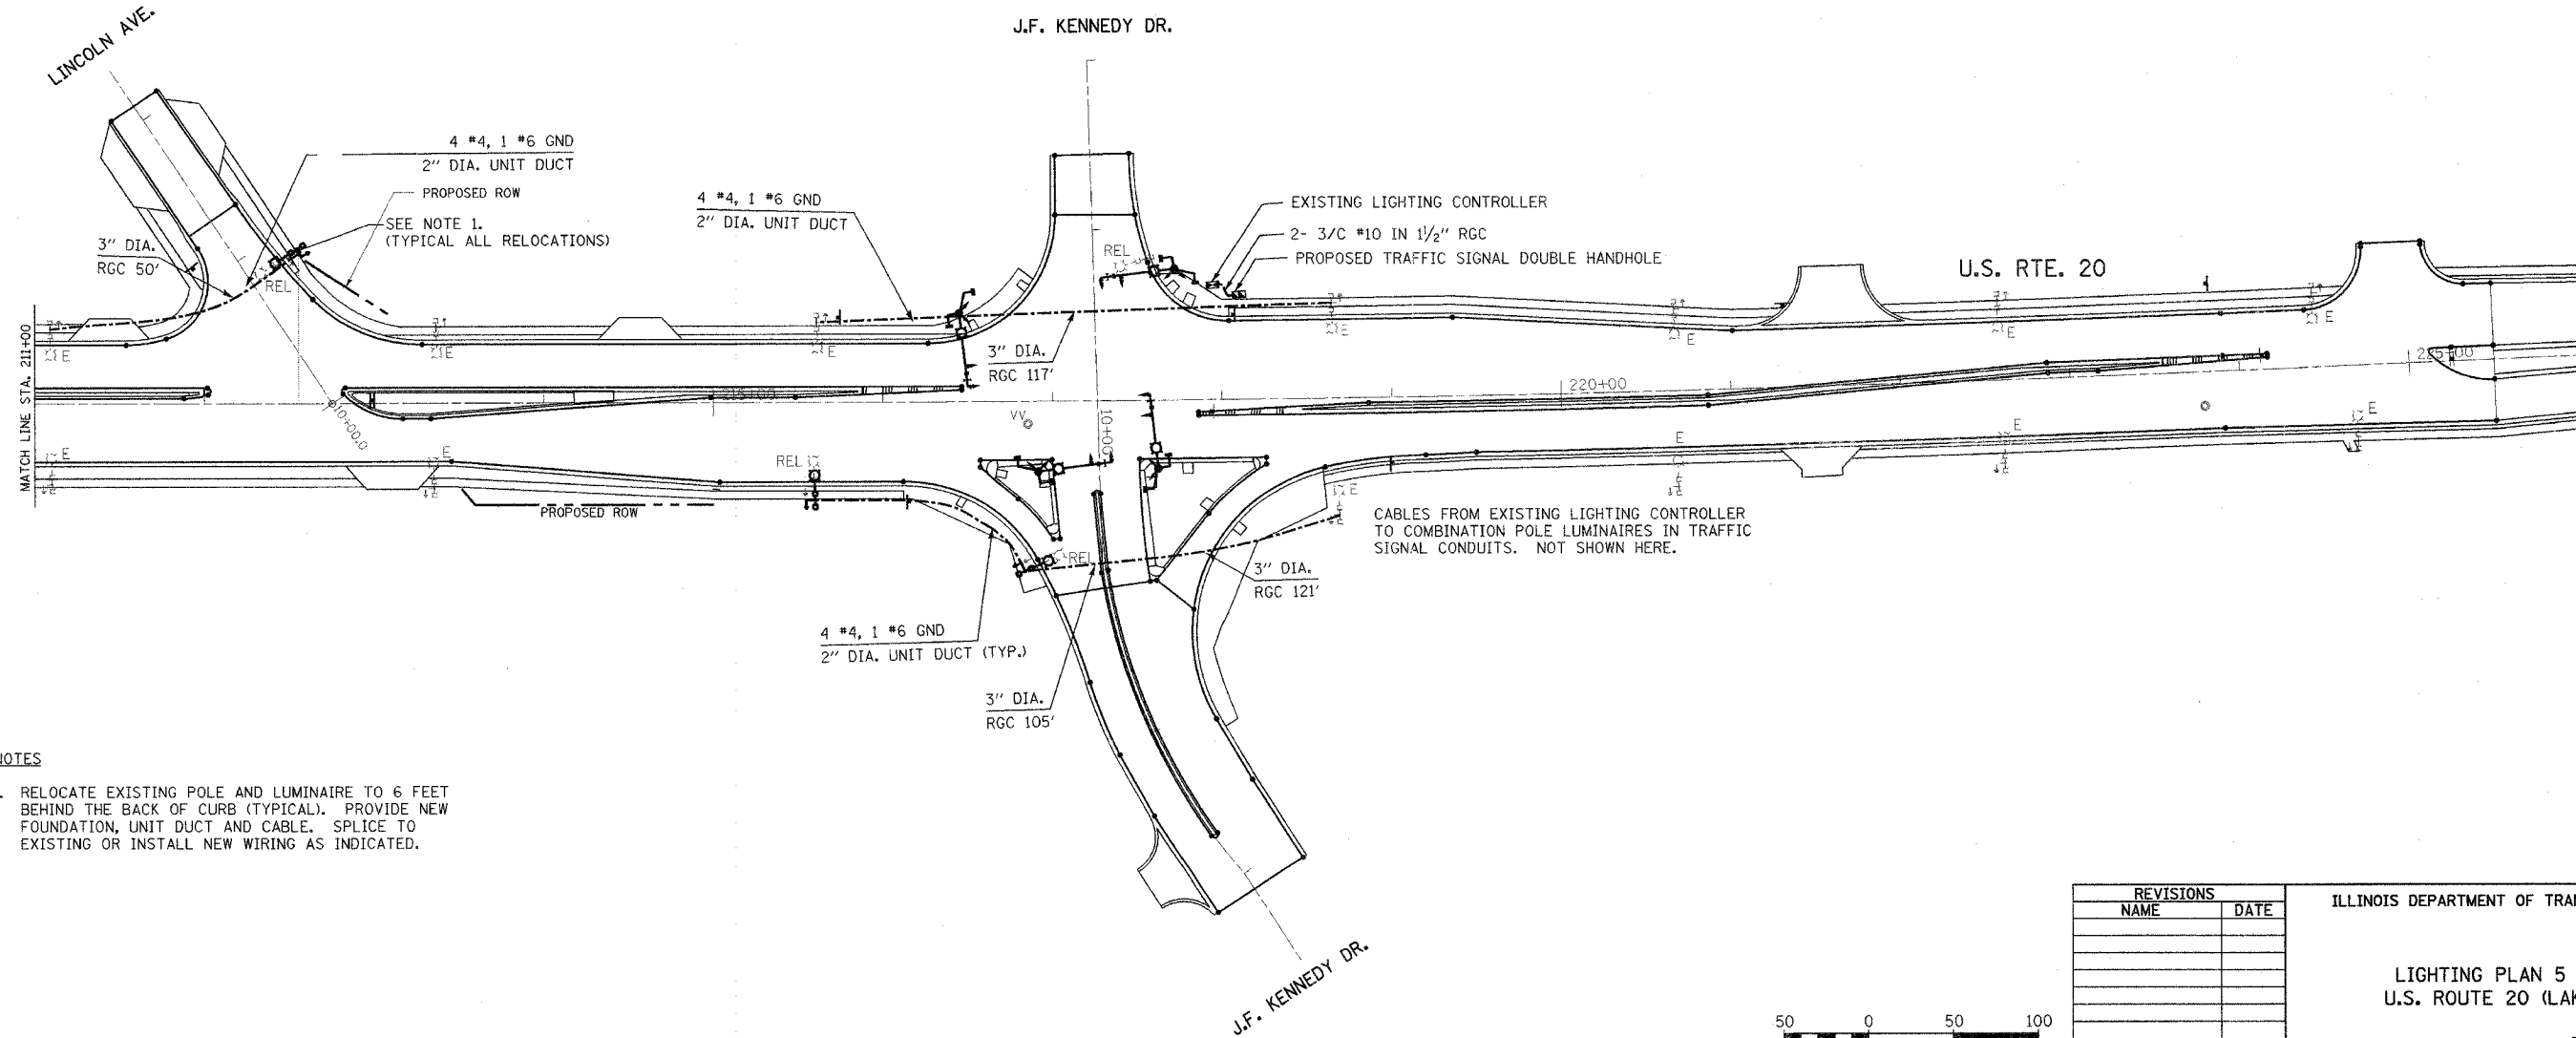


F.A.U. RTE.	SECTION	COUNTY	TOTAL SHEETS	SHEET NO.
3537	5Y-R-4	DUPAGE	397	208
STA.		TO STA.		
FED. ROAD DIST. NO.	ILLINOIS FED. AID PROJECT			
CONTRACT NO. 62295				

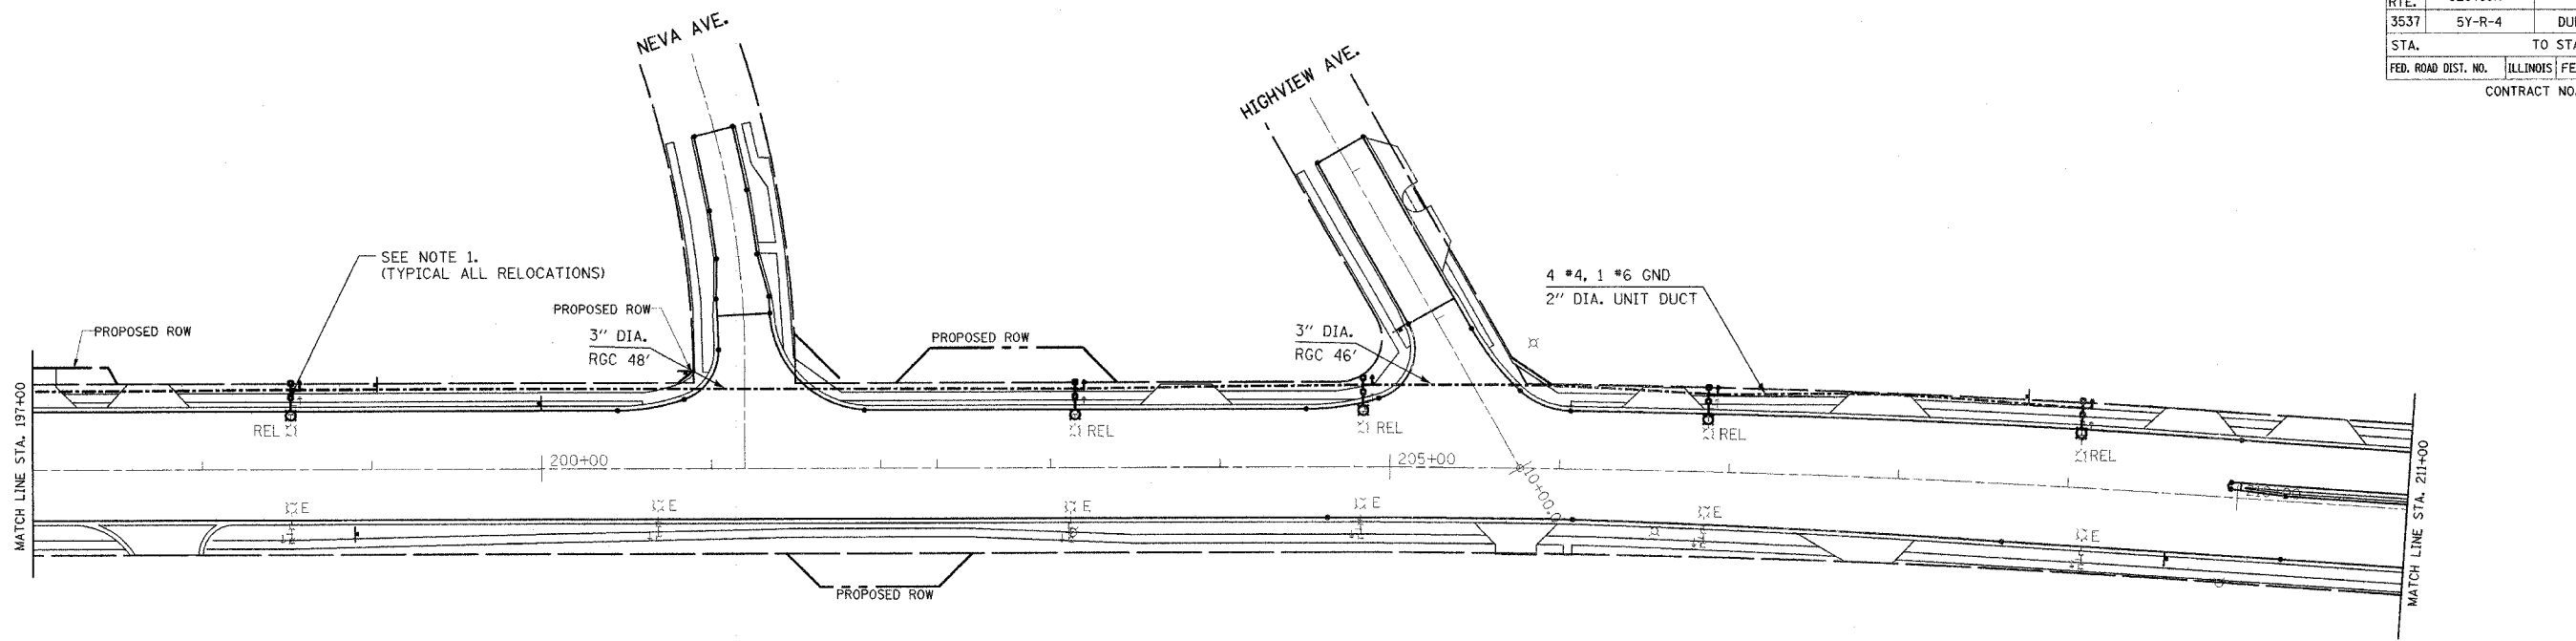

NOTES

1. RELOCATE EXISTING POLE AND LUMINAIRE TO 6 FEET BEHIND THE BACK OF CURB (TYPICAL). PROVIDE NEW FOUNDATION, UNIT DUCT AND CABLE. SPLICE TO EXISTING OR INSTALL NEW WIRING AS INDICATED.

SHEET L-5

REVISIONS	
NAME	DATE

ILLINOIS DEPARTMENT OF TRANSPORTATION

LIGHTING PLAN 5 OF 5
U.S. ROUTE 20 (LAKE ST)

SCALE: 1" = 50'
DATE 03/01/05

DRAWN BY CMW
DESIGNED BY CMW
CHECKED BY DEM



FILES

3/16/2005 8:34:50 AM