

INDEX OF SHEETS

SHEET NO.	DESCRIPTION
1.	TITLE SHEET
2.	SUMMARY OF QUANTITIES OAKTON STREET FROM RIVER DRIVE TO GROSS POINT ROAD
3., 4., 5. & 6.	STANDARD TRAFFIC SIGNAL DESIGN DETAILS
7.	TRAFFIC SIGNAL MODIFICATION PLAN OAKTON STREET AT RIVER DRIVE
8.	CABLE PLAN, PHASE DESIGNATION DIAGRAM, EMERGENCY VEHICLE PREEMPTION SEQUENCE AND SCHEDULE OF QUANTITIES OAKTON STREET AT RIVER DRIVE
9.	TRAFFIC SIGNAL MODIFICATION PLAN OAKTON STREET AT LEHIGH AVENUE
10.	CABLE PLAN AND SCHEDULE OF QUANTITIES OAKTON STREET AT LEHIGH AVENUE
11.	SEQUENCE OF OPERATION, RAILROAD PREEMPTION SEQUENCE OF OPERATION AND EMERGENCY VEHICLE PREEMPTION SEQUENCE OAKTON STREET AT LEHIGH AVENUE
12.	TRAFFIC SIGNAL MODIFICATION AND REMOVAL PLAN OAKTON STREET AT AUSTIN AVENUE
13.	CABLE PLAN, PHASE DESIGNATION DIAGRAM AND SCHEDULE OF QUANTITIES OAKTON STREET AT AUSTIN AVENUE
14.	TRAFFIC SIGNAL MODIFICATION AND REMOVAL PLAN OAKTON STREET AT MENARD AVENUE
15.	CABLE PLAN, PHASE DESIGNATION DIAGRAM AND SCHEDULE OF QUANTITIES OAKTON STREET AT MENARD AVENUE
16.	TRAFFIC SIGNAL MODIFICATION AND REMOVAL PLAN OAKTON STREET AT GROSS POINT ROAD
17.	CABLE PLAN AND SCHEDULE OF QUANTITIES OAKTON STREET AT GROSS POINT ROAD
18. & 19.	INTERCONNECT PLAN OAKTON STREET FROM RIVER DRIVE TO GROSS POINT ROAD
20.	INTERCONNECT SCHEMATIC OAKTON STREET FROM RIVER DRIVE TO GROSS POINT ROAD

STATE OF ILLINOIS
DEPARTMENT OF TRANSPORTATION
DIVISION OF HIGHWAYS

PLANS FOR PROPOSED
FEDERAL AID HIGHWAY

SCALES { PLAN 1" = 20' AND 1" = 50'
 PROFILE HORIZ. N.A.
 PROFILE VERT. N.A.
 CROSS SECTION N.A.

DISTRICT 1

CONGESTION MITIGATION AIR QUALITY
FIBER OPTIC COMMUNICATIONS NETWORK

OAKTON STREET
FROM RIVER DRIVE TO GROSS POINT ROAD
F.A.U. ROUTE 1332
SECTION 2004-022TS
C-91-175-04


F.A.U. RTE.	SECTION	COUNTY	TOTAL SHEETS	SHEET NO.
1332	2004-022TS	COOK	20	1
STA.		TO STA.		
FED. ROAD DIST. NO.		ILLINOIS FED. AID PROJECT		
D-91-175-04				




STANDARD DRAWINGS

701006	701011	701101	701301	702001
424001	720001	813001	814001	814006
857001	877001	877006	877011	878001
880001	880006	886001	805001	
701201	701316	701321	701406	701501
701502	701606	701601	701701	701801

NOTE: STANDARD DRAWINGS REQUIRED (CIRCLED).

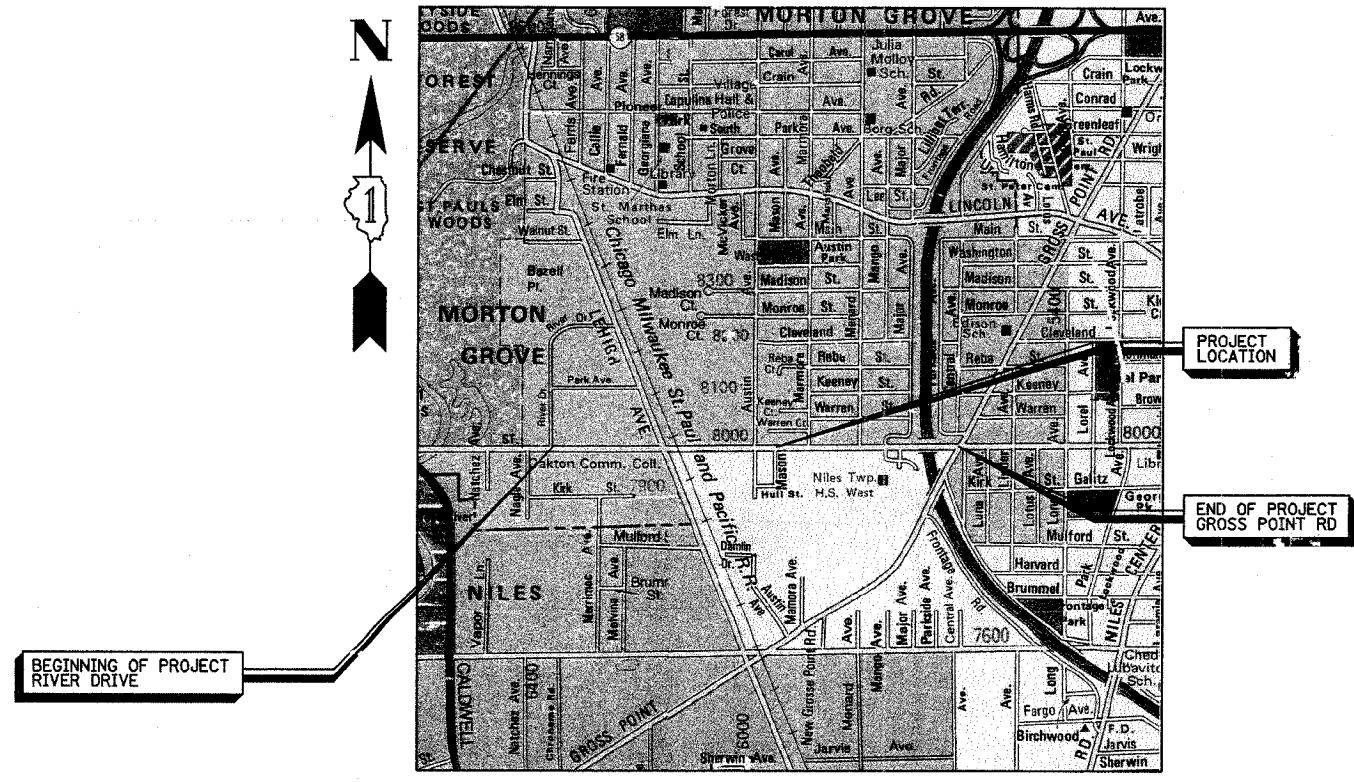

COOK COUNTY - NILES TOWNSHIP

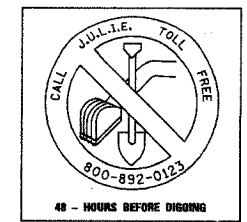

STATE OF ILLINOIS
DEPARTMENT OF TRANSPORTATION
DIVISION OF HIGHWAYS

SUBMITTED March 14 20 05
Deann M. O'Keefe
 DEPUTY DIRECTOR OF HIGHWAYS, REGION ENGINEER

May 13, 2005
Mike Hine
 ENGINEER OF DESIGN AND ENVIRONMENT

May 13, 2005
Victor Maden
 DIRECTOR OF HIGHWAYS, CHIEF ENGINEER

PRINTED BY THE AUTHORITY
OF THE STATE OF ILLINOIS

BUREAU OF TRAFFIC: TERRY RAMMISCHER / DARYLE DREW 847-705-4420

CONTRACT NO. 62741

PREPARED BY: Terry Rammischer 3/14/05
 TRAFFIC ENGINEER DATE