


DATE TIME
DESIGNER
USER

CONTRACT NO. 62871

F.A. RTE.	SECTION	COUNTY	TOTAL SHEETS	SHEET NO.
290	0305-302K-L-3	COOK	65	15
STA.		TO STA.		
FED. ROAD DIST. NO.		ILLINOIS FED. AID PROJECT		




MATCHLINE (FOR CONTINUATION SEE SHEET E1)

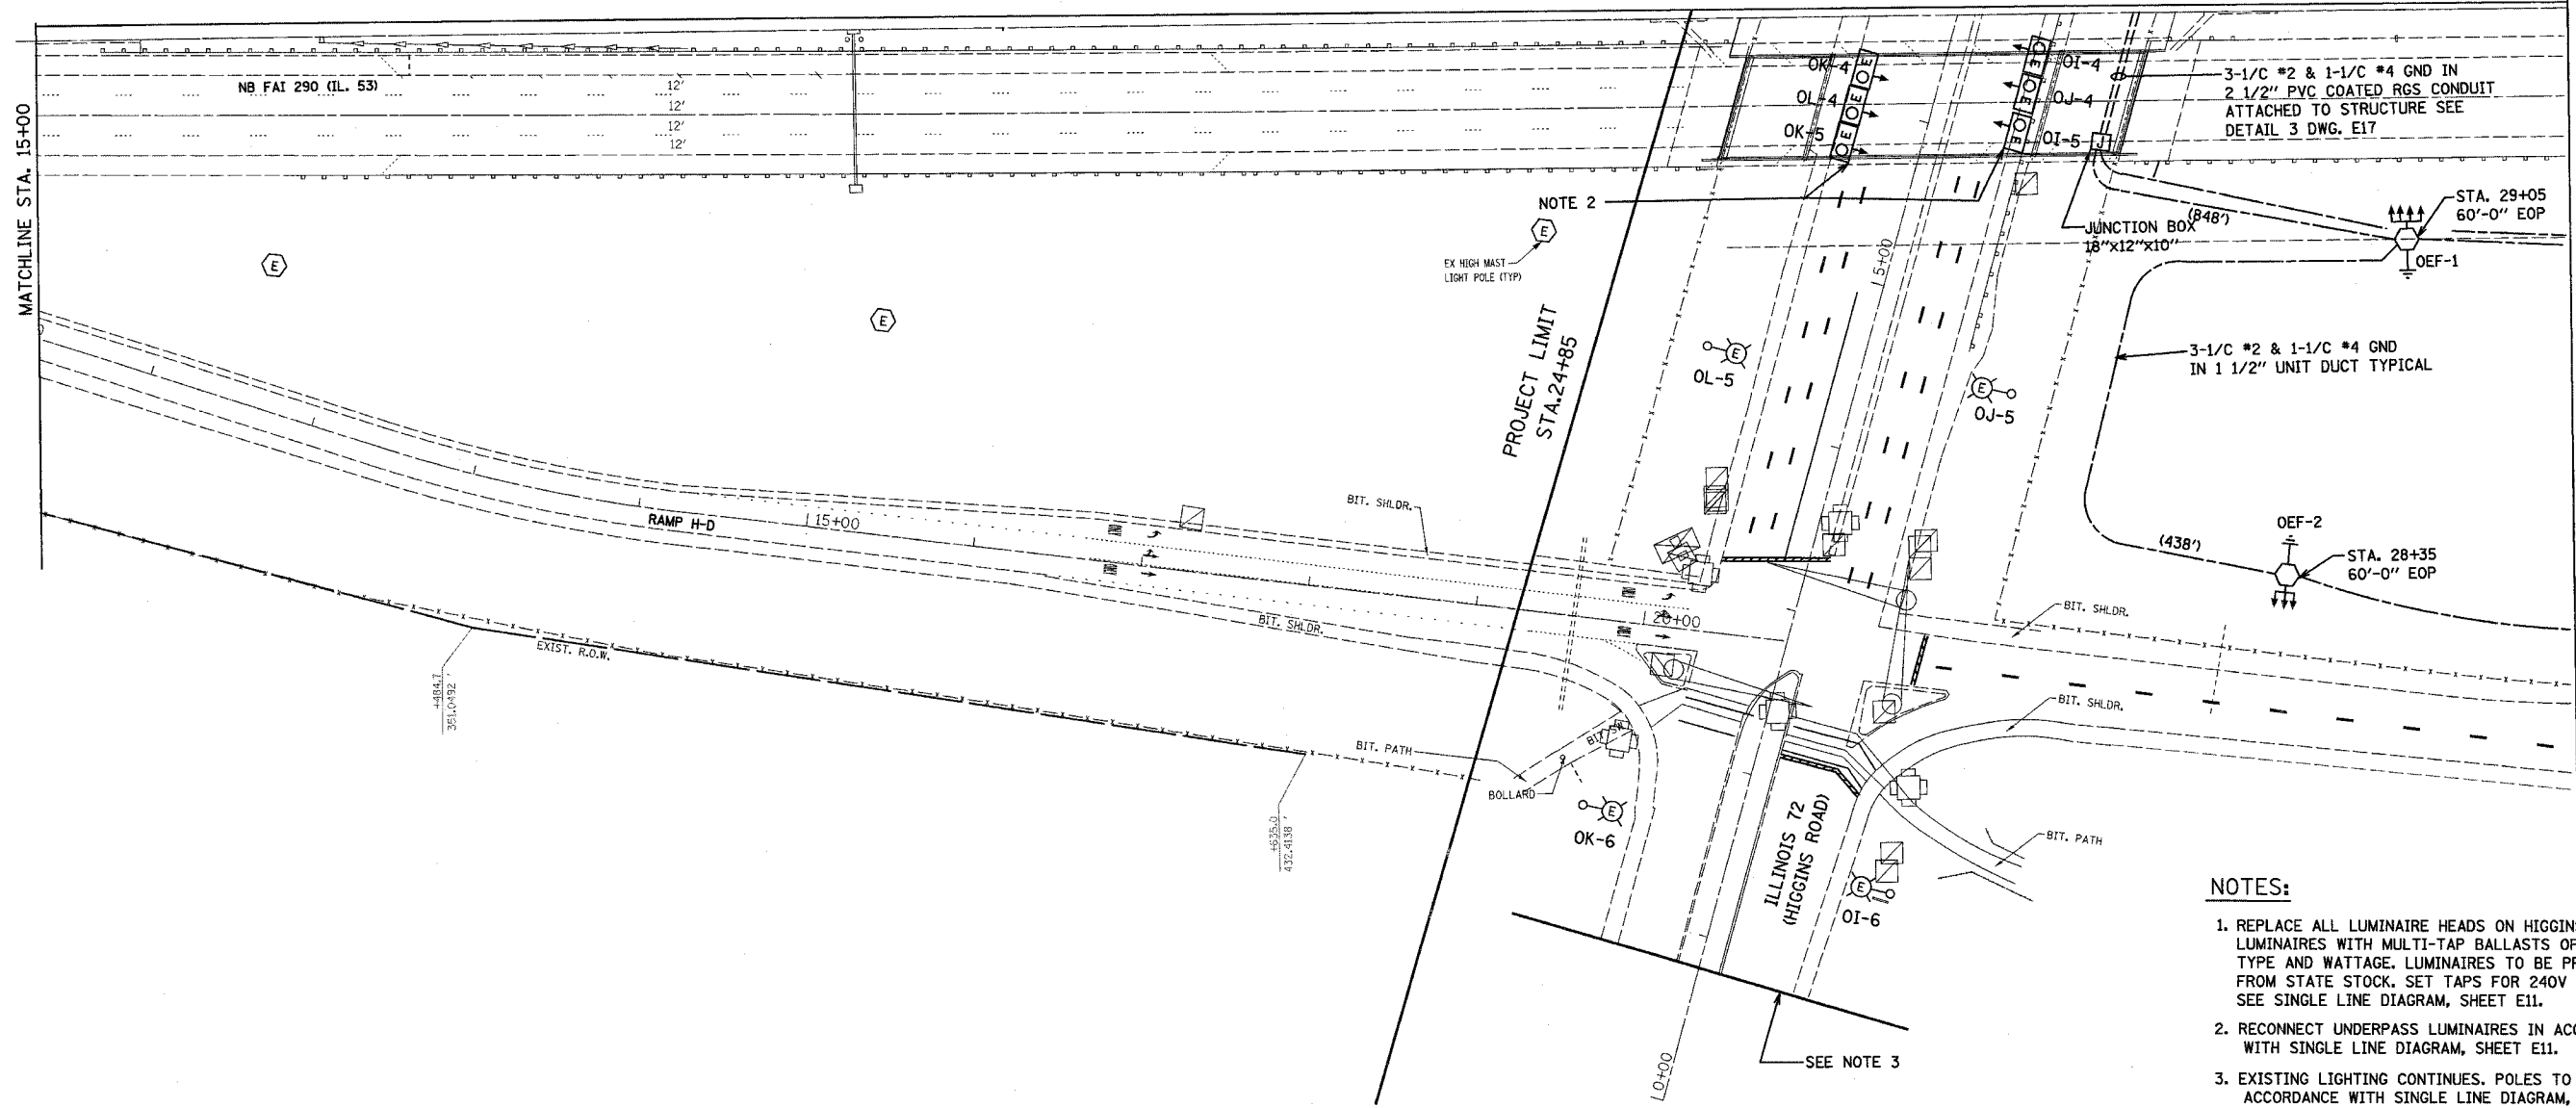

NOTES:

 1. REPLACE ALL LUMINAIRE HEADS ON HIGGINS RD. WITH LUMINAIRES WITH MULTI-TAP BALLASTS OF THE SAME TYPE AND WATTAGE. LUMINAIRES TO BE PROVIDED FROM STATE STOCK. SET TAPS FOR 240V OPERATION. SEE SINGLE LINE DIAGRAM, SHEET E11.
2. RECONNECT UNDERPASS LUMINAIRES IN ACCORDANCE WITH SINGLE LINE DIAGRAM, SHEET E11.
3. EXISTING LIGHTING CONTINUES. POLES TO BE RELAELED IN ACCORDANCE WITH SINGLE LINE DIAGRAM, SHEET E11.



EAST HALF OF INTERCHANGE

REVISIONS	
NAME	DATE

ILLINOIS DEPARTMENT OF TRANSPORTATION
LIGHTING PLAN
 ILLINOIS ROUTE 53
 EAST HALF OF HIGGINS RD.
 I-53 INTERCHANGE

SCALE: VERT. 1"=50'
 HORIZ. 1"=50'
 DATE 02-28-2005
 DRAWN BY MEK
 CHECKED BY RER

HOH HARRY O. HEFTER - ASSOCIATES, INC. 50 East Jackson Blvd. Chicago, Illinois 60604
 DESIGN AND CONSULTING ENGINEERS 312/346-9131
 PROJECT NUMBER 2672
 FILE PATH: G:\PROJECTS\2672\DOCS\FINAL_04_01_05\SEGMENT 1\LIGHTING

PLOT DATE = 04/28/2005
 FILE NAME = #FILE#
 PLOT SCALE = #RCS#
 REFERENCE = #RCS#

E2