


DATE TIME  
DESIGNER  
USER

CONTRACT NO. 62877

F.A.I. RTE.	SECTION	COUNTY	TOTAL SHEETS	SHEET NO.
290	0305-302K-L-3	COOK		19
STA.	TO STA.			
FED. ROAD DIST. NO.	ILLINOIS	FED. AID PROJECT		

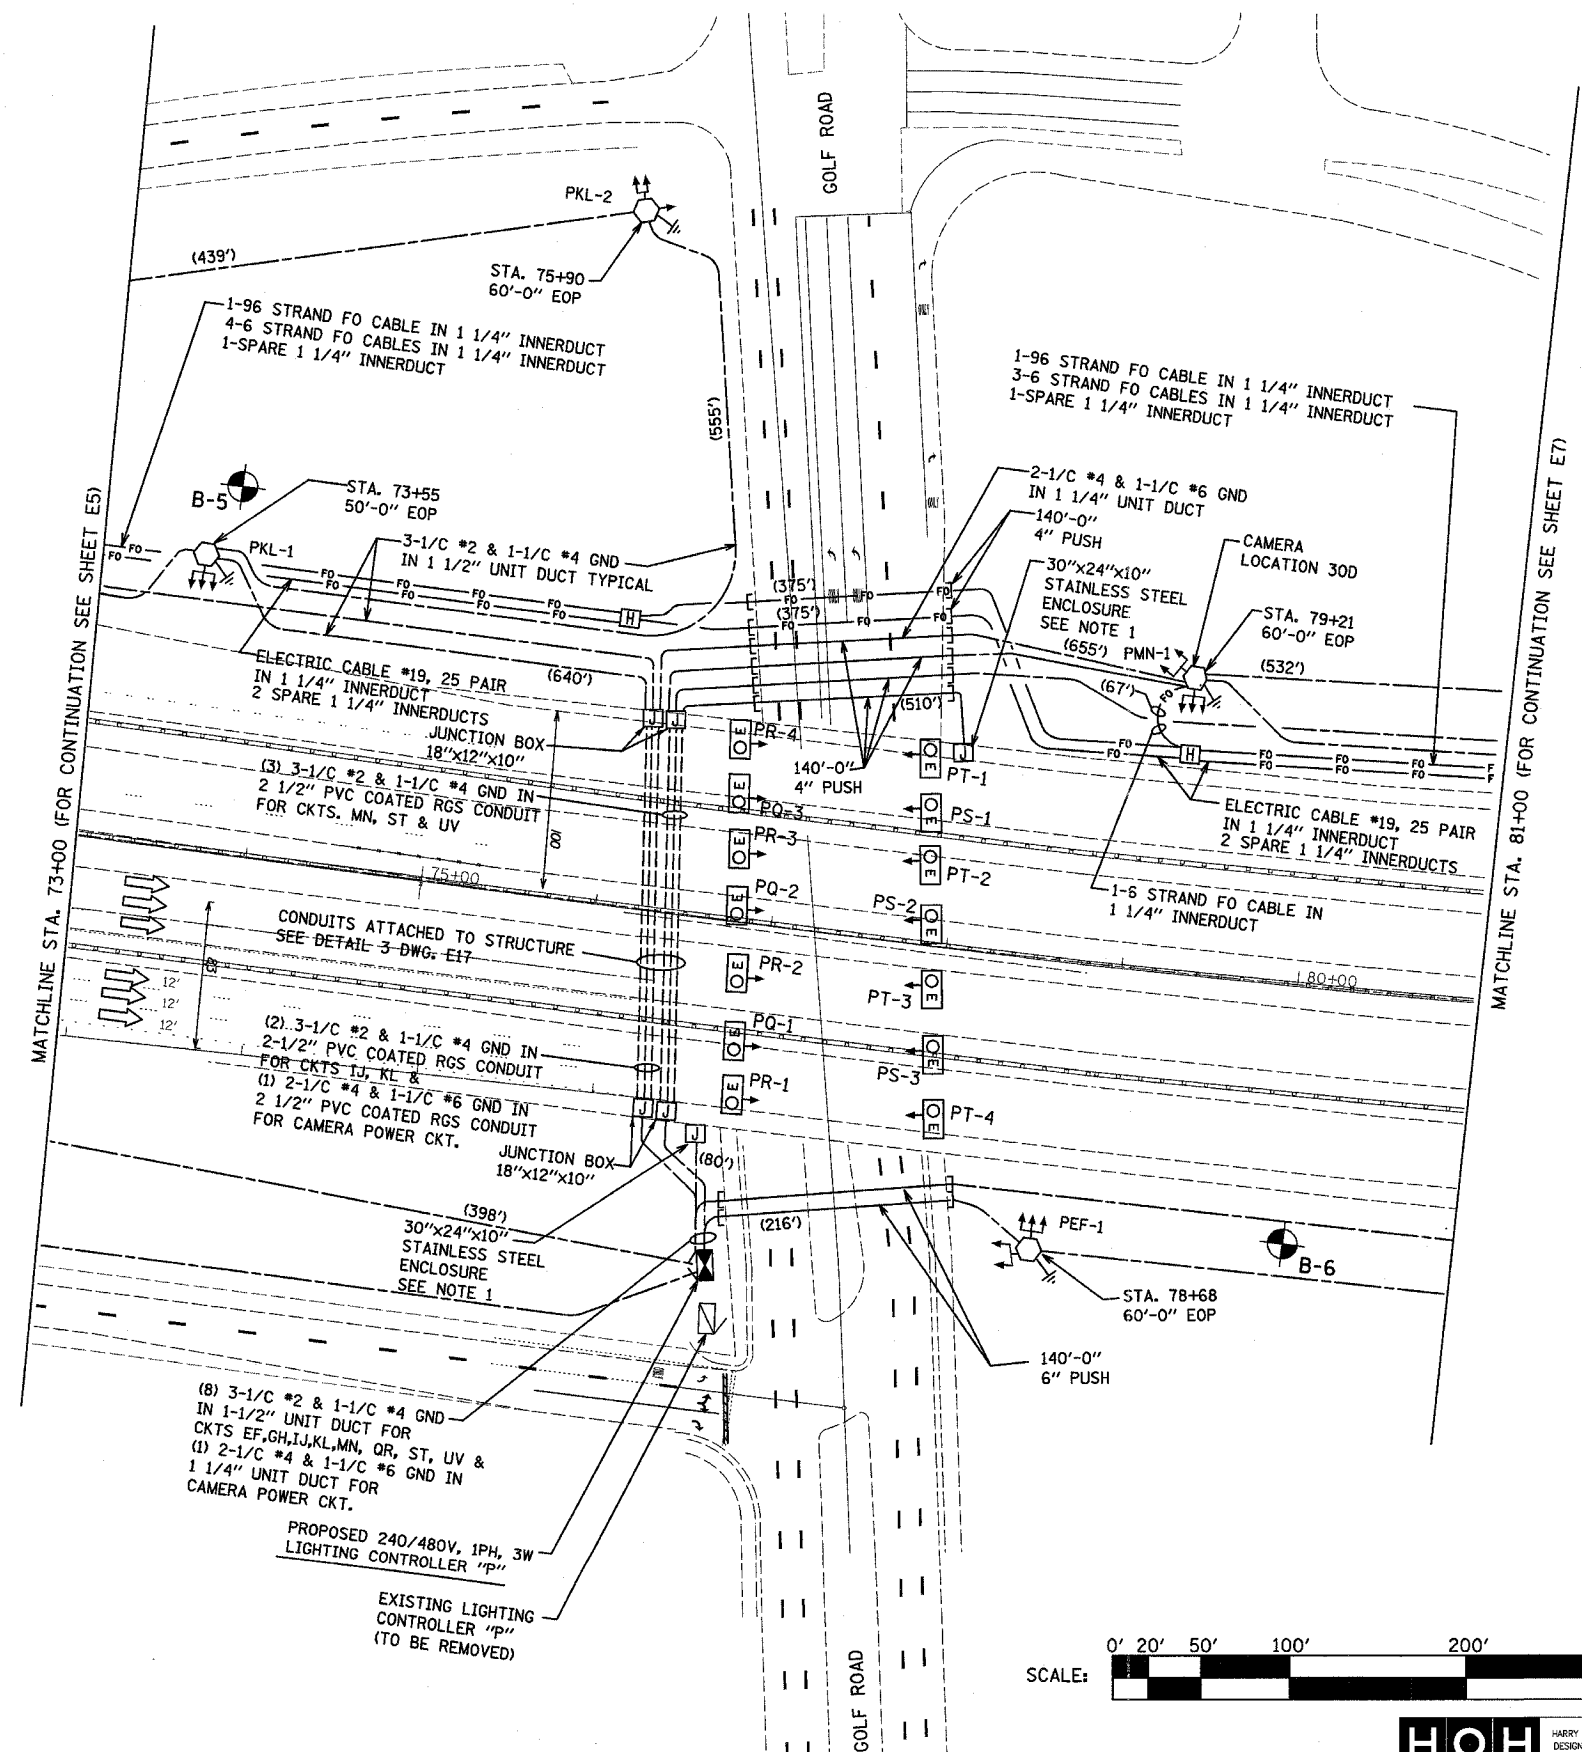


MATCHLINE STA. 73+00 (FOR CONTINUATION SEE SHEET E5)

MATCHLINE STA. 81+00 (FOR CONTINUATION SEE SHEET E7)

**NOTES:**

 1. RE-CONNECT UNDERPASS LIGHTING CIRCUITS IN ACCORDANCE WITH CONTROLLER "P" CIRCUIT DIAGRAM SHEET E12 AND RE-LABEL ALL ASSOCIATED LUMINAIRE NUMBERING DECALS. SEE DETAIL#1 SHEET E16 FOR TRANSFORMER MOUNTING DETAILS.

PLOT DATE = 04/29/2005  
 FILE NAME = 0305-302K-L-3  
 SHEET NO. = 19  
 REFERENCE = 485E7



**HOH** HARRY D. HETTER - ASSOCIATES, INC.  
 DESIGN AND CONSULTING ENGINEERS  
 55 East Jackson Blvd.  
 Chicago, Illinois 60604  
 312/348-8131

PROJECT NO. 2672  
 G:\PROJECTS\2012\LOGS\FINAL\_04\_01\_05\SEGMENT 1\LIGHTING

REVISIONS	
NAME	DATE

ILLINOIS DEPARTMENT OF TRANSPORTATION  
**LIGHTING PLAN**  
 ILLINOIS ROUTE 53  
 I-53 AT GOLF ROAD

SCALE: VERT. 1"=50'  
 HORIZ. 1"=100'  
 DATE 02-28-2005  
 DRAWN BY MEK  
 CHECKED BY RER

E6