




F.A. RTE.	SECTION	COUNTY	TOTAL SHEETS	SHEET NO.
290	0205-302K-3	COOK	55	41
STA.		TO STA.		
FED. ROAD DIST. NO.		ILLINOIS FED. AID PROJECT		

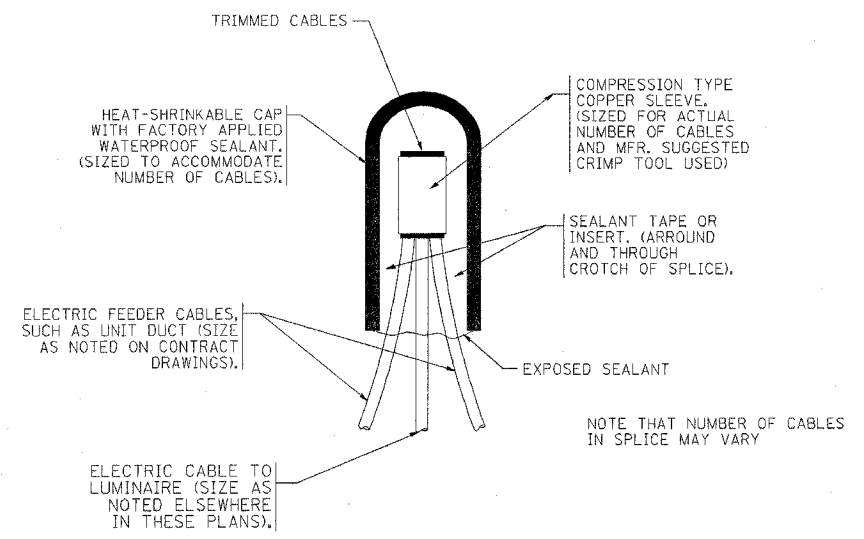

TYPICAL SPLICE DETAIL
N.T.S.

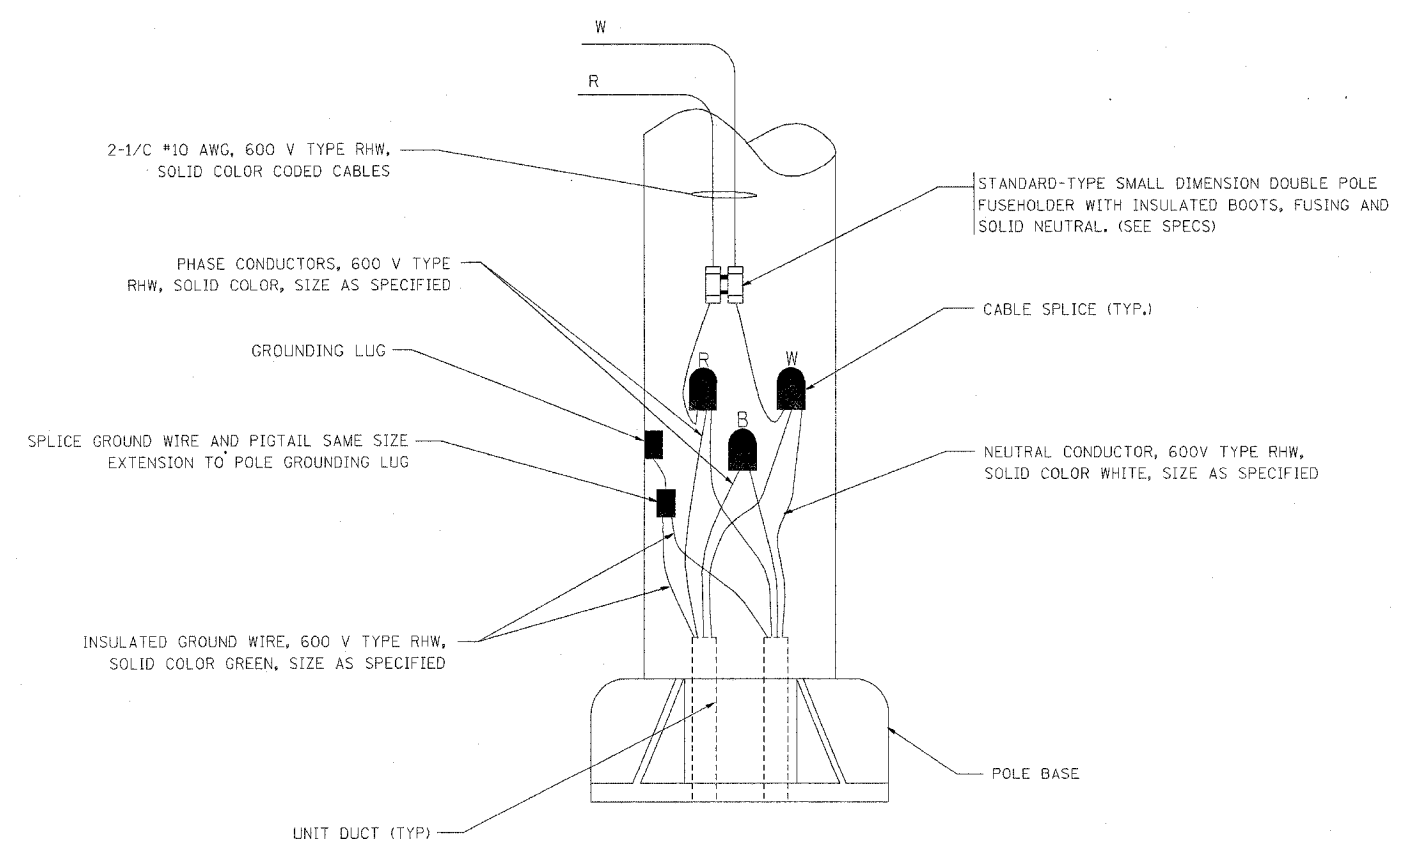

POLE WIRING DETAIL
N.T.S.

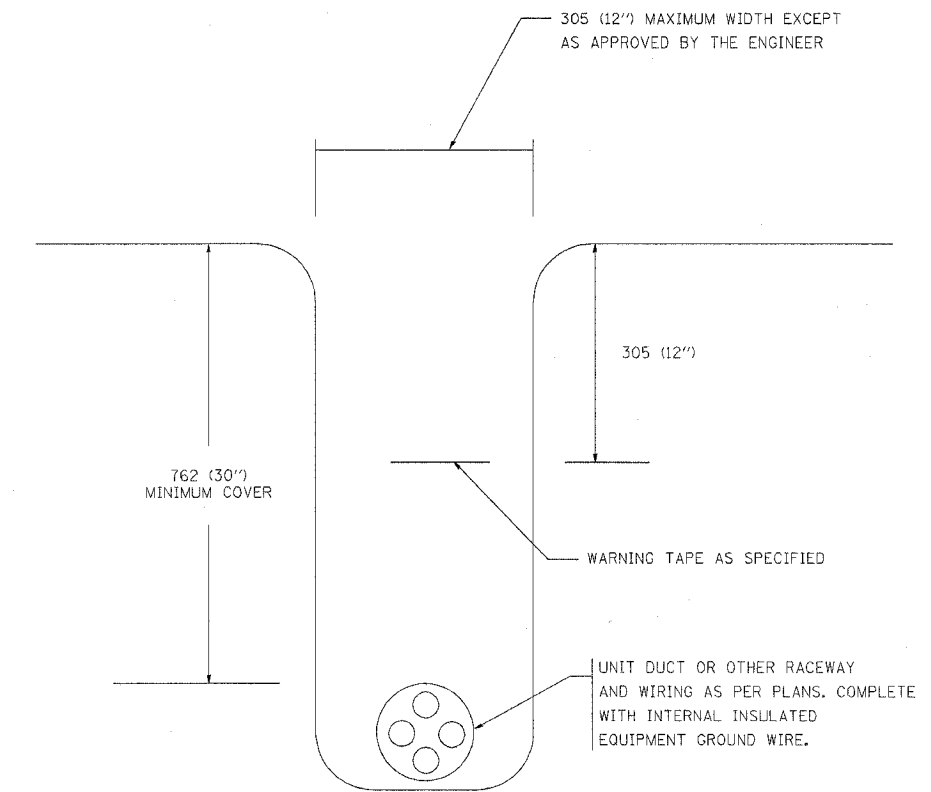

TYPICAL WIRING IN TRENCH DETAIL
N.T.S.

REVISIONS		ILLINOIS DEPARTMENT OF TRANSPORTATION
NAME	DATE	
		MISC. ELECTRICAL DETAILS SHEET A
SCALE: NONE		DRAWN BY
DATE 05/19/2003		CHECKED BY