
 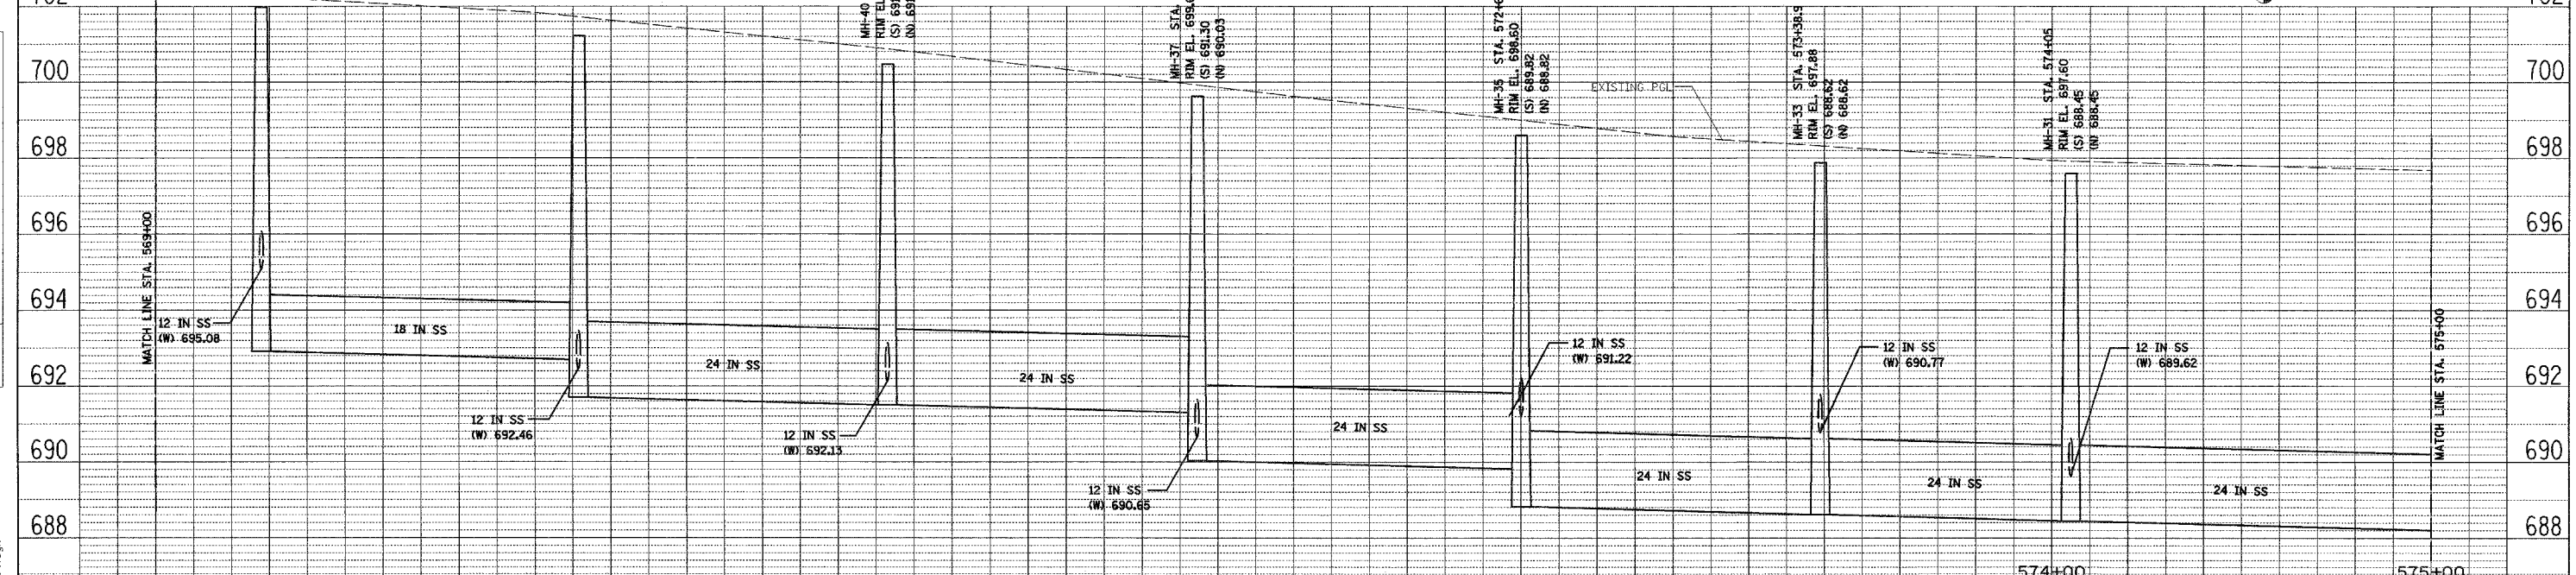



F.A. RTE.	SECTION	COUNTY	TOTAL SHEETS	SHEET NO.
649	67(T)RS-2&1	MARSHALL	74	25
STA. 569+00		TO STA. 575+00		
FED. ROAD DIST. NO. ILLINOIS FED. AID PROJECT				
D-93-053-03 CONTRACT NUMBER 66403				

PLAN	DATE
BY	
CHECKED	
DATE	
NO.	

PROF. ILE	DATE
BY	
CHECKED	
DATE	
NO.	

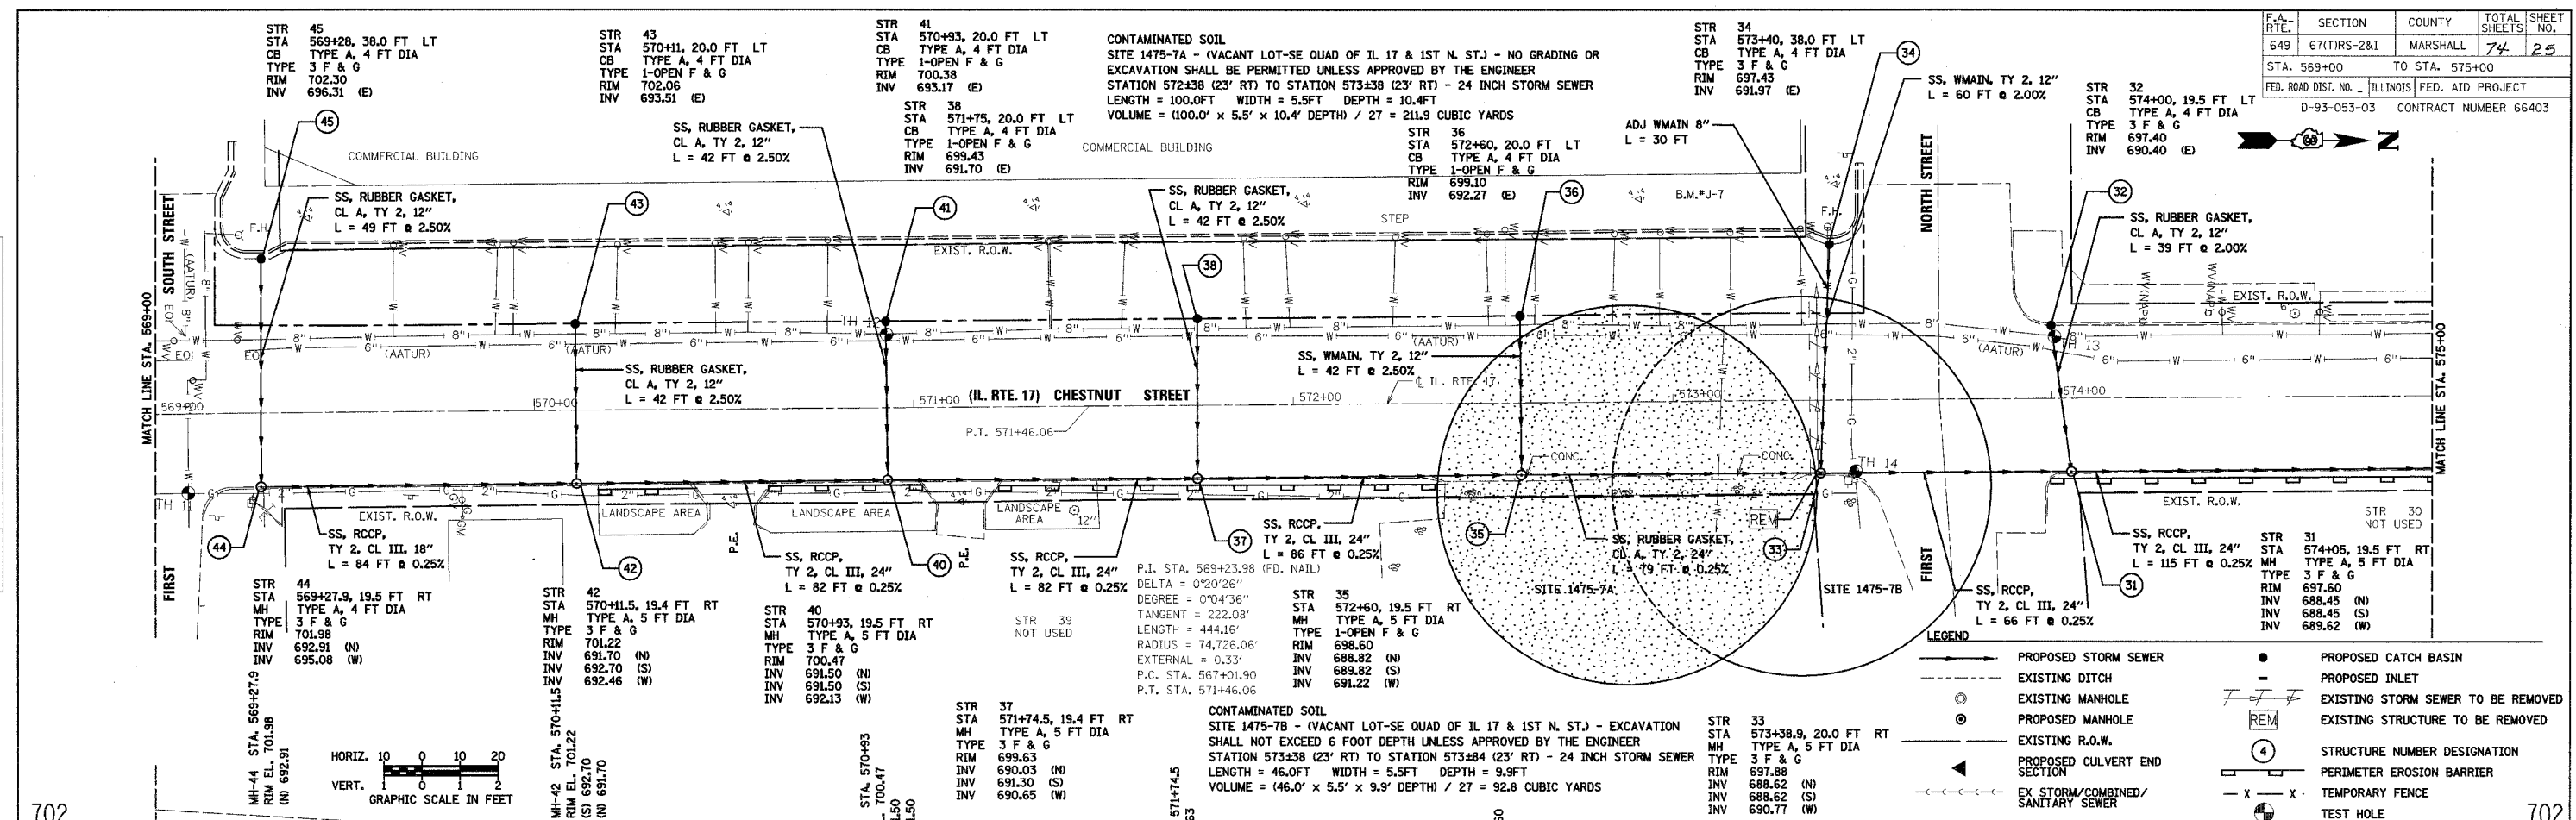

CONSULTANT

**COLLINS ENGINEERS**

123 N. WACKER DR., SUITE 300  
CHICAGO, IL 60606  
(312) 704-9300

ILLINOIS PROFESSIONAL DESIGN FIRM  
LICENSE NO. 184-000993

NAME	DATE

ILLINOIS DEPARTMENT OF TRANSPORTATION

**ILLINOIS ROUTE 17  
DRAINAGE AND UTILITY PLAN  
AND PROFILE**  
(SHEET 5 OF 7)

SCALE: HORIZ. 1:20  
VERT. 1:2

DATE MARCH, 2005

DRAWN BY DR  
CHECKED BY JMH

FILE: g:\3846-16-04\38460004.dgn  
DATE: 30-Sep-04 12:27