


F.A.I. RTE.	SECTION	COUNTY	TOTAL SHEETS	SHEET NO.
74	(72-71R-3)	PEORIA	1360	1204
STA.	TO STA.			
FED. ROAD DIST. NO.	ILLINOIS	FED. AID PROJECT		


CONTRACT NO. 68200

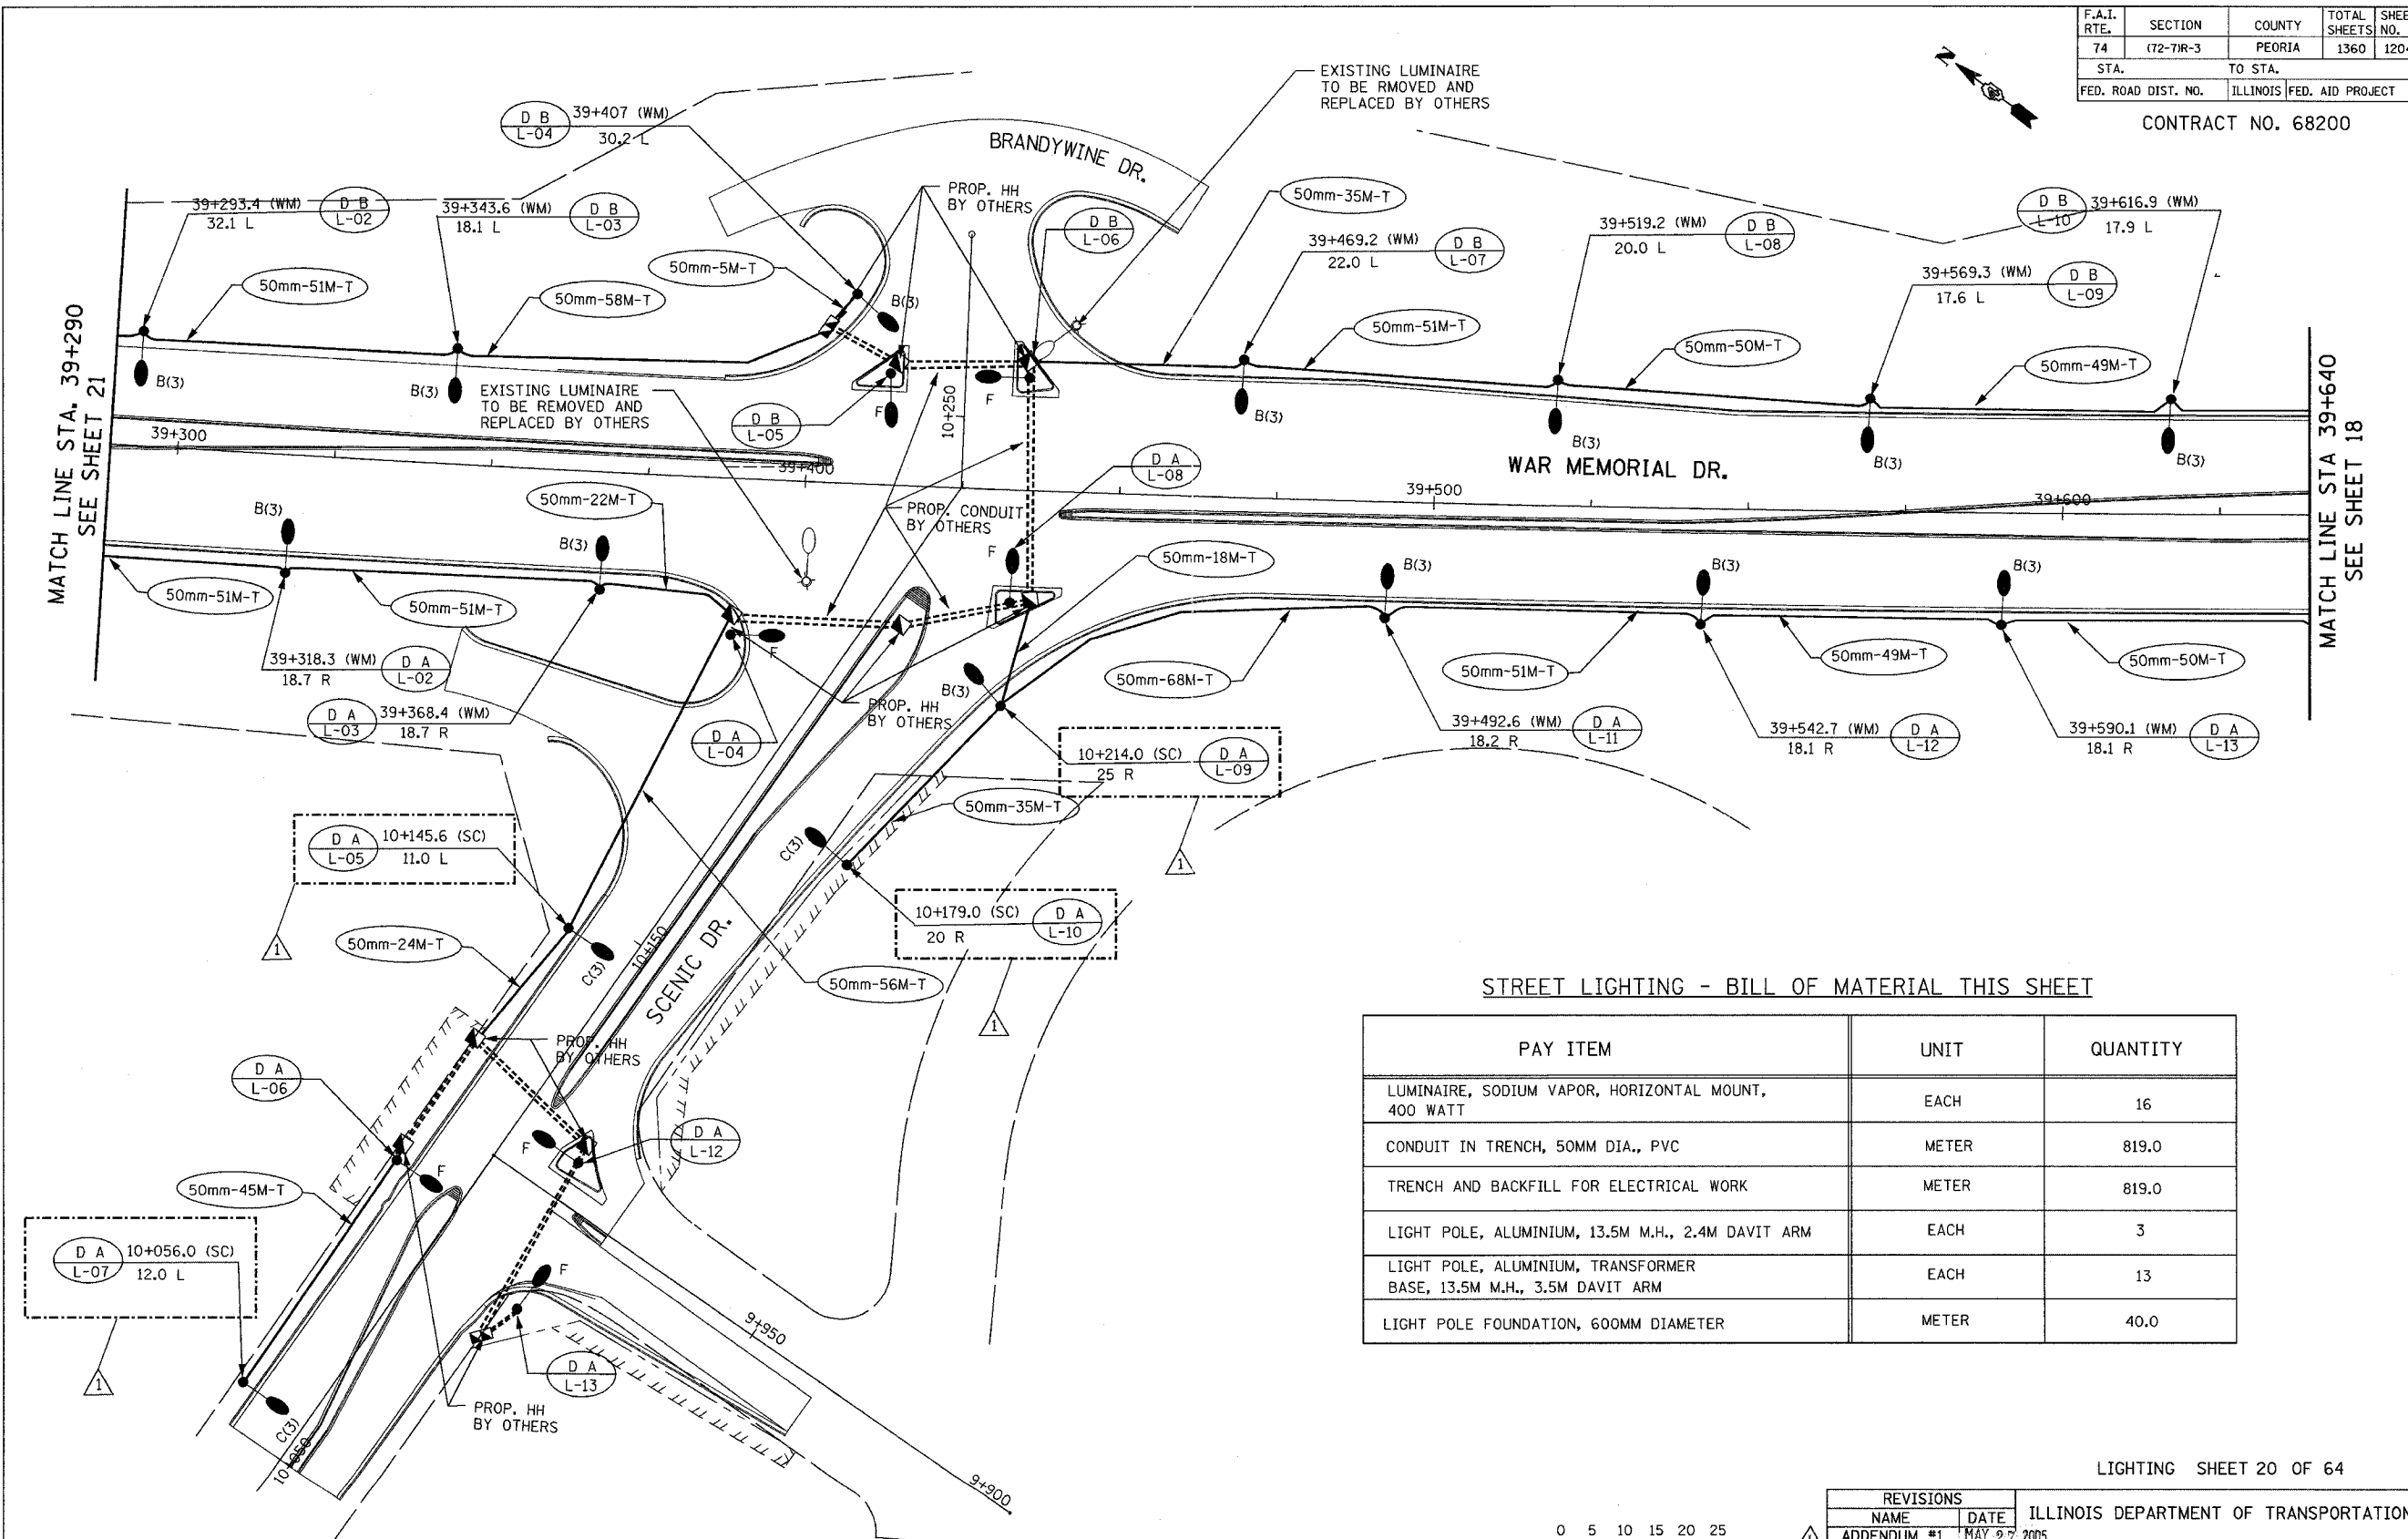

STREET LIGHTING - BILL OF MATERIAL THIS SHEET

PAY ITEM	UNIT	QUANTITY
LUMINAIRE, SODIUM VAPOR, HORIZONTAL MOUNT, 400 WATT	EACH	16
CONDUIT IN TRENCH, 50MM DIA., PVC	METER	819.0
TRENCH AND BACKFILL FOR ELECTRICAL WORK	METER	819.0
LIGHT POLE, ALUMINIUM, 13.5M M.H., 2.4M DAVIT ARM	EACH	3
LIGHT POLE, ALUMINIUM, TRANSFORMER BASE, 13.5M M.H., 3.5M DAVIT ARM	EACH	13
LIGHT POLE FOUNDATION, 600MM DIAMETER	METER	40.0

 LIGHTING SHEET 20 OF 64



REVISIONS	
NAME	DATE
ADDENDUM #1	MAY 27 2005

ILLINOIS DEPARTMENT OF TRANSPORTATION  
 PROPOSED LIGHTING PLAN  
 WAR MEMORIAL DR.  
 STA. 39+290 TO STA. 39+640  
 DRAWN BY DJK  
 CHECKED BY MKR  
 DATE: 1/25/2005

**ab** alfred benesch & company  
 CONSULTING ENGINEERS  
 205 NORTH MICHIGAN AVENUE, CHICAGO, ILLINOIS 60601

m:\pro\35573\LIGHTING\4-Contract\01\1002-Tavm.dgn

1:37:29 PM

4/21/2005