 


F.A.I. RTE.	SECTION	COUNTY	TOTAL SHEETS	SHEET NO.
74	(72-7)R-3	PEORIA	1360	1205
STA.	TO STA.			
FED. ROAD DIST. NO.	ILLINOIS	FED. AID PROJECT		


STREET LIGHTING - BILL OF MATERIAL THIS SHEET

PAY ITEM	UNIT	QUANTITY
ELECTRIC SERVICE INSTALLATION	EACH	1
CONCRETE HANDHOLE	EACH	2
LUMINAIRE, SODIUM VAPOR, HORIZONTAL MOUNT, 400 WATT	EACH	9
CONDUIT IN TRENCH, 50MM DIA., PVC	METER	491.0
TRENCH AND BACKFILL FOR ELECTRICAL WORK	METER	491.0
LIGHT POLE, ALUMINUM, TRANSFORMER BASE, 13.5M M.H., 2.4M DAVIT ARM	EACH	9
LIGHT POLE FOUNDATION, 600MM DIAMETER	METER	22.5
INSTALL CONTROLLER	EACH	1

CONTRACT NO. 68200



5/15/2005 3:00:16 PM m:\proj\3573\LIGHTING\F-Contract 1011001-Towmdgn

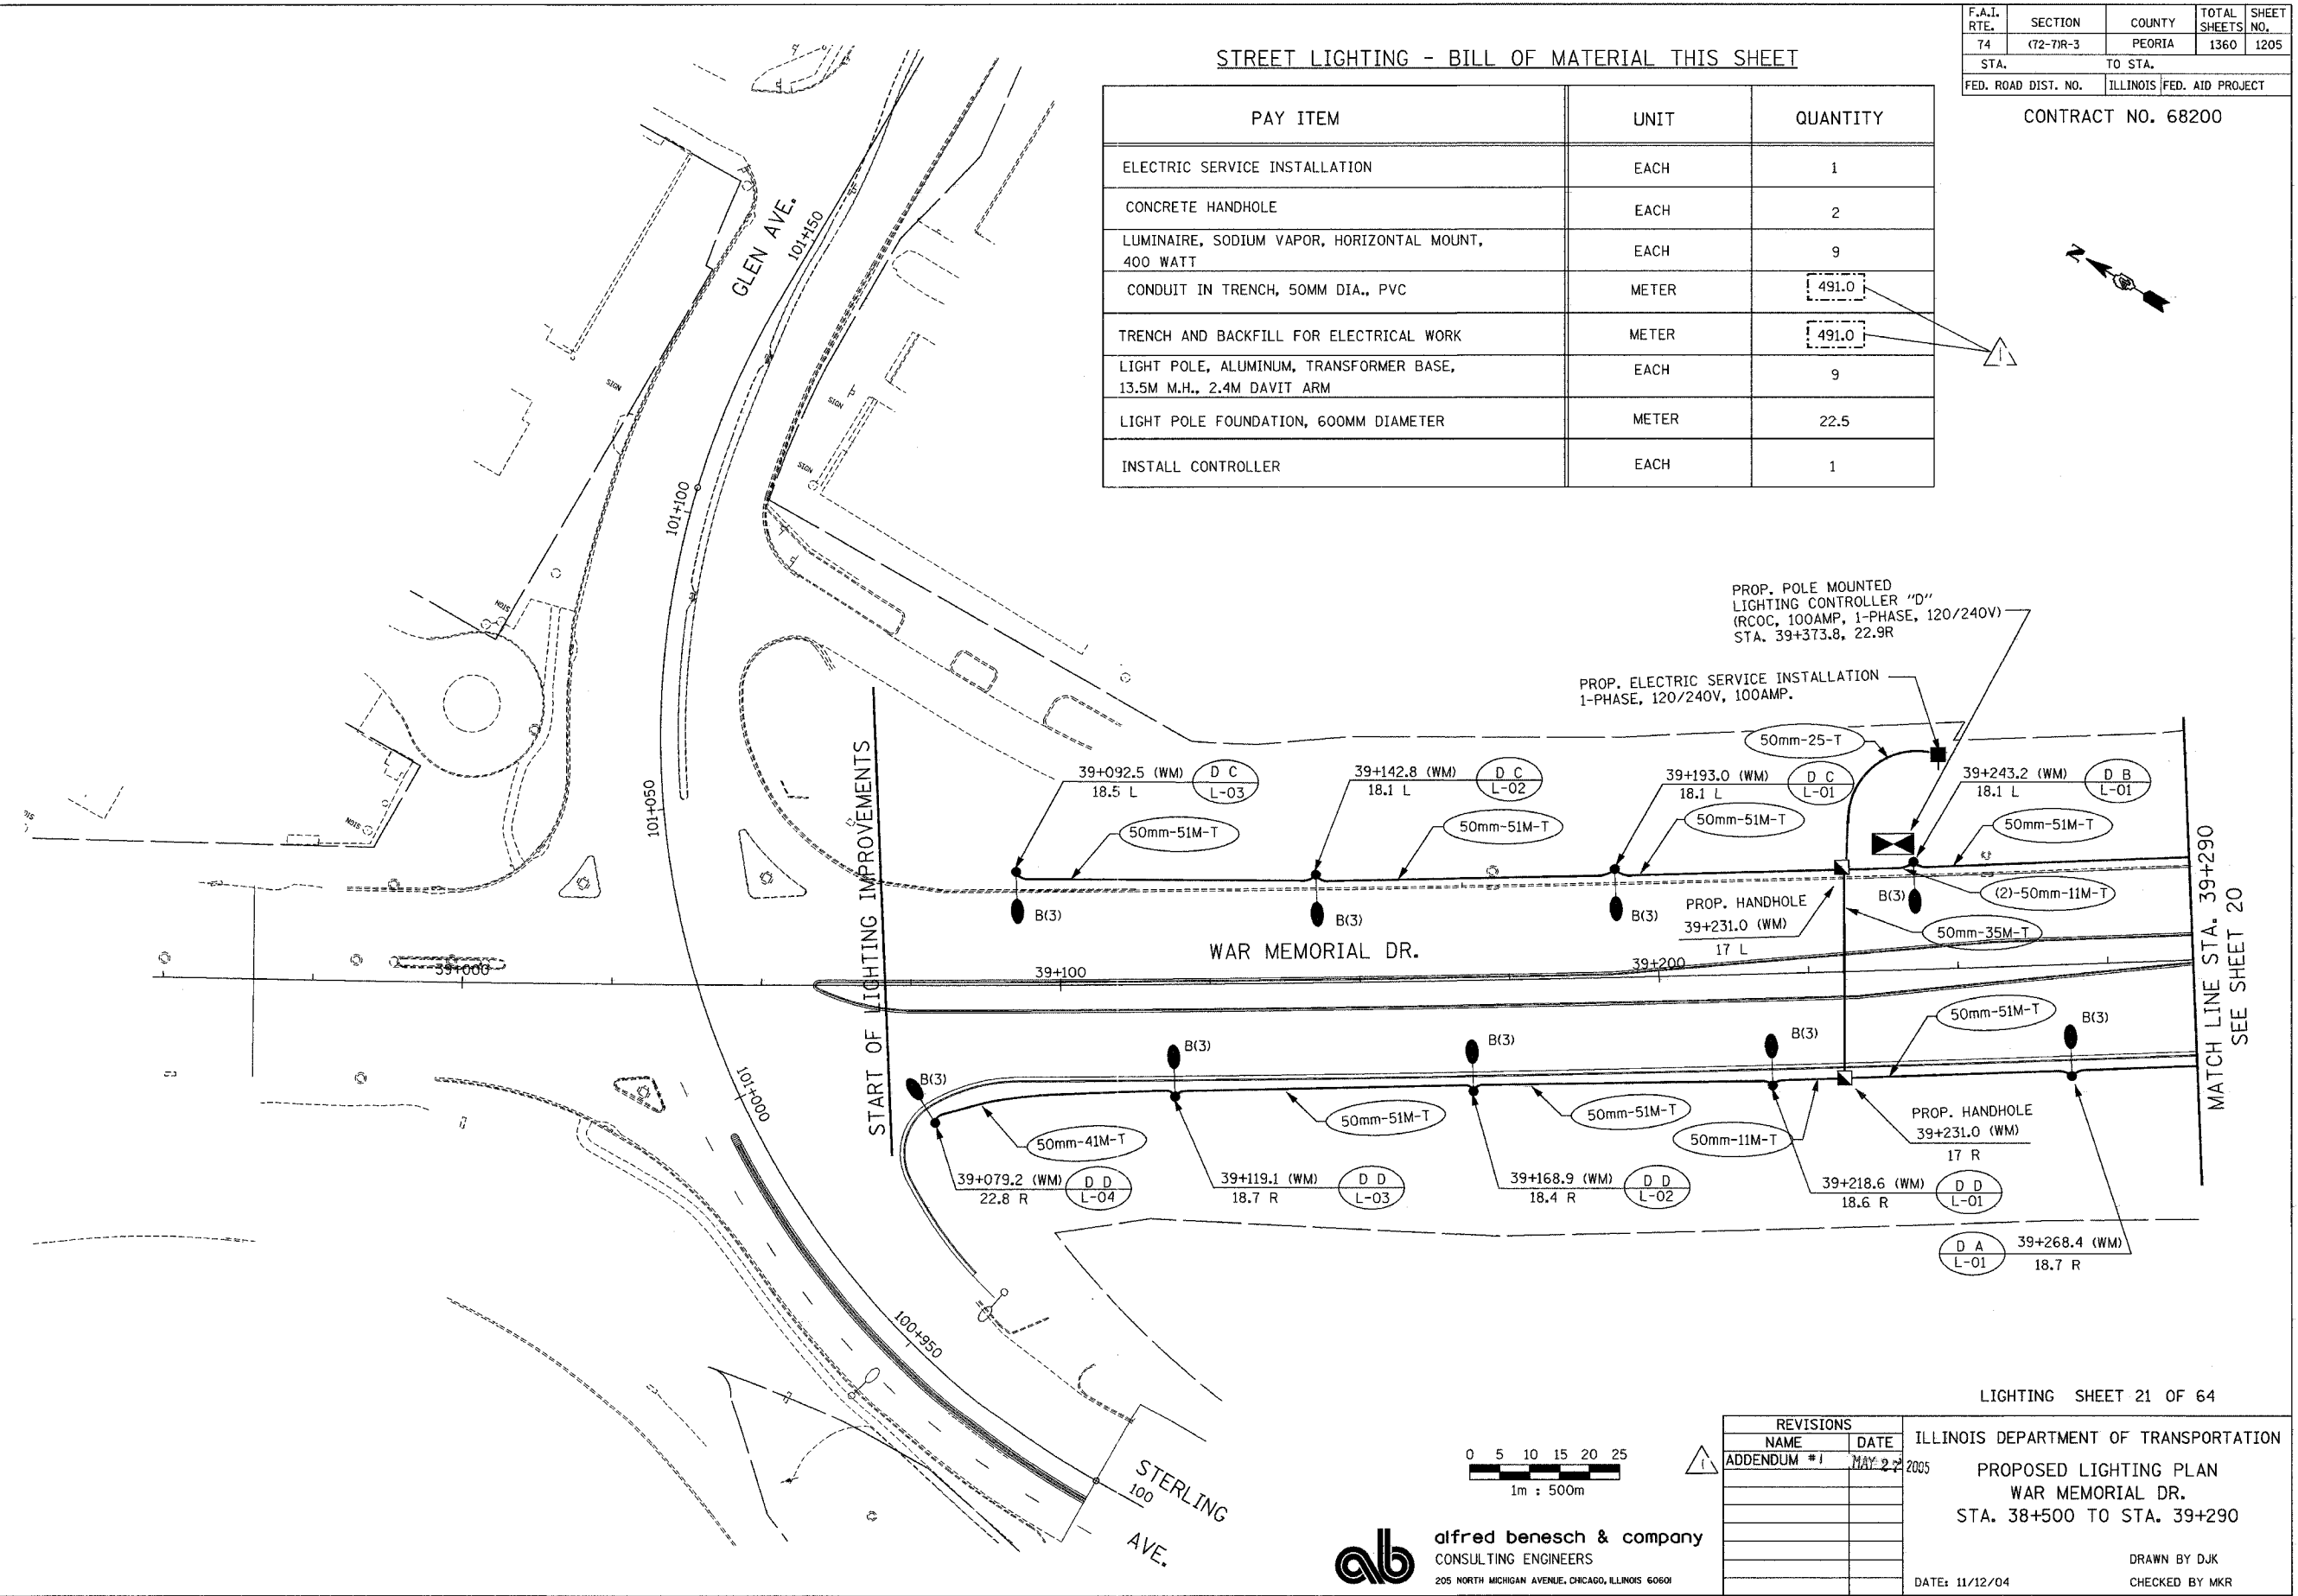

**alfred benesch & company**  
 CONSULTING ENGINEERS  
 205 NORTH MICHIGAN AVENUE, CHICAGO, ILLINOIS 60601

REVISIONS	
NAME	DATE
ADDENDUM #1	MAY 22 2005

ILLINOIS DEPARTMENT OF TRANSPORTATION  
 PROPOSED LIGHTING PLAN  
 WAR MEMORIAL DR.  
 STA. 38+500 TO STA. 39+290  
 DATE: 11/12/04  
 DRAWN BY DJK  
 CHECKED BY MKR

LIGHTING SHEET 21 OF 64